


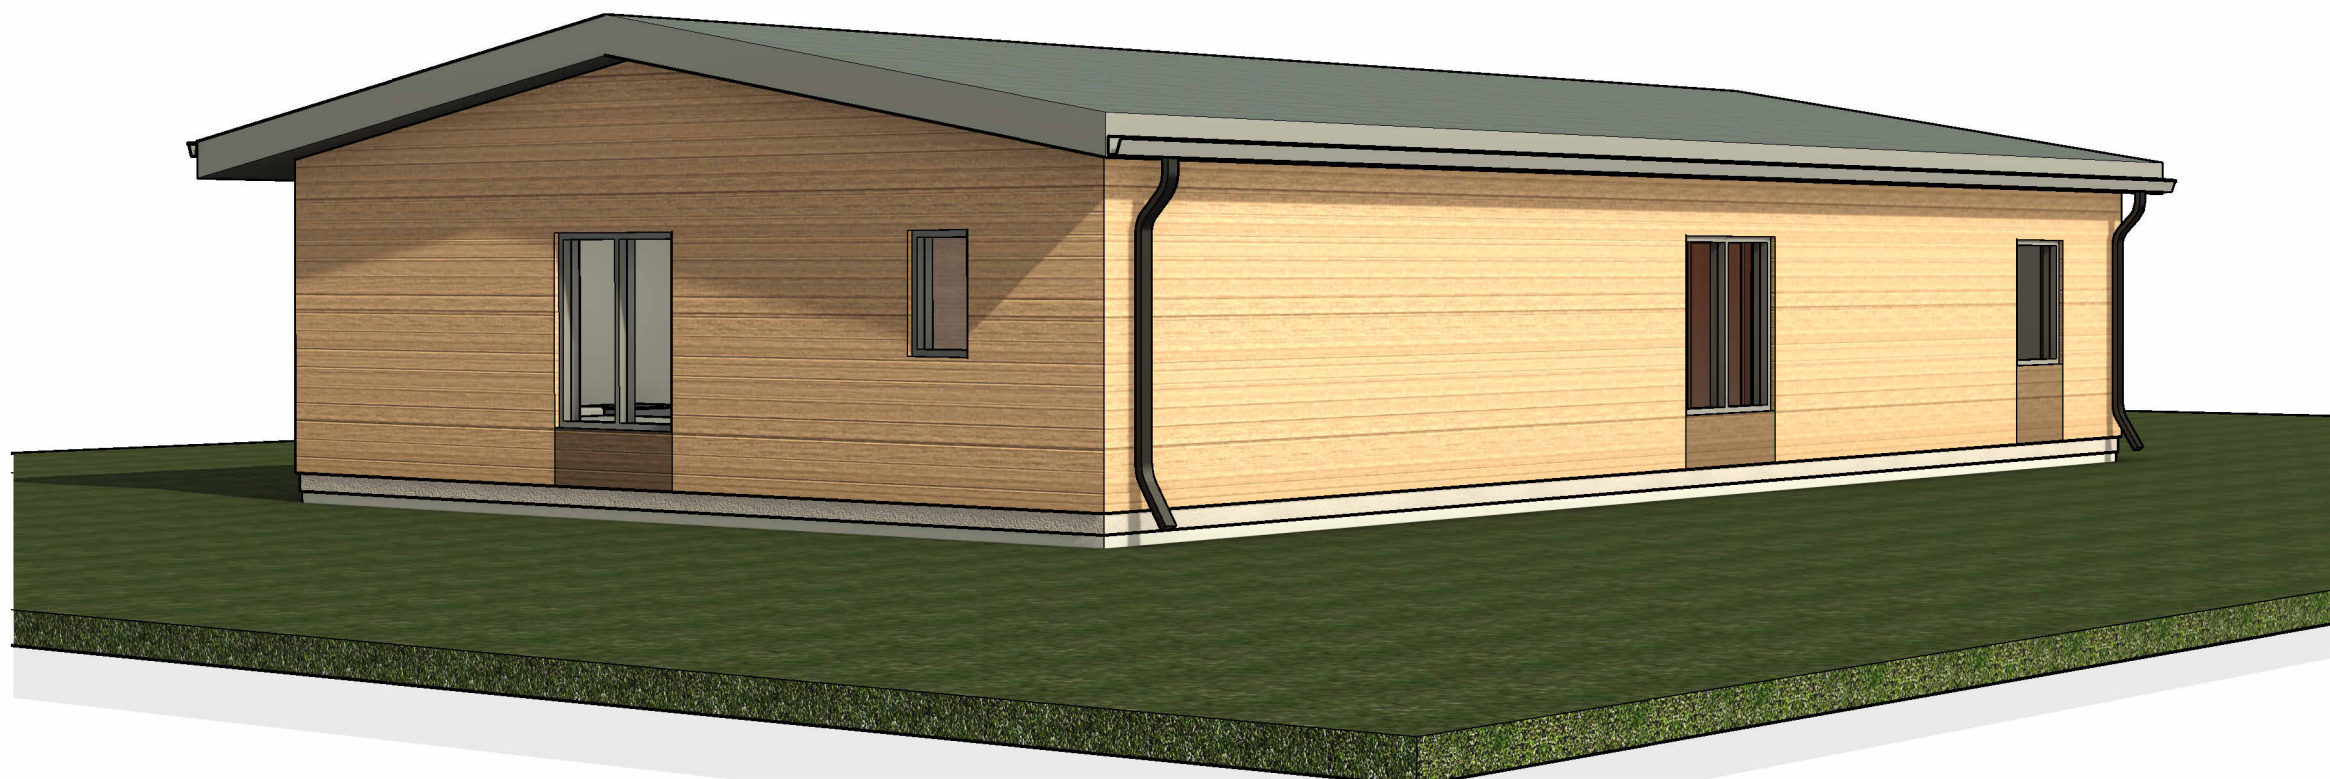

EXTERIOR BUILDING RENDERING- ARTISTS PERSPECTIVE - E&O.E. EXTRA



GENERAL NOTES


1. ALL CONSTRUCTION TO MEET THE 2012 ONTARIO BUILDING CODE (OBC, ONTARIO REGULATION 403/12, AMENDED 0 REG 22/99 & 102/98) REQUIREMENTS.
2. INSPECT SITE CONDITIONS PRIOR TO QUOTING ON NEW WORK AND REPORT ANY DISCREPANCIES.
3. ENSURE THAT ALL CONSTRUCTION, MATERIALS, METHODS OF INSTALLATION AND TEMPORARY BRACING, COMPLY WITH REQUIREMENTS OF ALL AUTHORITIES HAVING JURISDICTION
4. SITE VERIFY ALL DIMENSIONS AND MAKE MODIFICATIONS TO SUIT EXISTING SITE CONDITIONS.
5. MAKE GOOD ALL AREAS DISTURBED OR DAMAGED DURING CONSTRUCTION WHETHER SHOWN ON DRAWINGS OR NOT.
6. REPORT ALL CONTEMPLATED DEVIATIONS FROM THE DRAWINGS PRIOR TO MAKING CHANGES.
7. PROVIDE CUTTING, PATCHING, AND REMEDIAL WORK IN ORDER TO ENSURE PARTS OF THE WORK COME TOGETHER PROPERLY.
8. THESE DRAWINGS ARE TO BE READ IN CONJUNCTION WITH STRUCTURAL, MECHANICAL, AND ELECTRICAL. REFER TO ARCHITECTURAL DWGS. FOR EXACT LOCATION OF FINISHED FITTINGS. MECHANICAL AND ELECTRICAL INFORMATION TO BE SUBMITTED AS REQ'D. COORDINATE STRUCTURAL, MECHANICAL, ELECTRICAL, WORK TO ENSURE THE PARTS OF THE WORK COME TOGETHER PROPERLY.
9. ARRANGE FOR ALL PERMIT APPLICATIONS & INSPECTIONS REQUIRED BY LOCAL BUILDING, PLUMBING, HYDRO, GAS, ETC., AUTHORITIES DURING CONSTRUCTION AND FOR OCCUPANCY.
10. THE PLANS SHOWN HERE DO NOT REPRESENT THE FULL LIMIT OF THE SCOPE OF WORK. PROVIDE CUTTING, PATCHING, AND REMEDIAL WORK IN ORDER TO ENSURE PARTS OF THE WORK COME TOGETHER PROPERLY.
11. THE CONTRACT DOCUMENTS WERE PREPARED BY THE CONSULTANT FOR THE ACCOUNT OF THE CLIENT/CONTRACTOR. THE MATERIAL CONTAINED HEREIN REFLECTS THE CONSULTANT'S BEST JUDGEMENT IN LIGHT OF THE INFORMATION AVAILABLE TO TIME AT THE TIME OF PREPARATION. ANY USE WHICH A THIRD PARTY MAKES OF THE CONTRACT DOCUMENTS, OR ANY RELIANCE ON OR DECISIONS TO BE MADE BASED ON THEM ARE THE RESPONSIBILITY OF SUCH THIRD PARTIES. THE CONSULTANT ACCEPTS NO RESPONSIBILITY FOR DAMAGES, IF ANY, SUFFERED BY A THIRD PARTY AS A RESULT OF DECISIONS MADE OR ACTIONS BASED ON THE CONTRACT DOCUMENTS.
12. IT IS THE INTENT OF THESE SPECIFICATIONS TO FURNISH AND INSTALL ALL MATERIALS AND EQUIPMENT AS HEREINAFTER SPECIFIED AND/OR SHOWN ON THE DRAWINGS IN SUCH A MANNER AS TO LEAVE EACH SYSTEM COMPLETE AND SATISFACTORY OPERATING CONDITION.
14. SHOP DRAWINGS: (6 SETS) SHALL BE SUBMITTED FOR ALL EQUIPMENT INCLUDING FIXTURES AND WATER HEATERS.
15. ALL EQUIPMENT AND MATERIALS SHALL BE NEW.
16. THIS CONTRACTOR SHALL INCLUDE EXCAVATION, REMOVAL OF MATERIALS PERTAINING TO HIS OWN WORK, BACKFILLING AND COMPACTING WILL BE DONE BY OTHERS.
17. CUTTING AND PATCHING REQUIRED FOR THE COMPLETE INSTALLATION OF THIS CONTRACT SHALL BE BY THIS CONTRACTOR.
18. THIS CONTRACTOR IS TO OBTAIN AND PAY ALL PERMITS, NOTICES, FEES, AND APPROVALS NECESSARY TO FULFILL THE REQUIREMENTS OF THE CONTRACT. THIS CONTRACTOR SHALL GUARANTEE THE WORK, EQUIPMENT, MATERIALS AND SYSTEMS FOR A PERIOD OF ONE YEAR FROM DATE OF FINAL ACCEPTANCE BY OWNER.
19. EACH CONTRACTOR TO ALLOW FOR FLASHING PERTAINING TO HIS OWN WORK. COUNTER FLASHING IS BY ROOFING CONTRACTOR. GENERAL WORK INCLUDING STRUCTURAL SUPPORT TO BE DONE BY THE GENERAL CONTRACTOR.
20. TEST ALL SYSTEMS IN ACCORDANCE WITH CODES AND OBTAIN INSPECTION CERTIFICATES. WIRING OF CONTROLS FOR THERMOSTATS BY ELECTRICAL CONTRACTOR. BASEBOARD HEATERS SHOWN, ARE SUPPLIED AND INSTALLED BY ELECTRICAL CONTRACTOR.
21. THOROUGHLY BROOM CLEAN AND REMOVE FROM SITE ALL WASTE AS THE WORK PROCEEDS AND AT COMPLETION.
22. PROVIDE STRAPPING AND BLOCKING FOR SUPPORT OF ANY FINISHES, GRAB BARS, EQUIPMENT AS REQUIRED.
23. CONTRACTOR RESPONSIBLE TO RESTORE ALL DAMAGED AND/OR DISTURBED PROPERTY WITHIN THE MUNICIPAL RIGHT-OF-WAY TO MUNICIPAL STANDARDS.
24. IF FOR UNFORESEEN REASONS THE CONTRACTOR MAY HAVE TO ENCROACH ONTO PRIVATE LANDS TO UNDERTAKE ANY WORKS, THE CONTRACTOR SHALL OBTAIN WRITTEN PERMISSION FROM THE ADJACENT PROPERTY OWNERS PRIOR TO ENTERING UPON THE PRIVATE PROPERTY TO PERFORM ANY WORKS. COPIES OF THESE LETTERS OF CONSENT SHALL BE SUBMITTED TO THE DEPARTMENT OF PUBLIC WORKS PRIOR TO ANY WORK BEING PERFORMED. FAILURE TO COMPLY WITH THE ABOVE IS AT THE CONTRACTOR'S OWN RISK.

ABBREVIATIONS

AIR	AIR	FIN	FINISH	RCP	REFLECTED CEILING PLAN
ACT	ACOUSTIC CEILING	FLR	FLOOR	RD	ROOF DRAIN
A.F.F.	ABOVE FINISHED FLOOR	FRP	FIBERGLASS REINFORCED PANEL	REV	REVISION
AL/ALUM	ALUMINUM	FTG	FOOTING	REQ'D	REQUIRED
AN	ANODIZED	GA	GAUGE	RH	RIGHT HAND
APPROX	APPROXIMATE	GB	GYPSUM BOARD	RM	ROOM
BLHD	BULKHEAD	GWB	GYPSUM WALL BOARD	SACT	SUSPENDED ACOUSTIC CEILING TILE
BLDG	BUILDING	GALV	GALVANIZED	S	SINK
BM	BENCH MARK	GL	GLASS	SIM	SIMILAR
BR	BRICK	HARDW	HARDWARE	SP	SPANDREL PANEL
BD	BOARD	HB	HOSE BIB	SPEC	SPECIFICATION
CARP	CARPET	HC	HOLLOW CORE	SIS	STAINLESS STEEL
CB	CONCRETE BLOCK	HM	HOLLOW METAL	ST	STEEL
CJ	CONTROL JOINT	HSS	HOLLOW STRUCTURAL STEEL	STRUCT	STRUCTURAL
CM	CENTIMETER	HT	HEIGHT	SUSP	SUSPENDED
CLG	CEILING	HWT	HOT WATER TANK	SWC	SOLID WOOD CORE
COL	COLUMN	ICE	ICE MACHINE	SCWD	SOLID CORE WOOD
CONC	CONCRETE	INSUL	INSULATION OR INSULATED	SYN	CULTURED TILE STONE VENEER
CONT	CONTINUOUS	INT	INTERIOR	TIG	THERMAL INSULATED GLASS
CR	CARD READER	JOINT	JOINT	TBF	THERMALLY BROKEN FRAME
CT	CERAMIC TILE	LH	LEFT HAND	T&G	TONGUE AND GROOVE
				T	TRANSFORMER
CW	COLD WATER	MAX	MAXIMUM	TXT	TEXTURED
c/w	COMPLETE WITH	MECH	MECHANICAL	TGL	TEMPERED GLASS
CU	CONDENSING UNIT	MIN	MINIMUM	TTD	TOILET TISSUE DISPENSER
D	DRYER	M.U.A.	MAKE-UP-AIR	TTG	TEMPERED THERMAL INSULATING GLASS
DEG	DEGREE	MT	METAL	TYP	TYPICAL
DET	DETAIL	MISC	MISCELLANEOUS	U/S	UNDERSIDE
DIA	DIAMETER	MO	MASONRY OPENING	VCT	VINYL COMPOSITE TILE
DIM	DIMENSION	NF	NO FINISH	VEND	VENDING MACHINE
DIV	DIVISION	NA	NOT APPLICABLE	VFCT	VINYL FACED CEILING TILE
DN	DOWN	NOT	NOT AVAILABLE	VVC	VINYL WALL COVERING
DW	DRYWALL	NR	NOT REQUIRED	VTAC	VERTICAL TERMINAL AIR CONDITIONER
DWG	DRAWINGS	NIC	NOT IN CONTRACT	W	WASHER
EF	EXHAUST FAN	NO	NUMBER	WC	WATER CLOSET
ELEC	ELECTRICAL	OC	ON CENTRE	WALCO	WALL COVERINGS
ELEV	ELEVATION	PRE FIN	PREFINISHED	WD	WOOD
EQUIP	EQUIPMENT	PLAM	PLASTIC LAMINATE	WM	WIRE MESH
EX	EXISTING	PT	PAINTED	WV	WALL VINYL
EXJT	EXPANSION JOINT	PTAC	PACKAGED TERMINAL AIR CONDITIONER	WP	WATERPROOF
EXT	EXTERIOR	PVC	POLY VINYL CHLORIDE	WR	WASHROOM
FD	FLOOR DRAIN	QT	QUARRY TILE		
F	FREEZER	R	REFRIGERATOR		

CONSULTANT LIST

ARCHITECTURAL:

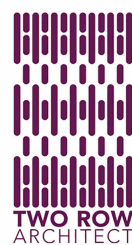

P.O. Box 77 - 1804 8th Line + Chelwood Rd.
Oshawa, ON N3A 1M0
519 445-2137 www.tworow.com info@tworow.com

ELECTRICAL:



300 VICTORIA STREET N
2ND FLOOR
KITCHENER, N2H 6R9
(519) 745-3703
(519) 745-5081
www.mighton.com

MECHANICAL:



COLLINS
ENGINEERING GROUP
INCORPORATED
MECHANICAL ENGINEERING

DRAWING LIST

SHEET NO.	DRAWING NAME	REV. NO.	ISSUED FOR	DATE
-----------	--------------	----------	------------	------

ARCHITECTURAL				
A-000	COVER SHEET	6	Final drawings	11/15/24
A-100	OVERALL GROUND FLOOR & FOUNDATION PLAN & ASSEMBLIES	6	Final drawings	11/15/24
A-101	OVERALL ROOF PLAN	6	Final drawings	11/15/24
A-200	POWER & RCP PLAN GROUND FLOOR	6	Final drawings	11/15/24
A-300	EXTERIOR ELEVATION	6	Final drawings	11/15/24
A-400	BUILDING SECTIONS / DETAILS & ASSEMBLIES	6	Final drawings	11/15/24
A-403	WALL SECTION DETAILS	6	Final drawings	11/15/24
A-500	ENLARGED MILLWORK DETAIL	6	Final drawings	11/15/24
A-600	ENLARGED BATHROOM 1	6	Final drawings	11/15/24
A-601	ENLARGED BATHROOM 2	6	Final drawings	11/15/24
A-700	DOOR & WINDOW SCHEDULE	6	Final drawings	11/15/24
A-800	RENDERINGS	6	Final drawings	11/15/24

Table 3.1.1.3.A (IP)
ZONE 2 - Compliance Packages for Space Heating Equipment with AFUE ≥ 92%
Forming Part of Sentence 3.1.1.3.(1)

Component	Thermal Values ^(a)	Compliance Package					
		A1	A2	A3	A4	A5	A6
Ceiling with Attic Space	Min. Nominal R ⁽¹⁾	60	50	60+HH	60	60	50
	Max. U ⁽²⁾	0.017	0.020	0.016	0.017	0.017	0.020
	Min. Effective R ⁽³⁾	59.22	49.23	59.90	59.22	59.22	49.23
Ceiling Without Attic Space	Min. Nominal R ⁽¹⁾	31	31	31	31	31	31
	Max. U ⁽²⁾	0.036	0.036	0.036	0.036	0.036	0.036
	Min. Effective R ⁽³⁾	27.65	27.65	27.65	27.65	27.65	27.65
Exposed Floor	Min. Nominal R ⁽¹⁾	31	35	31	31	31	35
	Max. U ⁽²⁾	0.034	0.031	0.034	0.034	0.034	0.031
	Min. Effective R ⁽³⁾	29.80	32.02	29.80	29.80	29.80	32.02
Walls Above Grade	Min. Nominal R ⁽¹⁾	19 + 5 ci	19 + 10 ci	22 + 5 ci	22 + 7.5 ci	19 + 10 ci	22 + 7.5 ci
	Max. U ⁽²⁾	0.049	0.040	0.047	0.042	0.040	0.042
	Min. Effective R ⁽³⁾	20.32	25.32	21.40	23.90	25.32	23.90
Basement Walls ⁽⁶⁾	Min. Nominal R ⁽¹⁾	20 ci	20 ci	20 ci	20 ci	20 ci	20 ci
	Max. U ⁽²⁾	0.047	0.047	0.047	0.047	0.047	0.047
	Min. Effective R ⁽⁴⁾	21.12	21.12	21.12	21.12	21.12	21.12
Below Grade Slab Entire Surface > 600 mm Below Grade	Min. Nominal R ⁽¹⁾	—	—	5	—	10	7.5
	Max. U ⁽⁴⁾	—	—	0.163	—	0.090	0.116
	Min. Effective R ⁽⁴⁾	—	—	6.13	—	11.13	8.63
Heated Slab or Slab ≤ 600 mm Below Grade	Min. Nominal R ⁽¹⁾	10	10	10	10	10	10
	Max. U ⁽⁴⁾	0.090	0.090	0.090	0.090	0.090	0.090
	Min. Effective R ⁽⁴⁾	11.13	11.13	11.13	11.13	11.13	11.13
Edge of Below Grade Slab ≤ 600 mm Below Grade	Min. Nominal R ⁽¹⁾	10	10	10	10	10	10
Windows and Sliding Glass Doors	Max. U ⁽⁵⁾	0.21	0.28	0.28	0.21	0.25	0.25
	Energy Rating	34	25	25	34	29	29
Skylights	Max. U ⁽⁵⁾	0.49	0.49	0.49	0.49	0.49	0.49
Space Heating Equipment	Min. AFUE	96%	96%	96%	96%	94%	92%
HRV	Min. SRE	81%	70%	65%	65%	65%	75%
Domestic Water Heater ⁽⁷⁾	Min. EF	0.70	0.80	0.80	0.67	0.67	0.70
Column 1	2	3	4	5	6	7	8

ISSUE FOR:

Final drawings

ISSUE DATE:

11/15/24

PROJECT No.:


23011

OFNTSC - Housing Library


3 BEDROOM - ZONE 2

ROOM SCHEDULE

NAME	AREA
HALLWAY	129 SF
CL.	16 SF
DEN	125 SF
CL.	16 SF
BATHROOM	63 SF
LIN.	6 SF
BEDROOM	140 SF
CL.	16 SF
DINING/LIVING ROOM	441 SF
LAUNDRY/MECH.	89 SF
BEDROOM	233 SF
BATHROOM	96 SF
W.I.C.	52 SF
Grand total: 13	1425 SF

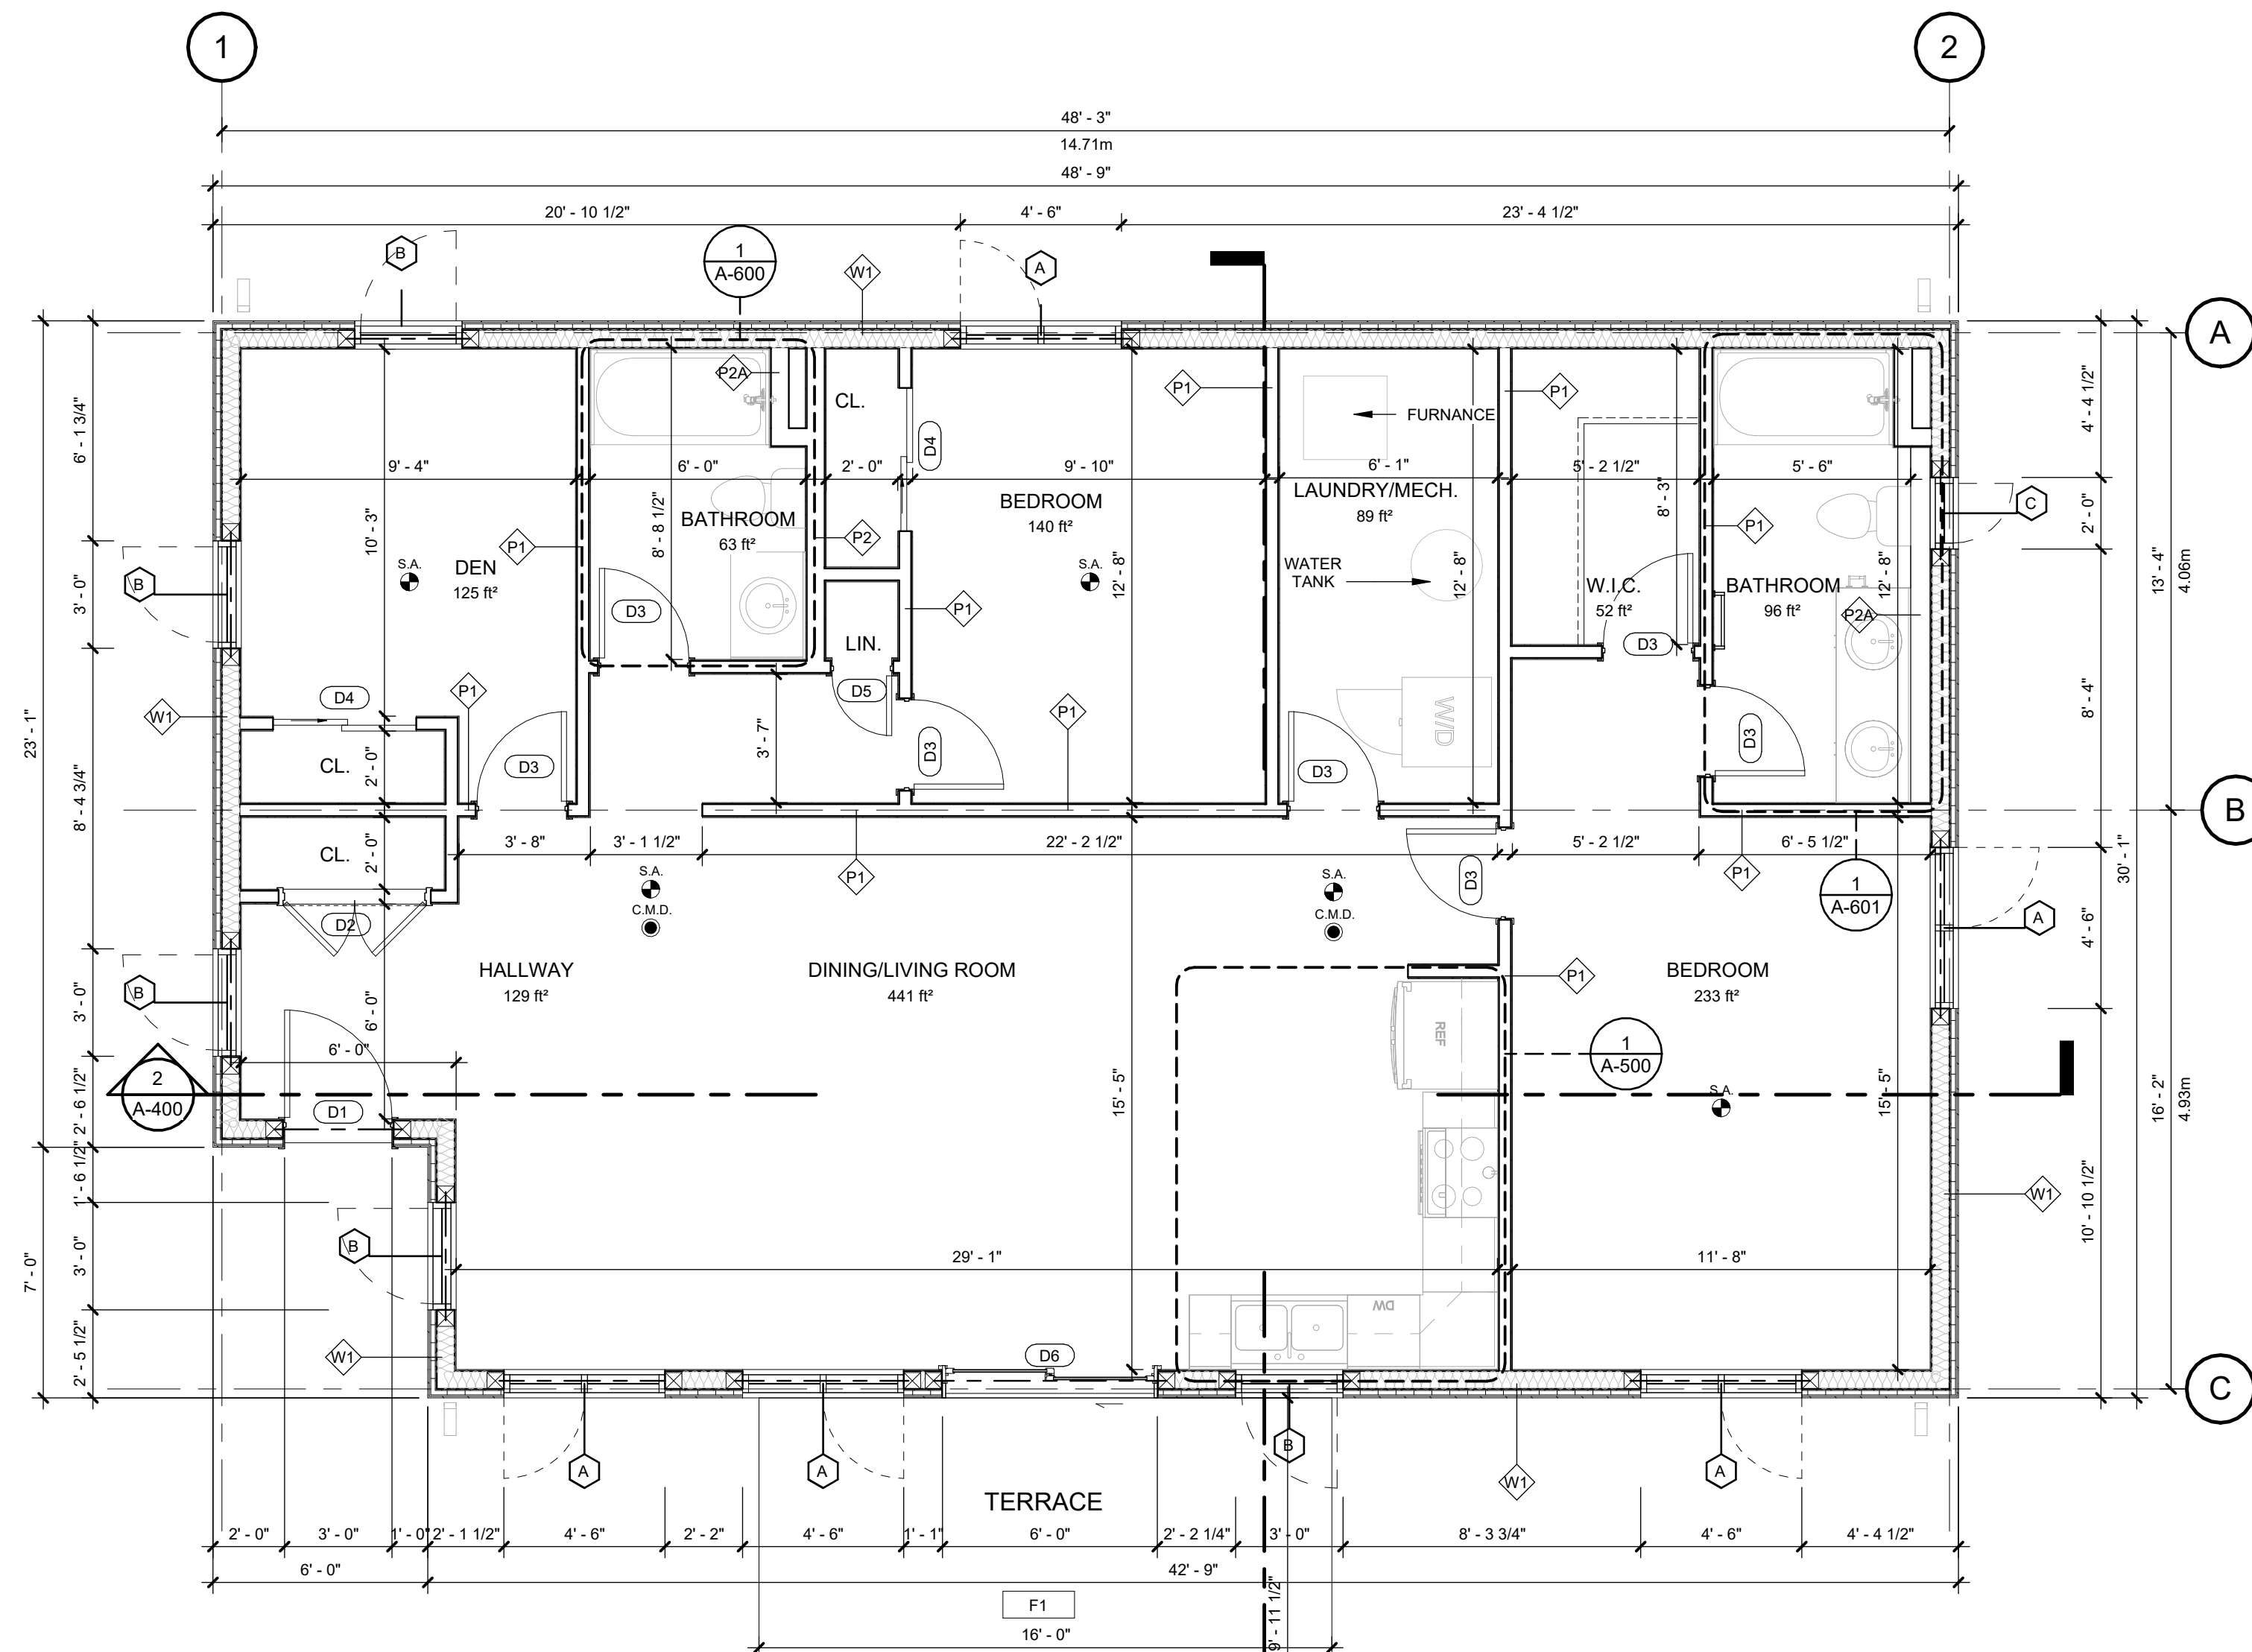

1 GROUND FLOOR
A-100 1/4" = 1'-0"

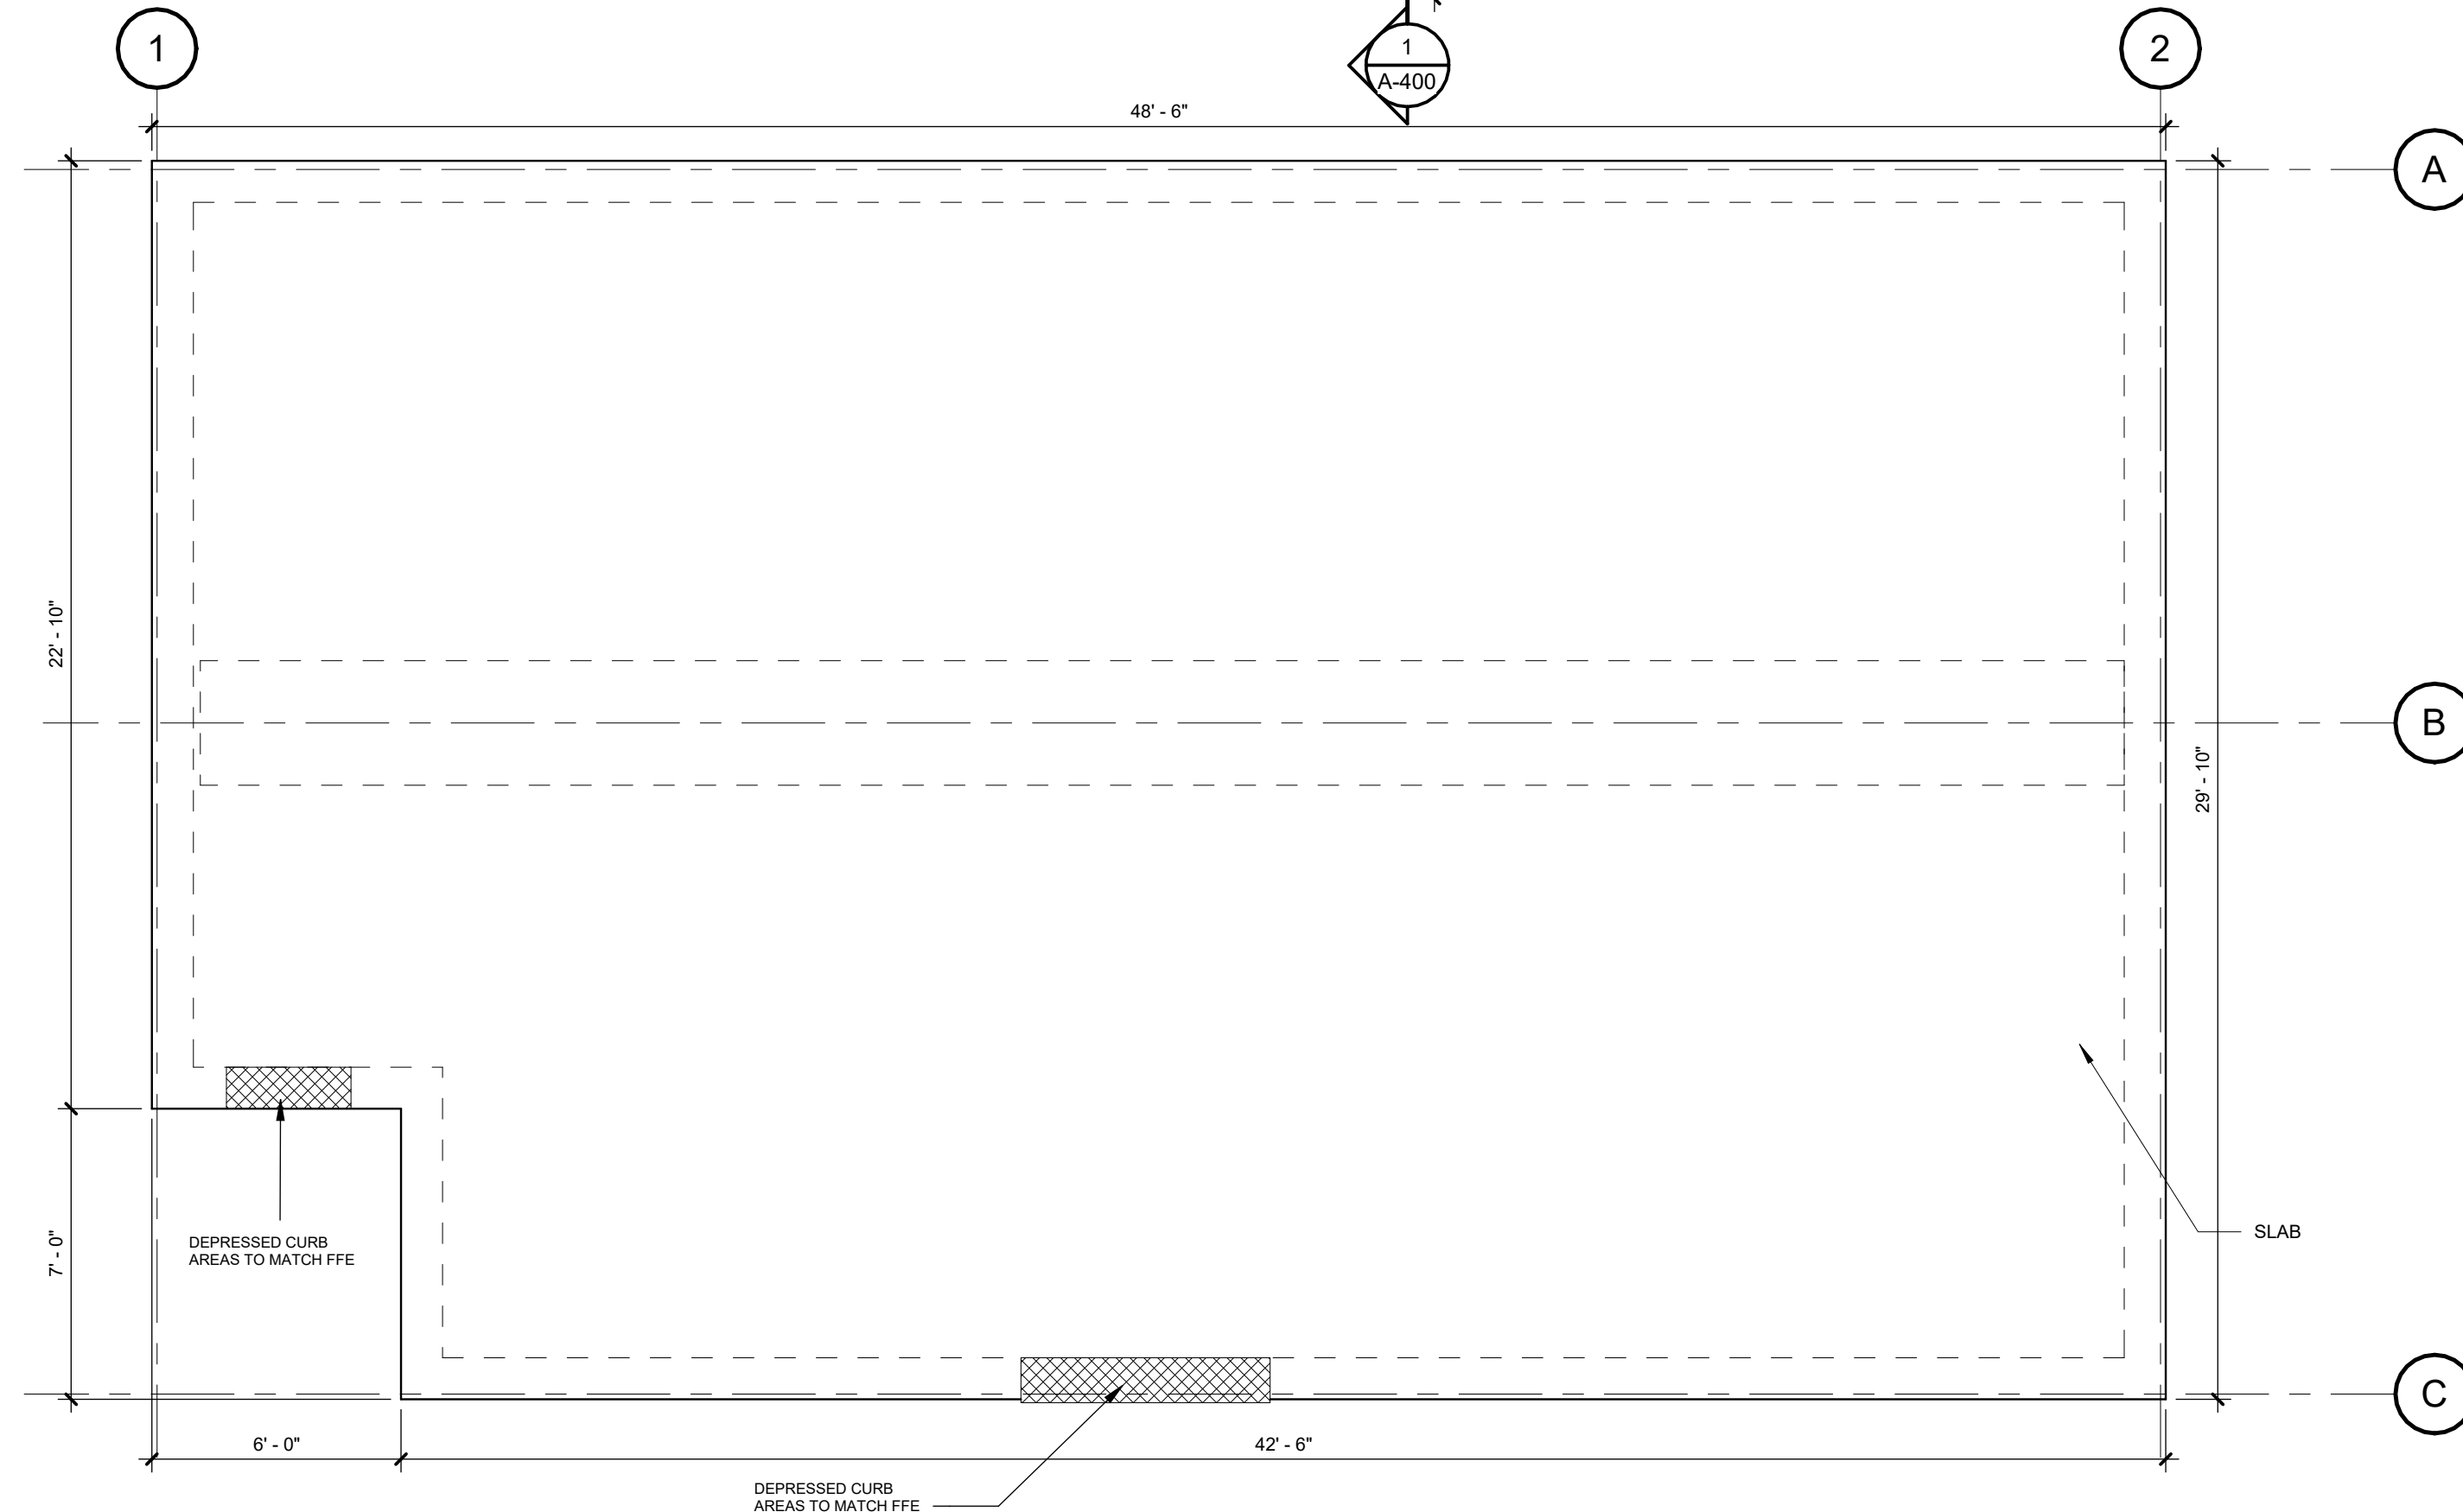

3 FOUNDATION PLAN
A-100 1/4" = 1'-0"

WALL ASSEMBLY TYPES

EXTERIOR WALL ASSEMBLIES:

SECTION VIEW	W1	2" x 6" FRAME WALL W SIDING - EXTERIOR SIDING AS PER MANUF. - 1/2" WOOD STRAPPING FASTENED TO SHEATHING TO SUPPORT APPLICATION OF SIDING WALL FIN. - 1 1/2" (R-7.5d min.) POLYISO INSULATION - TYVEK HOUSE WRAP C/W TAPE JOINTS (TYP.) - 7/16" O.S.B. EXT. TYPE SHEATHING - 2" x 6" S.P.F. #1 WD. STUDS @ 16" O.C. (TYP.) - 6" (R-22 min.) FIBERGLASS BATT INSULATION WITHIN STUD CAVITY - 0.15mm POLYETH. VAPOUR BARRIER - 1/2" GYPSUM WALLBOARD - TAPED, SANDED, C/W PAINTED FIN. (TYP.) R-value: 22+7.5d
--------------	----	--

INTERIOR PARTITION ASSEMBLIES:

SECTION VIEW	P1	TYPICAL 2" x 4" WOOD FRAME INTERIOR PARTITION - 1/2" GYPSUM WALLBOARD - TAPED, SANDED, C/W PAINTED FIN. (TYP.) - 2" x 4" S.P.F. #1 WD. STUDS @ 16" O.C. (TYP.) - 1/2" GYPSUM WALLBOARD - TAPED, SANDED, C/W PAINTED FIN. (TYP.)
SECTION VIEW	P2	TYPICAL 2" x 6" WOOD FRAME INTERIOR PARTITION - PLUMBING WALL - 1/2" GYPSUM WALLBOARD - TAPED, SANDED, C/W PAINTED FIN. (TYP.) - 2" x 6" S.P.F. #1 WD. STUDS @ 16" O.C. (TYP.) - 1/2" GYPSUM WALLBOARD - TAPED, SANDED, C/W PAINTED FIN. (TYP.)
SECTION VIEW	P2A	TYPICAL 2" x 6" WOOD FRAME INTERIOR PARTITION - PLUMBING FURRING WALL - 1/2" GYPSUM WALLBOARD - TAPED, SANDED, C/W PAINTED FIN. (TYP.) - 2" x 6" S.P.F. #1 WD. STUDS @ 16" O.C. (TYP.)

FLOOR ASSEMBLY TYPES

SECTION VIEW	F1	TERRACE WOOD DECKING - DECKING - JOISTS - HEADER JOISTS
SECTION VIEW	F2	SLAB ON GRADE - 8" REINFORCED CONCRETE SLAB + FIN. FLOORING - 3/4" HARDWOOD FLOORING - 1/2" PLYWOOD SUBFLOOR - 8" POURED CONC. SLAB - 0.15mm POLYETH. VAPOUR BARRIER - 6" (R-31 min.) RIGID INSUL. BELOW EXPOSED FLOOR AS PER SB-12 TABLE R-value: 31

ROOF ASSEMBLY TYPES

SECTION VIEW	R1	10" WOOD FRAMED ROOF - 3/4" ASPHALT SHINGLES - 3/4" PLYWOOD SHEATHING - 2" x 10" WD. ROOF JOISTS S.P.F. #1 @ 16" O.C. - 10" (R-31 min.) FIBERGLASS BATT INSULATION WITHIN STUD CAVITY (OR 6" SPRAY INSULATION) - 0.15mm POLYETH. VAPOUR BARRIER - 1/2" GYPSUM WALL BOARD R-value: 31
SECTION VIEW	R2	4" WOOD FRAMED ROOF - 3/4" ASPHALT SHINGLES - 3/4" PLYWOOD SHEATHING - 2" x 6" WD. ROOF JOISTS S.P.F. #1 @ 16" O.C. - 1/2" METAL PANELS

SHOP DRAWING NOTE:

- OWNER / CONTRACTOR TO ENSURE SHOP DRAWING SUBMITTALS ARE PREPARED BY SYSTEMS DESIGNER (WALL, FLOOR, STAIR, WINDOW, DOOR ETC.)

- CONTRACTOR TO REVIEW AND APPROVE THE ABOVE MENTIONED SHOP DRAWINGS PRIOR TO SUBMISSION TO THE ARCHITECT. PLANS / DRAWINGS SHOWN ARE FOR REFERENCE AND DESIGN INTENT ONLY AND ARE NOT INTENDED FOR FABRICATION - TYP.

FIXTURE BLOCKING NOTE:

- WOOD STUD FRAMING SUB-TRADE TO PROVIDE & INSTALL ALL REQ. WALL BRACING / BLOCKING FOR THE INSTALLATION OF ALL SHOWERS, TUBS, GRAB BARS, SINKS ETC.

KITCHEN MILLWORK / ELECTRICAL NOTE:

- ELECTRICAL SUB-TRADE TO PROVIDE RECEPTACLE LOCATED ABOVE KITCHEN FRIDGE CABINET FOR THE FUTURE INSTALLATION OF DATA SERVICES .

- ELECTRICAL SUB-TRADE TO RUN / SUPPLY CONDUITE SLEEVES (REF. ELEC. DWGS.) ABOVE KITCHEN FRIDGE CABINETS.


PLUMBING / HVAC GENERAL NOTES:

- PLUMBING TRADE TO INSTALL / RUN ALL VERTICAL & HORIZONTAL RISERS, LINES & SERVICES TIGHT TO FACE OF ALL WALLS, STRUCTURE & CEILINGS; TO ALLOW FOR THE HVAC DUCTWORK INSTALLED WITH NO INTERFERENCES - TYP. TRADES TO COORDINATE w/ DIVISION 16 ON SITE - TYP.
- GROUND FAULT INTERRUPTER (GFI) OUTLETS IN ALL BATHROOMS.

6	NP/ MH	Final drawings	11/15/24
5	NP/ MH	For Client Review	08/16/24
4	NP/ MH	For coordination	07/03/24
3	NP/ MH	For Client Review	06/10/24
2	NP/ MH	Review	03/09/24
1	NP/ MH	Review	02/07/24

Iss.	By	Description	Date
YY-MM-DD			
Issuance Schedule			

Revisions :
All previous issues of this drawing are superseded.

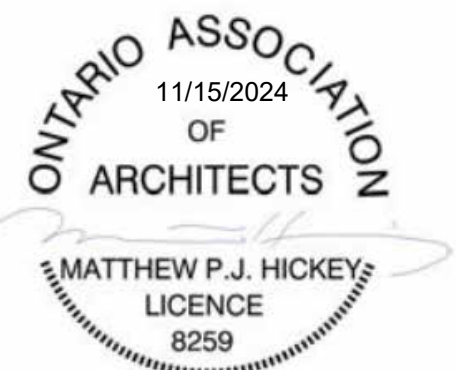

THESE DRAWINGS ARE NOT FOR CONSTRUCTION
NO CONSTRUCTION TO BEGIN UNTIL APPROVAL HAS BEEN GIVEN BY ALL AUTHORITIES HAVING JURISDICTION. A BUILDING PERMIT IS ISSUED AND REVIEWED BY THE ARCHITECT TO CONFIRM COMMENTS MADE BY THE AHJ IN WRITING.

DRAWINGS NOT FOR CONSTRUCTION
Drawings are not for construction until approved permit from the authorities having jurisdiction has been received by the architect and approved in writing.

DRAWINGS ARE NOT TO BE SCALED

Contractor must verify all dimensions on the drawings and report any discrepancies to the architect before proceeding with the work.

All drawings and specifications are instruments of service and the property of the architect, and must be returned at the completion of the work.



OFNTSC - Housing Library

3 BEDROOM - ZONE 2

 
OVERALL GROUND FLOOR & FOUNDATION PLAN & ASSEMBLIES

scale: As indicated
drawn by: NP
reviewed by: MH
job number: 23011
plot date: 11/15/2024

drawing number:


A-100

2024-11-18 2:41:55 PM



Iss.	By	Description	Date YY-MM-DD
------	----	-------------	------------------


Revisions :
All previous issues of this drawing are superseded

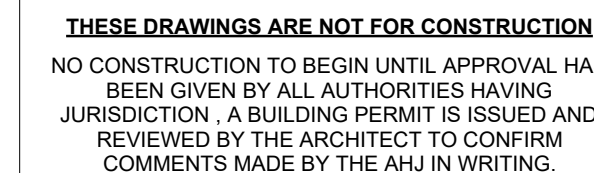


Drawings are not for construction until approved permit from the authorities having jurisdiction has been received by the architect and approved in writing.

Contractor must verify all dimensions on the drawings and report any discrepancies to the architect before proceeding with the work.

All drawings and specifications are instruments of service and the property of the architect, and must be returned at the completion of the work.

 

2024-11-18 2:41:56 PM

 

1. ALL ROOF TOP EQUIPMENT, PLUMBING, VENTS, CONDENSING UNITS, EXHAUST FANS, BOILER FLUES, ETC. ARE TO BE CONCEALED FROM VIEW BEHIND PARAPET WALLS
2. LOCATION OF ALL ROOF DRAINS ARE TO BE LOCATED 45 DEGREES FROM ALL BEAM/COLUMN LOCATIONS TO AVOID INTERFERENCES WITH STRUCTURAL (REF. DETAIL ABOVE)
3. LOCATIONS OF ALL ROOF TOP EQUIPMENT, PLUMBING, VENTS, CONDENSING UNITS, EXHAUST FANS, BOILER FLUES, ETC. ARE APPROXIMATE (REFERENCE MECHANICAL DRAWINGS FOR EXACT LOCATIONS)
4. ENSURE ALL ROOF TOP PENETRATIONS ARE AIR AND WATER SEALED AS PER NRCA REQUIREMENTS (TYP.)
5. FALL ARREST SAFETY ANCHORS ARE DESIGNED TO A TYPICAL MAXIMUM FALL ARRESTING FORCE OF 1,800 LBS (8.0KN) WHEN WEARING A BODY HARNESS, WITH A FACTOR OF SAFETY OF 2 WITHIN ANY PENETRATIONS TO BE WITHSTAND TO 5,000 LBS. (22.2 KN) AGAINST FRACTURE OR DETACHMENT.
6. IT IS THE RESPONSIBILITY IF THE STRUCTURAL ENGINEER FOR THE OVERALL PROJECT TO ENSURE THE STRUCTURE ON WHICH THE SAFETY EQUIPMENT BY APPROVED MANUFACTURER IS INSTALLED, IS NOT OVERLOADED TO WITHSTAND THE LOADS INDICATED IN THIS DRAWING.

ROOF ANCHOR SUPPLIER TO PROVIDE B.C.I.N. NUMBER STAMPED SHOP
DRAWINGS CONFORMING TO ALL JURISDICTIONAL
AND CODE REQUIREMENTS

LOCATION OF ANCHORING NOT SHOWN ON PLAN REFER TO
MANUFACTURE FOR AMOUNT, LOCATION AND SIZE. CONTRACTOR TO
PROVIDE SHOP DRAWING CONFIRMATION

CEILING LEGEND**C-1 - CEILING - GWB**

- ARMSTRONG SUSPENDED DRYWALL CEILING HANGERS
OR APPROVED ALTERNATE, FILL VOIDS BETWEEN
DRYWALL CRACKS WITH 2LB SPRAY FOAM TYP.

- 1/2" GWB CEILING

	SWITCH
	SMALL LIGHT
	BIG LIGHT
	WALL LIGHT
	LIGHT, FAN, EXHAUST - COMBO
	WALL SOCKET

GENERAL NOTES:

- SMOKE / CO2 ALARMS ARE TO BE HARDWIRED
- FURNACE TO BE ELECTRIC
- SMOKE DETECTORS ARE TO BE CENTERED ON BETWEEN LIGHTS (TYP.)

6	NP/	Final drawings	11/15/24
5	NP/	For Client Review	08/16/24
4	NH/	For coordination	07/03/24
3	NP/	For Client Review	06/10/24
2	NP/	Review	03/09/24
1	NP/	Review	02/07/24

Iss.	By	Description	Date YY-MM-DD
Issuance Schedule			

Revisions :

All previous issues of this drawing are superseded.

**THESE DRAWINGS ARE NOT FOR CONSTRUCTION**

NO CONSTRUCTION TO BEGIN UNTIL APPROVAL HAS
BEEN GIVEN BY ALL AUTHORITIES HAVING
JURISDICTION. A BUILDING PERMIT IS ISSUED AND
REVIEWED BY THE ARCHITECT TO CONFIRM
COMMENTS MADE BY THE AHJ IN WRITING.

DRAWINGS NOT FOR CONSTRUCTION

Drawings are not for construction until approved permit from the
authorities having jurisdiction has been received by the architect
and approved in writing.

DRAWINGS ARE NOT TO BE SCALED

Contractor must verify all dimensions on the drawings and
report any discrepancies to the architect before proceeding
with the work.

All drawings and specifications are instruments of service
and the property of the architect, and must be returned at the
completion of the work.

**OFNTSC - Housing Library**

3 BEDROOM - ZONE 2


**POWER & RCP PLAN
GROUND FLOOR**

scale: 1/4" = 1'-0"
drawn by: NP
reviewed by: MH
job number: 23011
plot date: 11/15/2024


drawing number:

A-200

2024-11-18 2:41:56 PM

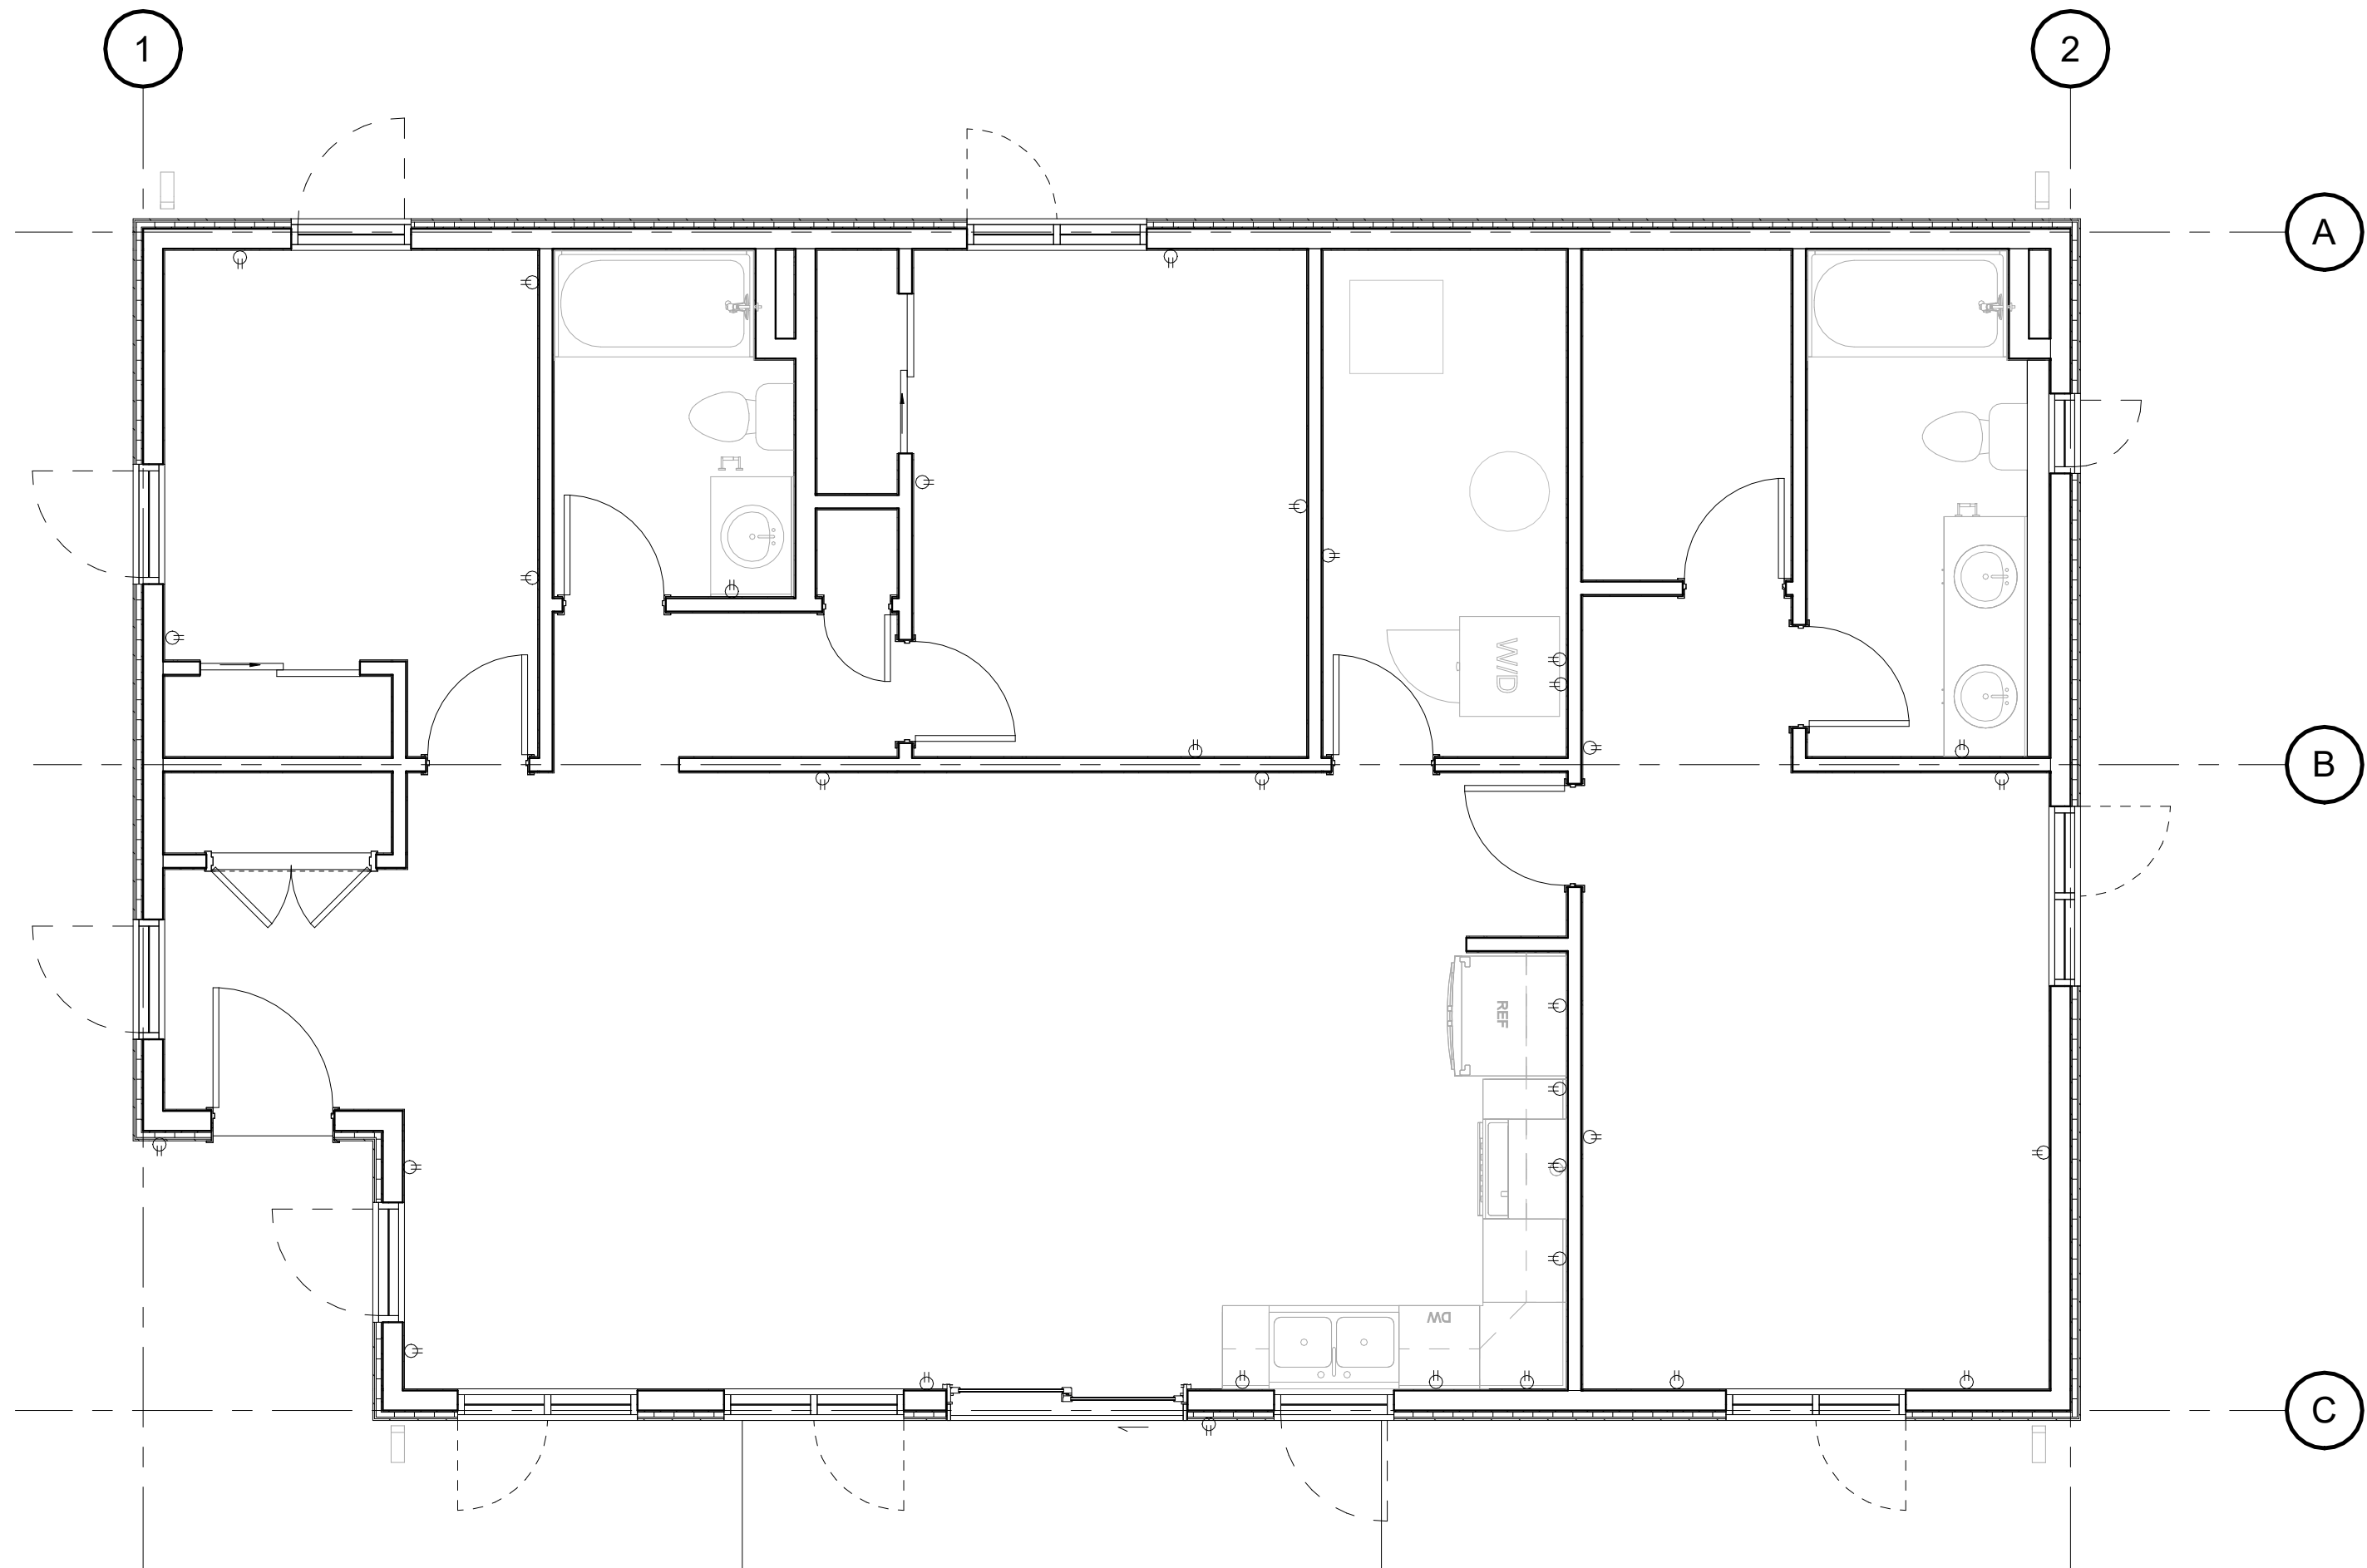


1 GROUND FLOOR - power plan
A-200 1/4" = 1'-0"

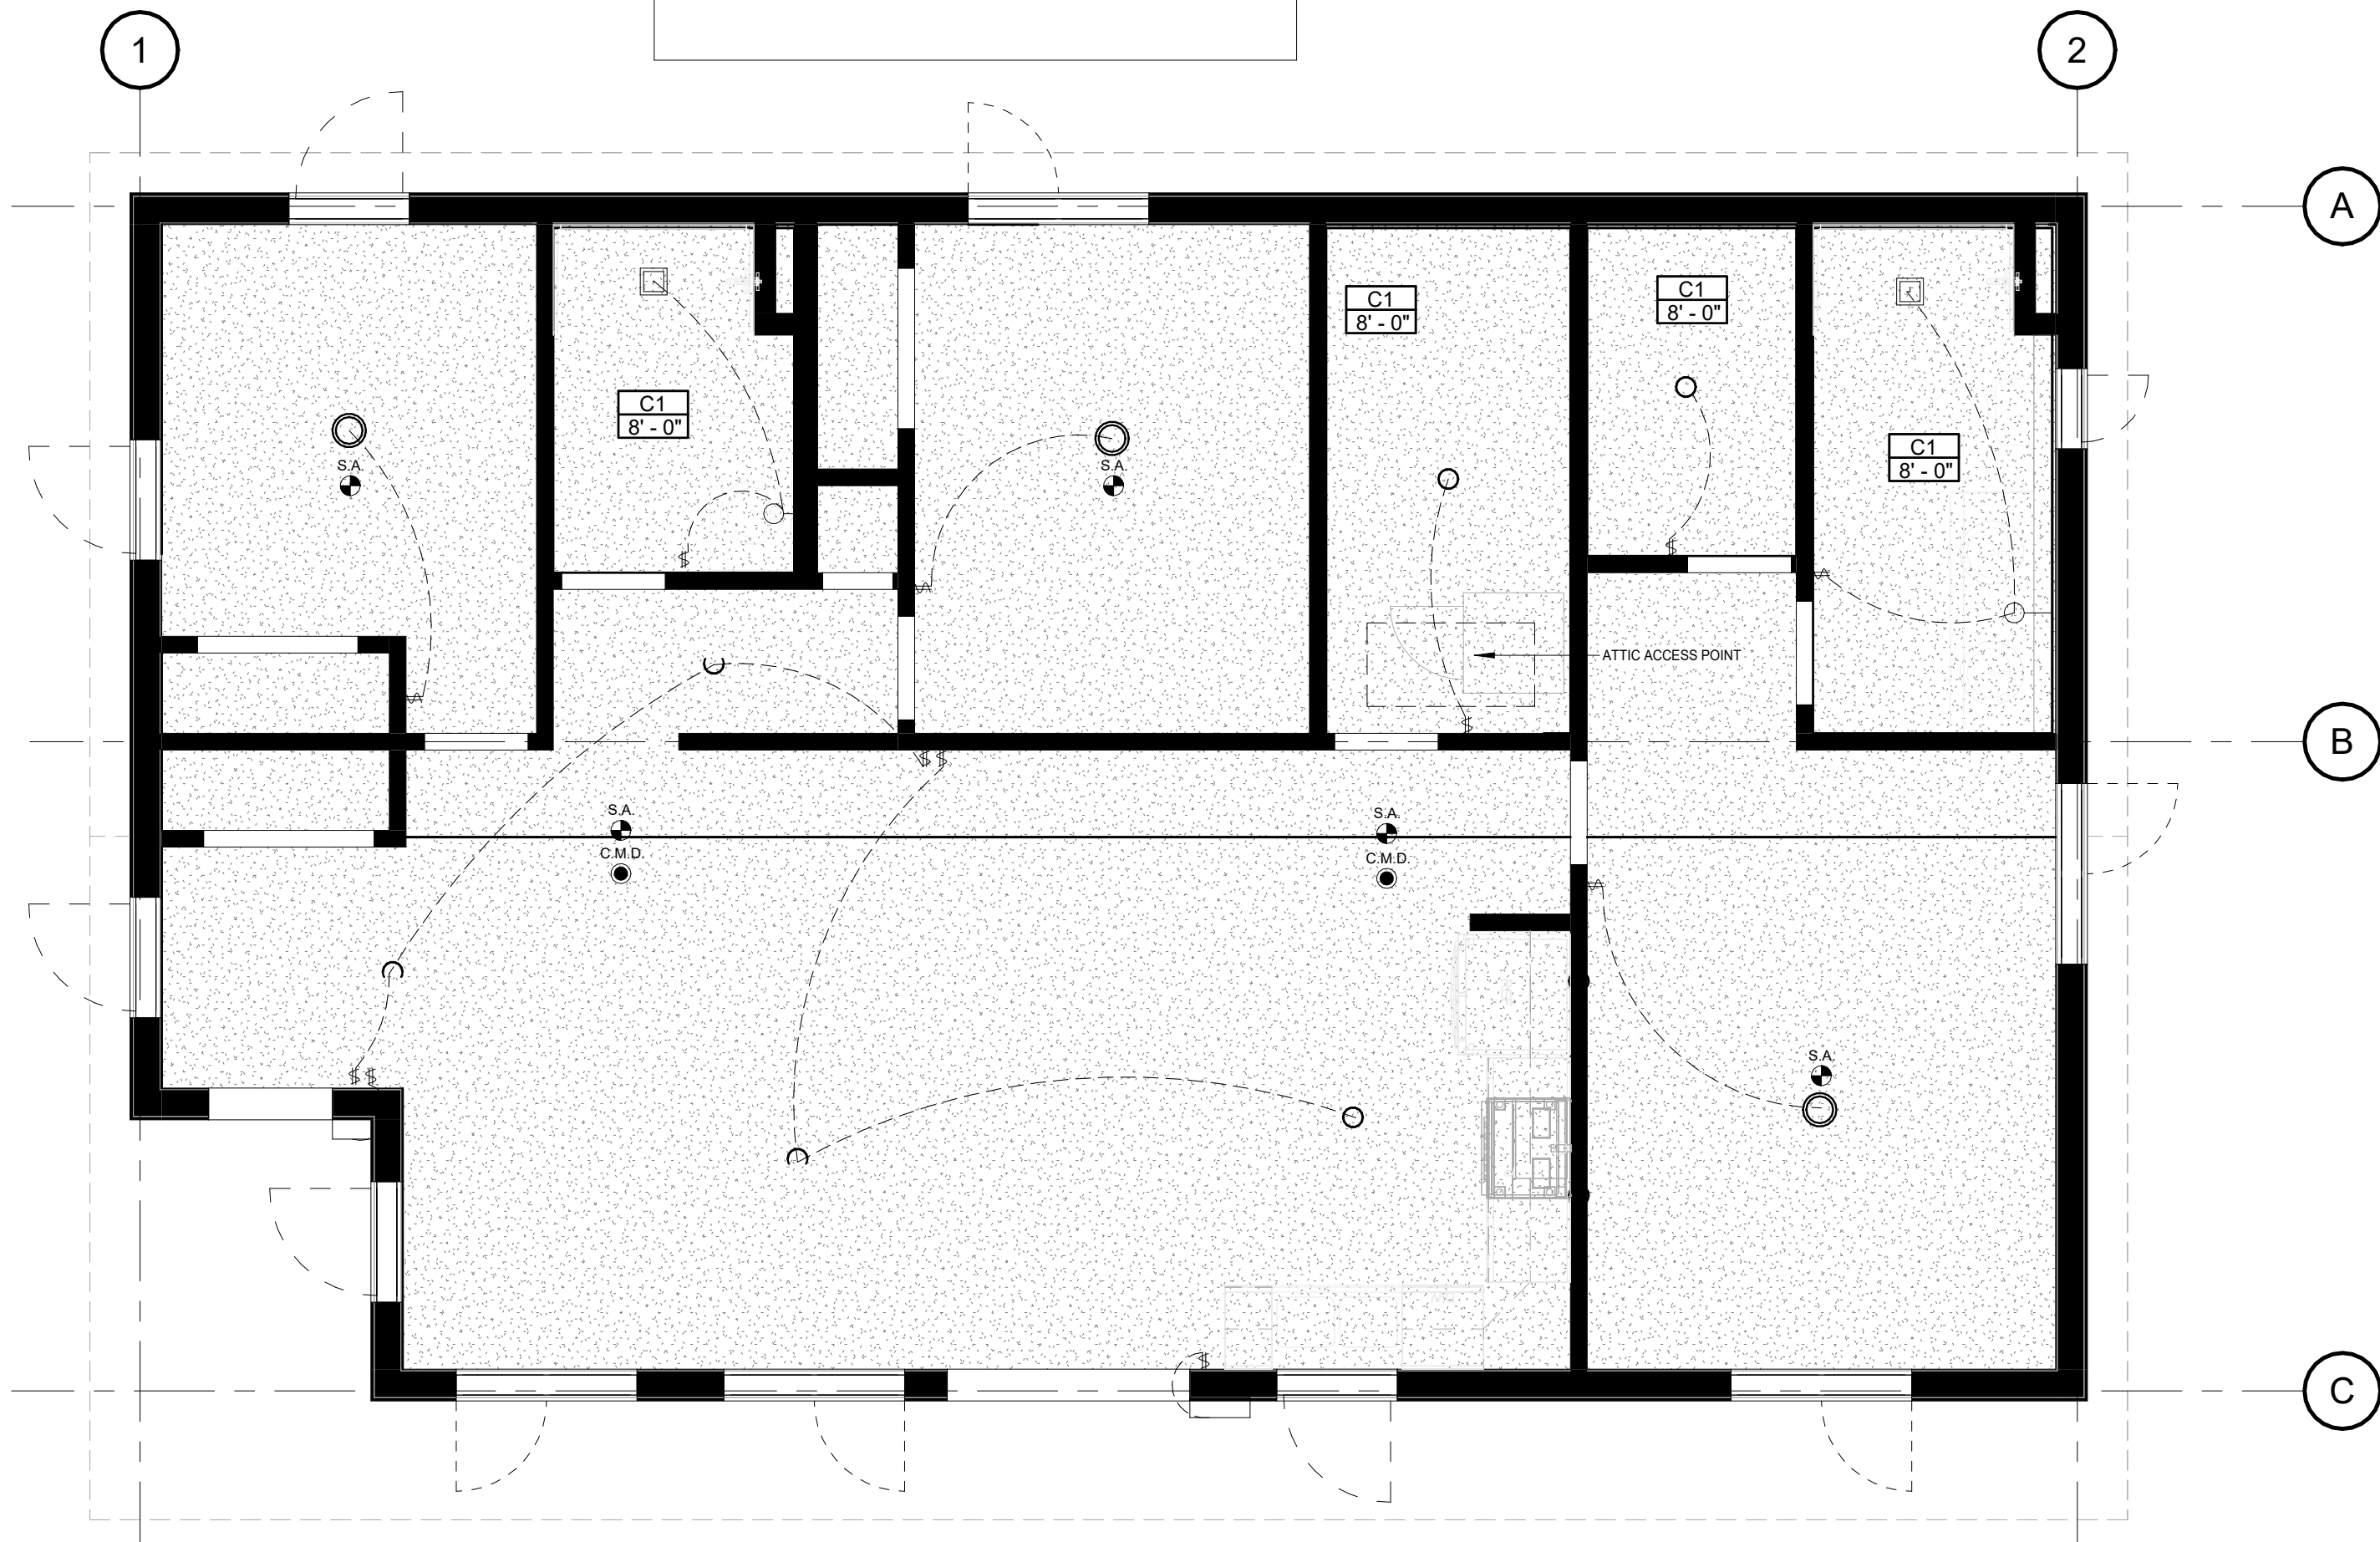

2 RCP PLAN
A-200 1/4" = 1'-0"


REFER TO ELECTRICAL DRAWINGS

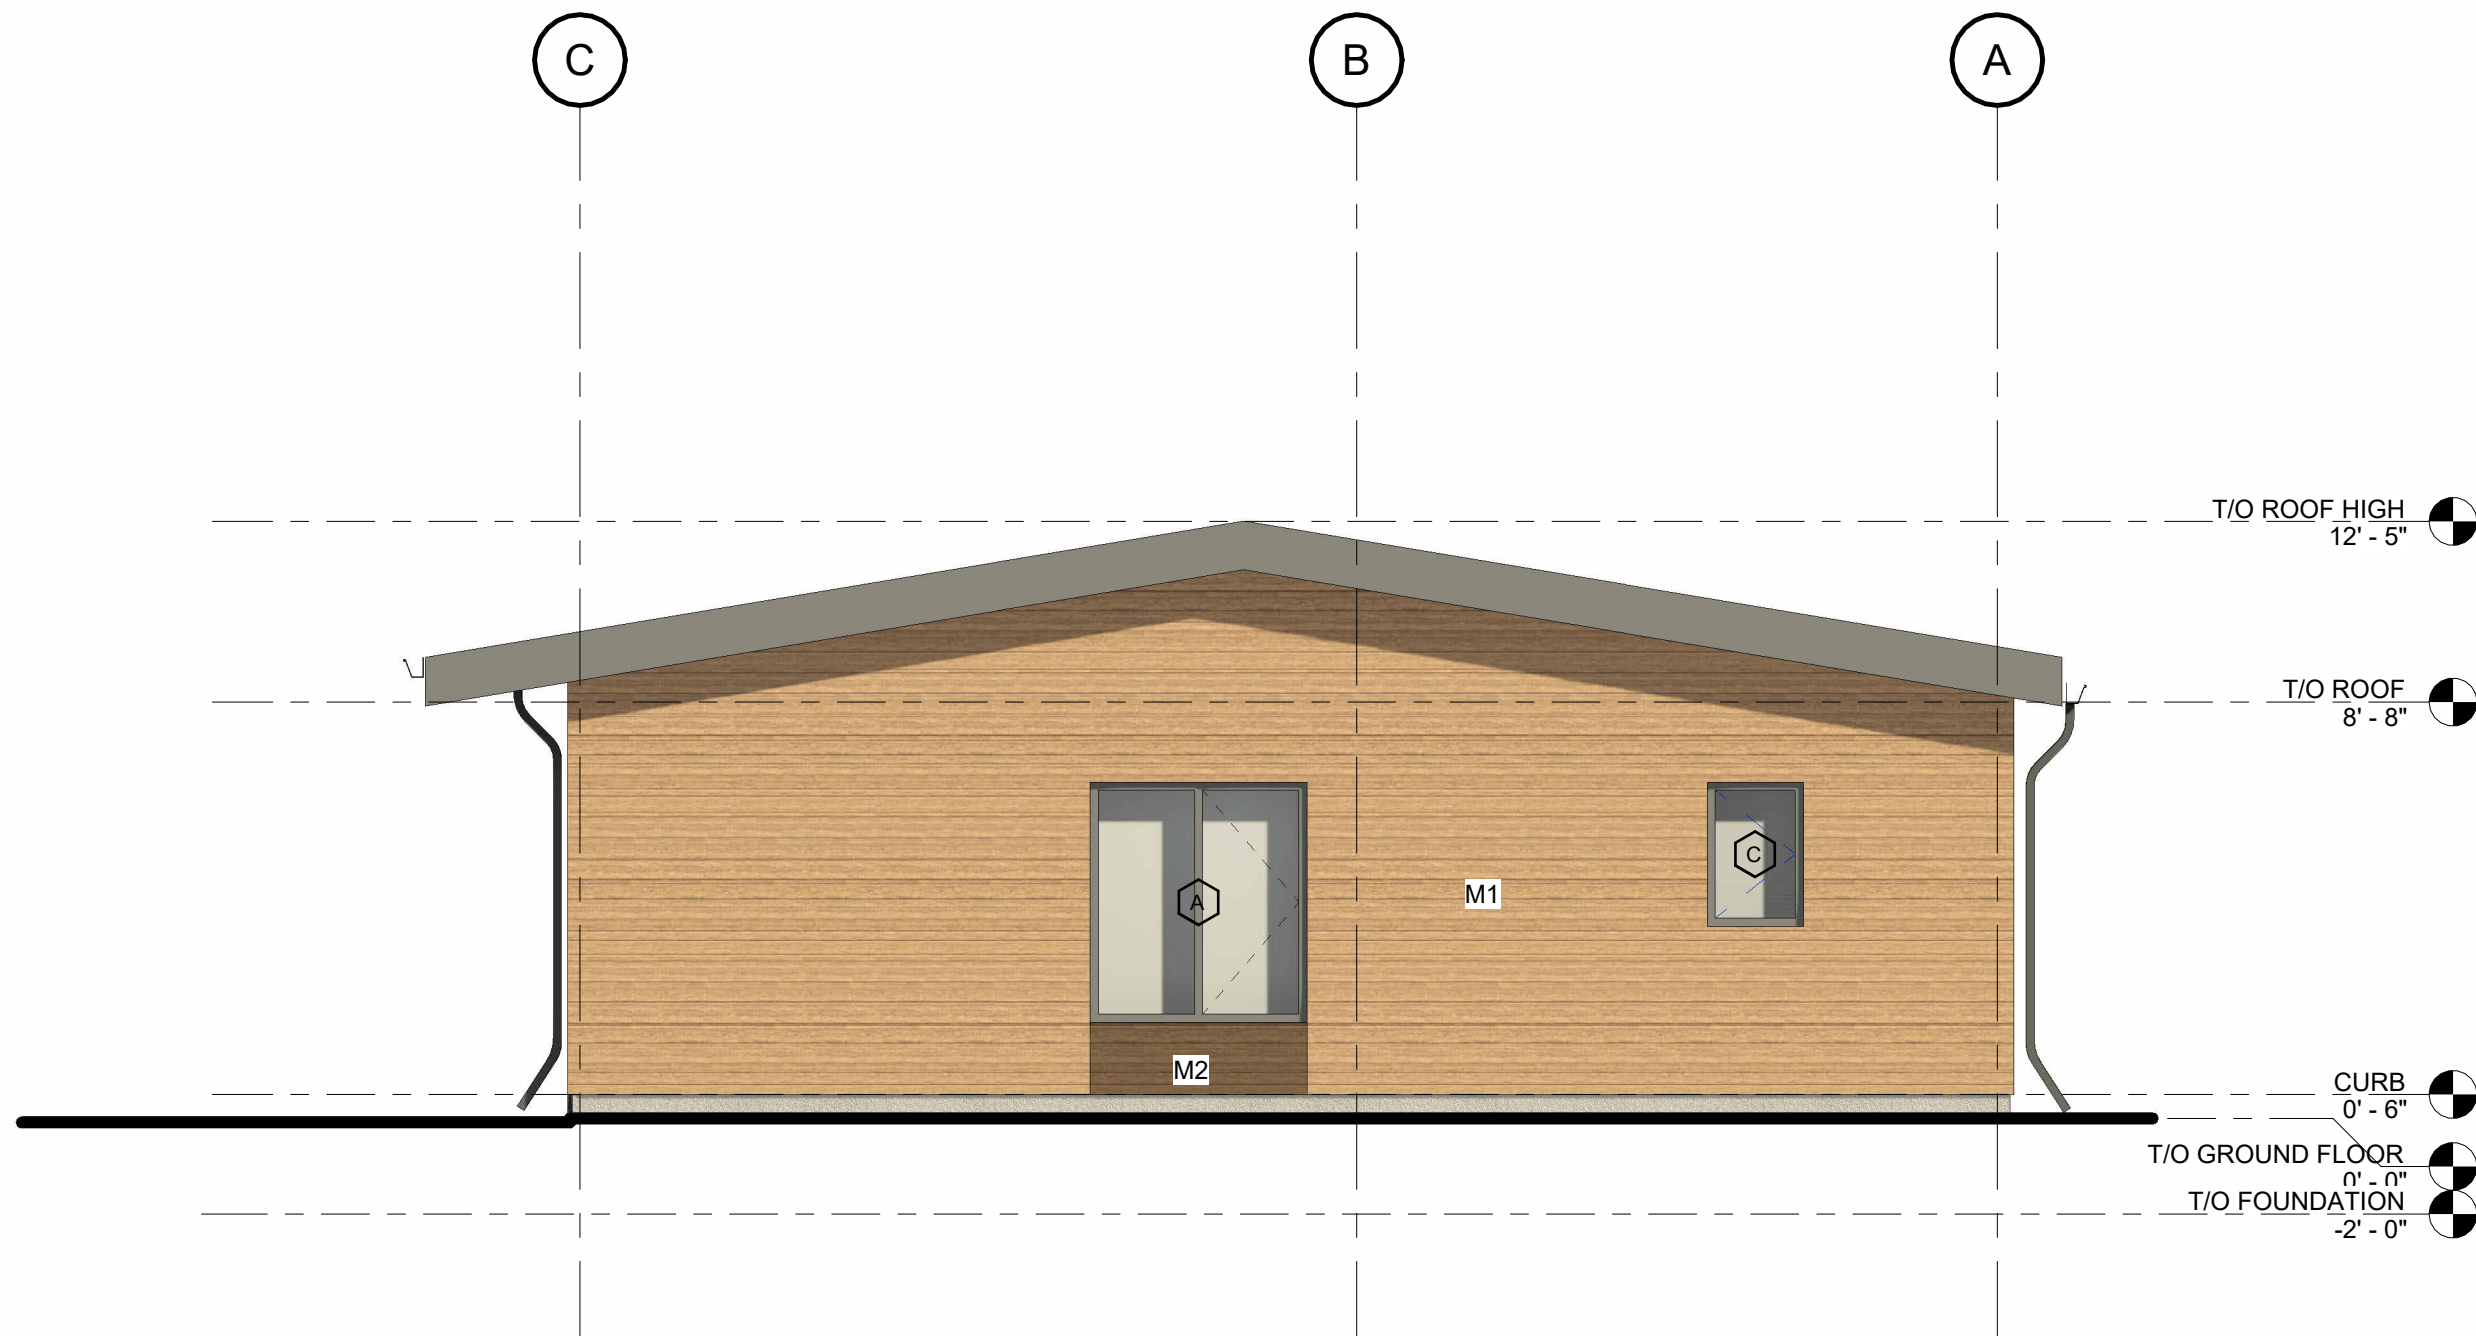

1 EAST ELEVATION
A-300 1/4" = 1'-0"



3 SOUTH ELEVATION
A-300 1/4" = 1'-0"

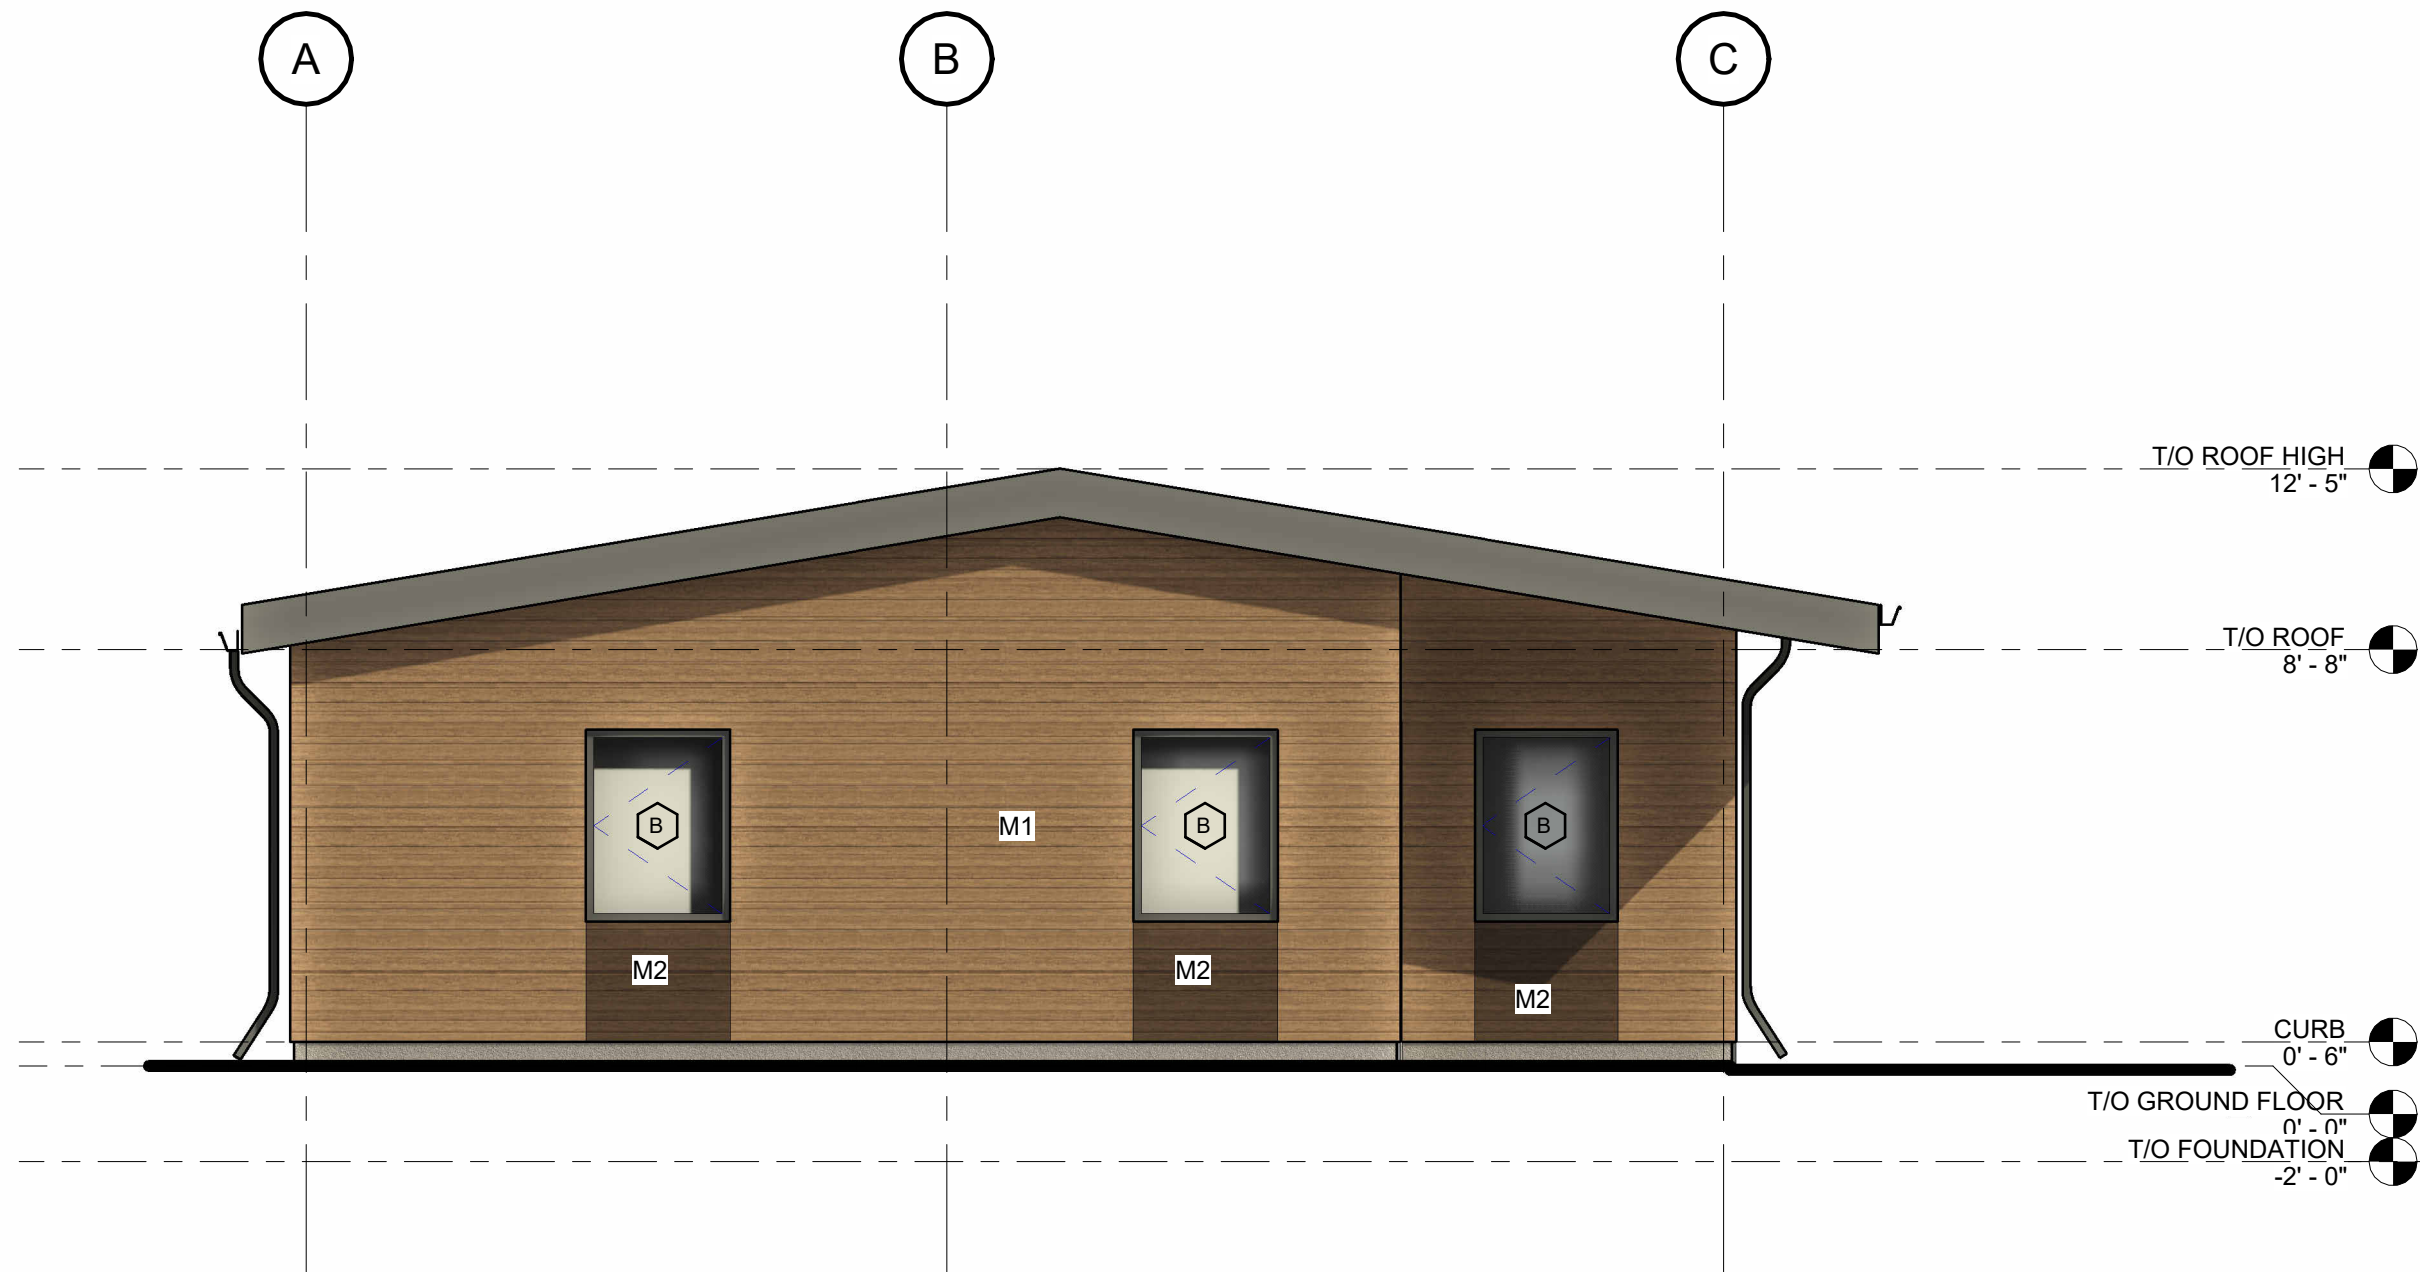

4 WEST ELEVATION
A-300 1/4" = 1'-0"



2 NORTH ELEVATION
A-300 1/4" = 1'-0"

EXTERIOR COLOUR LEGEND



M1 - WOOD/VINYL SIDING



M2 - WOOD/VINYL SIDING



M2 - ROOF ASPHALT SHINGELS/METAL ROOF

SHOP DRAWING NOTE:

OWNER/CONTRACTOR TO ENSURE SHOP DRAWING SUBMITTALS ARE PREPARED BY THE PRECAST SYSTEMS DESIGNER & SENT TO THE LIC. TECH. OAA TO ENSURE COLOUR SELECTIONS ARE APPROVED.



P.O. Box 77 - 1804 6th Line • Chiefswood Rd. Chatham, ON, N0A 1M0
519.445.2137 www.tworow.com info@tworow.com

6	NP/ MH	Final drawings	11/15/24
5	NP/ MH	For Client Review	08/16/24
4	NP/ MH	For coordination	07/03/24
3	NP/ MH	For Client Review	06/10/24
2	NP/ MH	Review	03/09/24
1	NP/ MH	Review	02/07/24

Iss.	By	Description	Date YY-MM-DD
Issuance Schedule			

Revisions :
All previous issues of this drawing are superseded.



THESE DRAWINGS ARE NOT FOR CONSTRUCTION
NO CONSTRUCTION TO BEGIN UNTIL APPROVAL HAS BEEN GIVEN BY ALL AUTHORITIES HAVING JURISDICTION. A BUILDING PERMIT IS ISSUED AND REVIEWED BY THE ARCHITECT TO CONFIRM COMMENTS MADE BY THE AHJ IN WRITING.

DRAWINGS NOT FOR CONSTRUCTION
Drawings are not for construction until approved permit from the authorities having jurisdiction has been received by the architect and approved in writing.

DRAWINGS ARE NOT TO BE SCALED

Contractor must verify all dimensions on the drawings and report any discrepancies to the architect before proceeding with the work.

All drawings and specifications are instruments of service and the property of the architect, and must be returned at the completion of the work.

OFNTSC - Housing Library

3 BEDROOM - ZONE 2


EXTERIOR ELEVATION

scale: As indicated
drawn by: NP
reviewed by: MH
job number: 23011
plot date: 11/15/2024

drawing number:

A-300

2024-11-18 2:42:03 PM

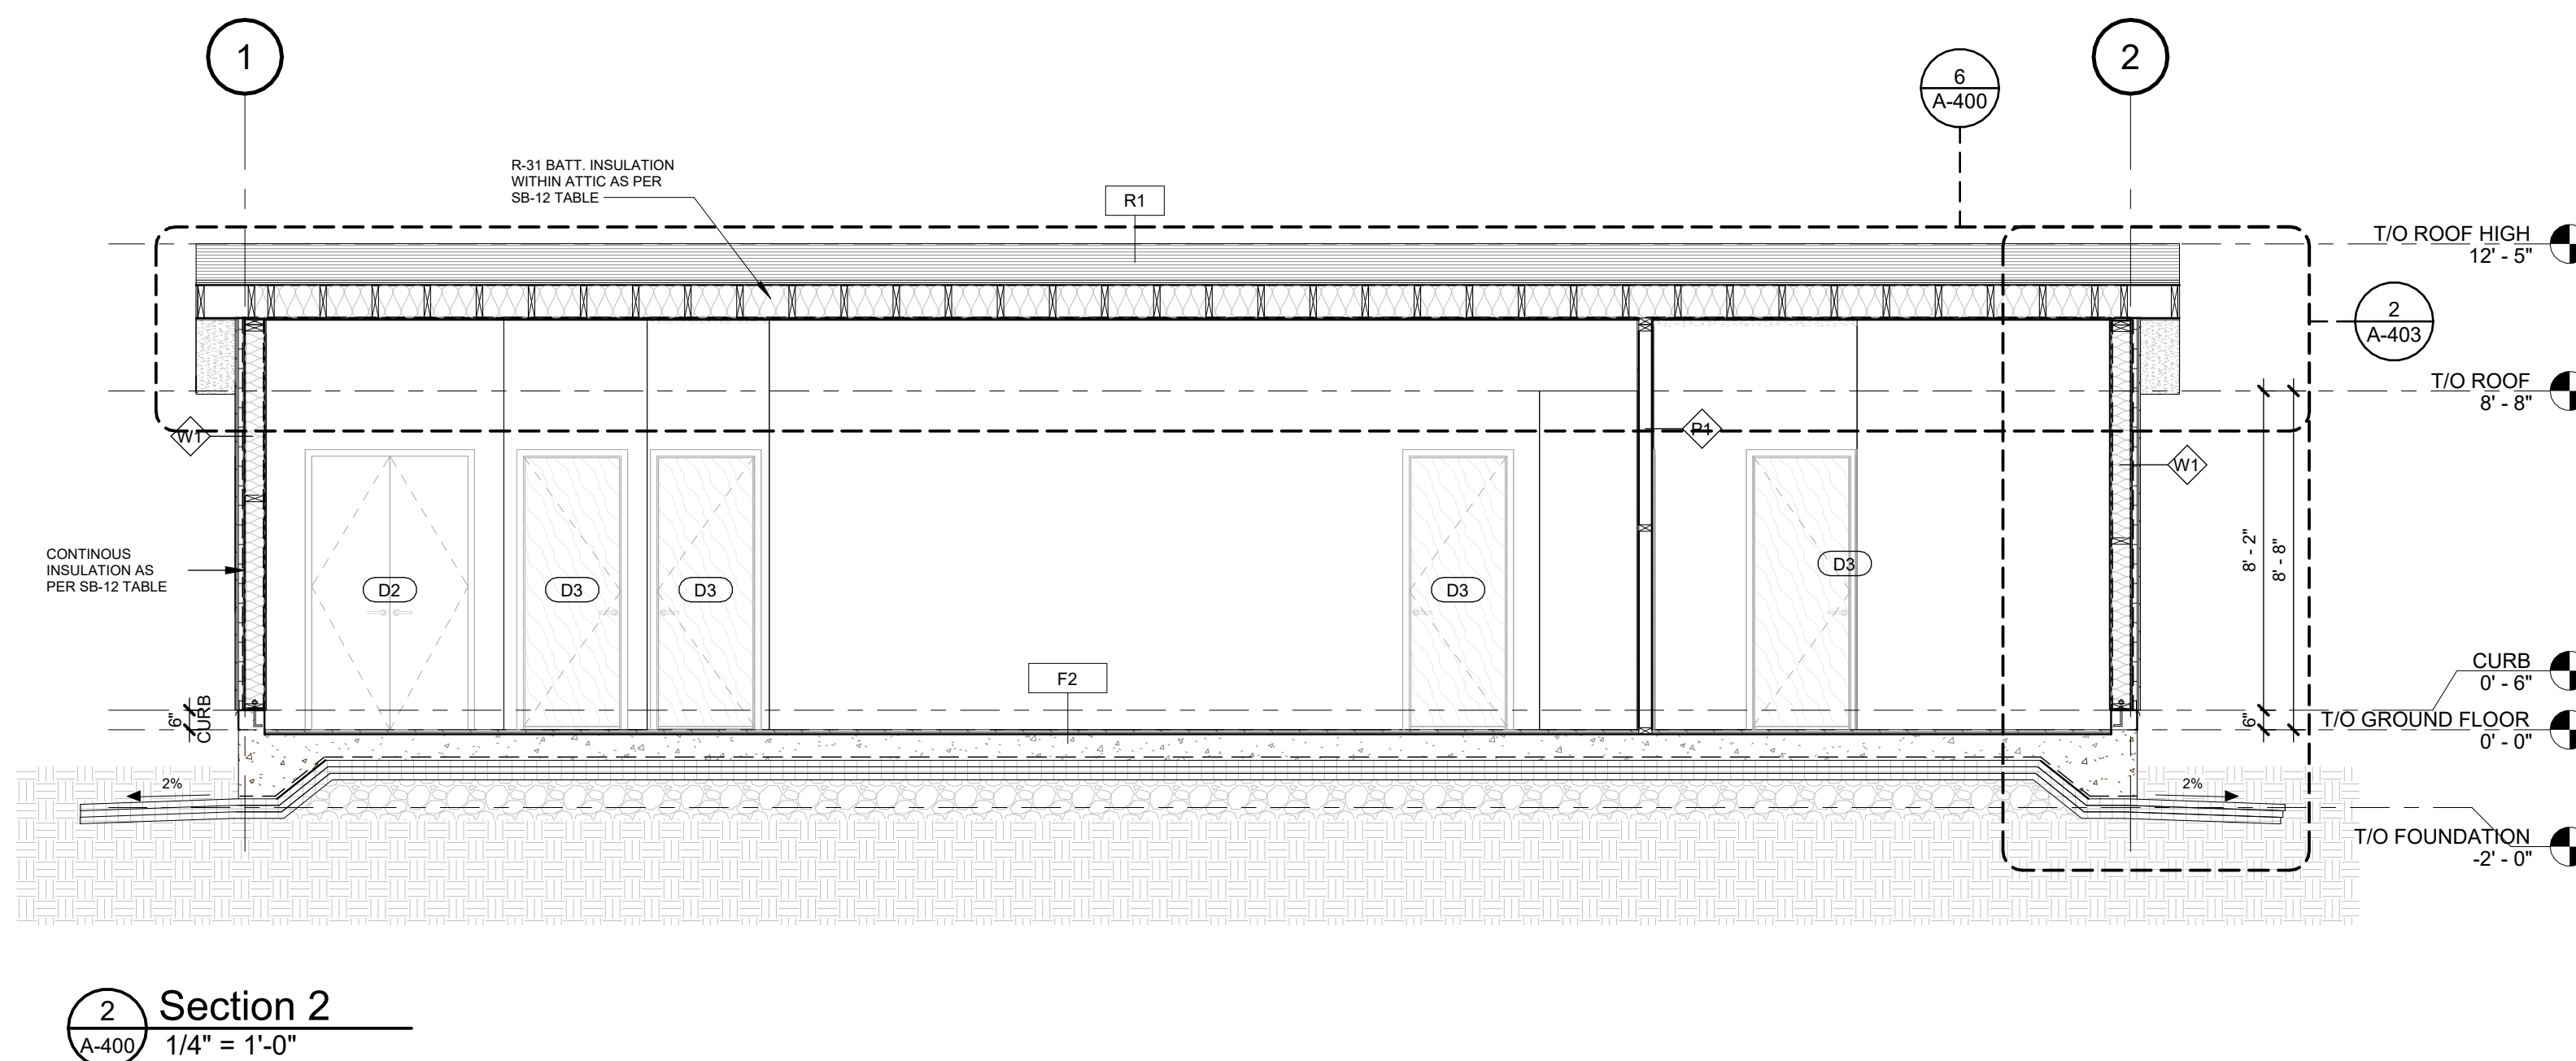

Iss.	By	Description	Date YY-MM-DD
Issuance Schedule			

A circular stamp from the Ontario Association of Architects. The text "ONTARIO ASSOCIATION OF ARCHITECTS" is arranged in a circle around the date "11/15/2024". In the center, it reads "OF ARCHITECTS". Below the circle, the name "MATTHEW P. J. HICKEY" is stamped, followed by "LICENCE" and the number "8259".

DRAWINGS NOT FOR CONSTRUCTION
Drawings are not for construction until approved permit from the authorities having jurisdiction has been received by the architect and approved in writing.

Contractor must verify all dimensions on the drawings and report any discrepancies to the architect before proceeding with the work.

OFNTSC - Housing Library

3 BEDROOM - ZONE 2




BUILDING SECTIONS /
DETAILS & ASSEMBLIES

scale:	As indicated
drawn by:	NP
reviewed by:	MH
job number:	23011
plot date:	11/15/2024

drawing number

A-400

 
2024-11-18 2:42:04 PM

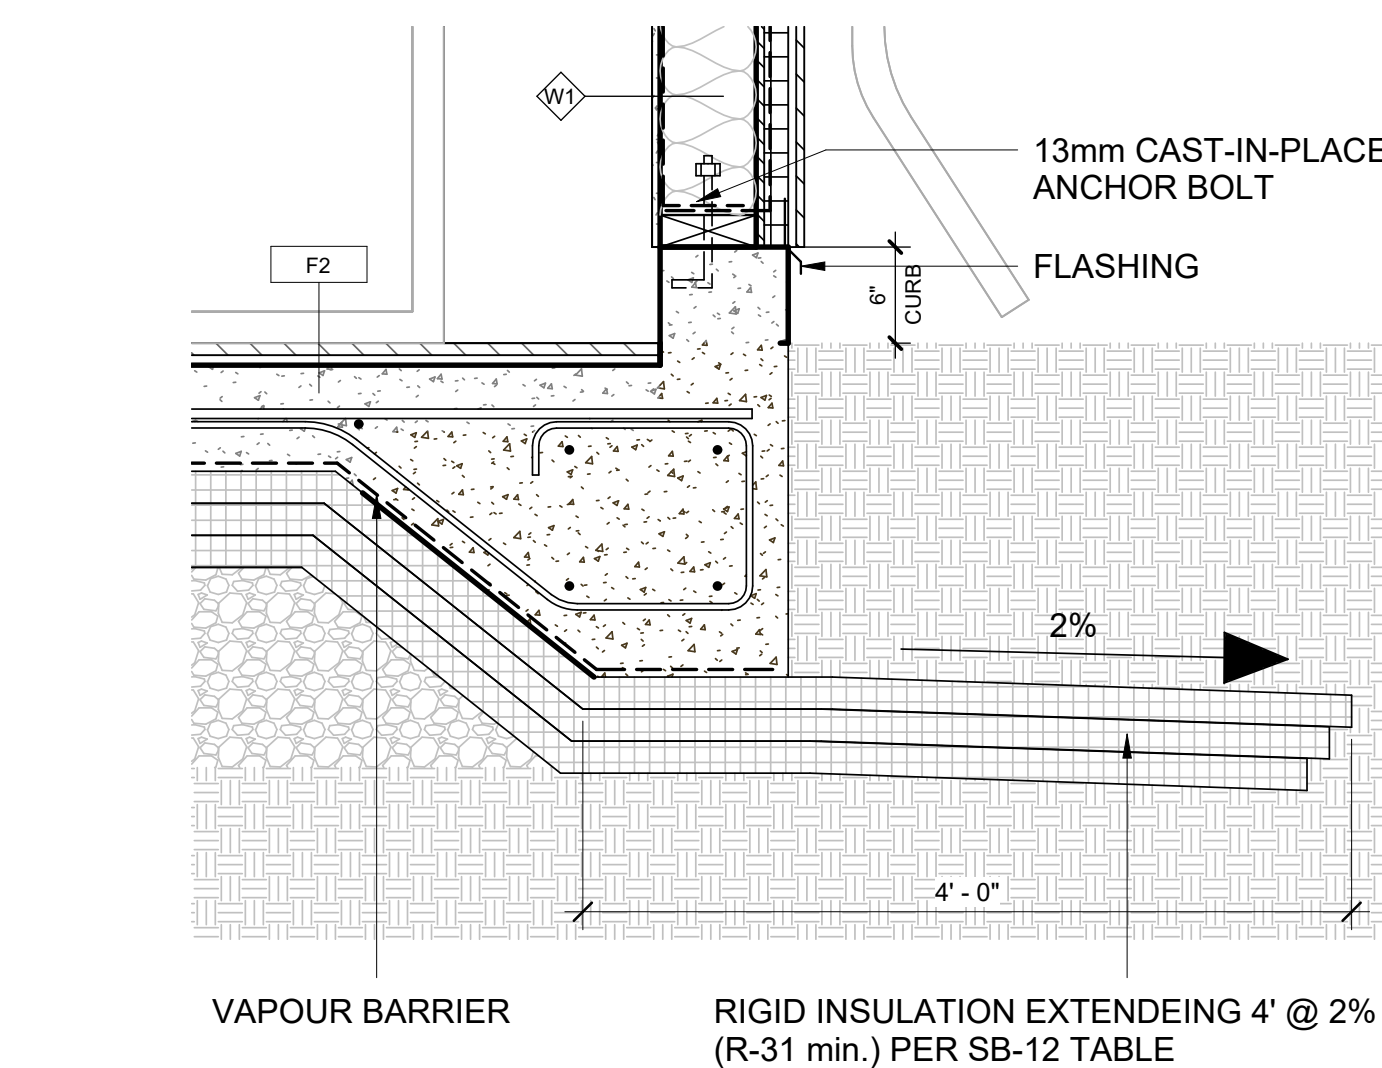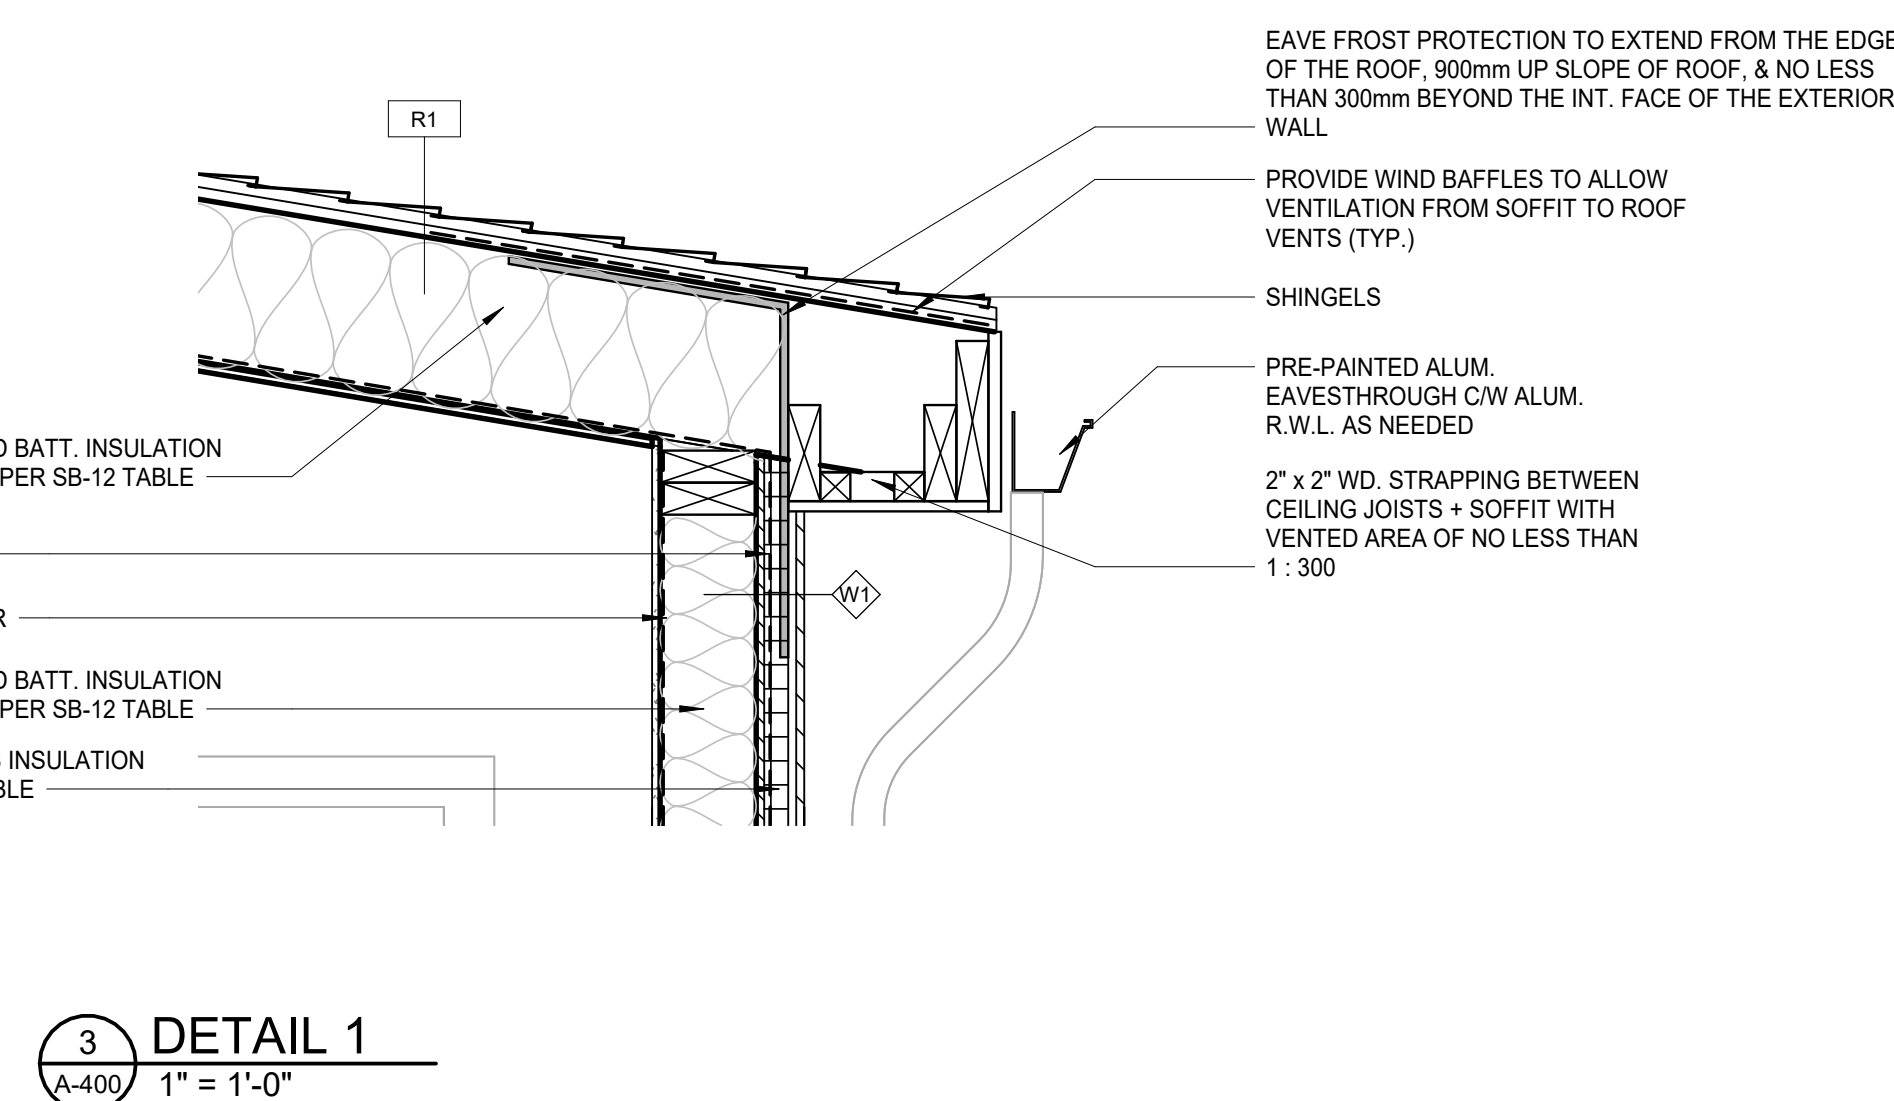


4
A-400

DETAIL 2

1" = 1'-0"

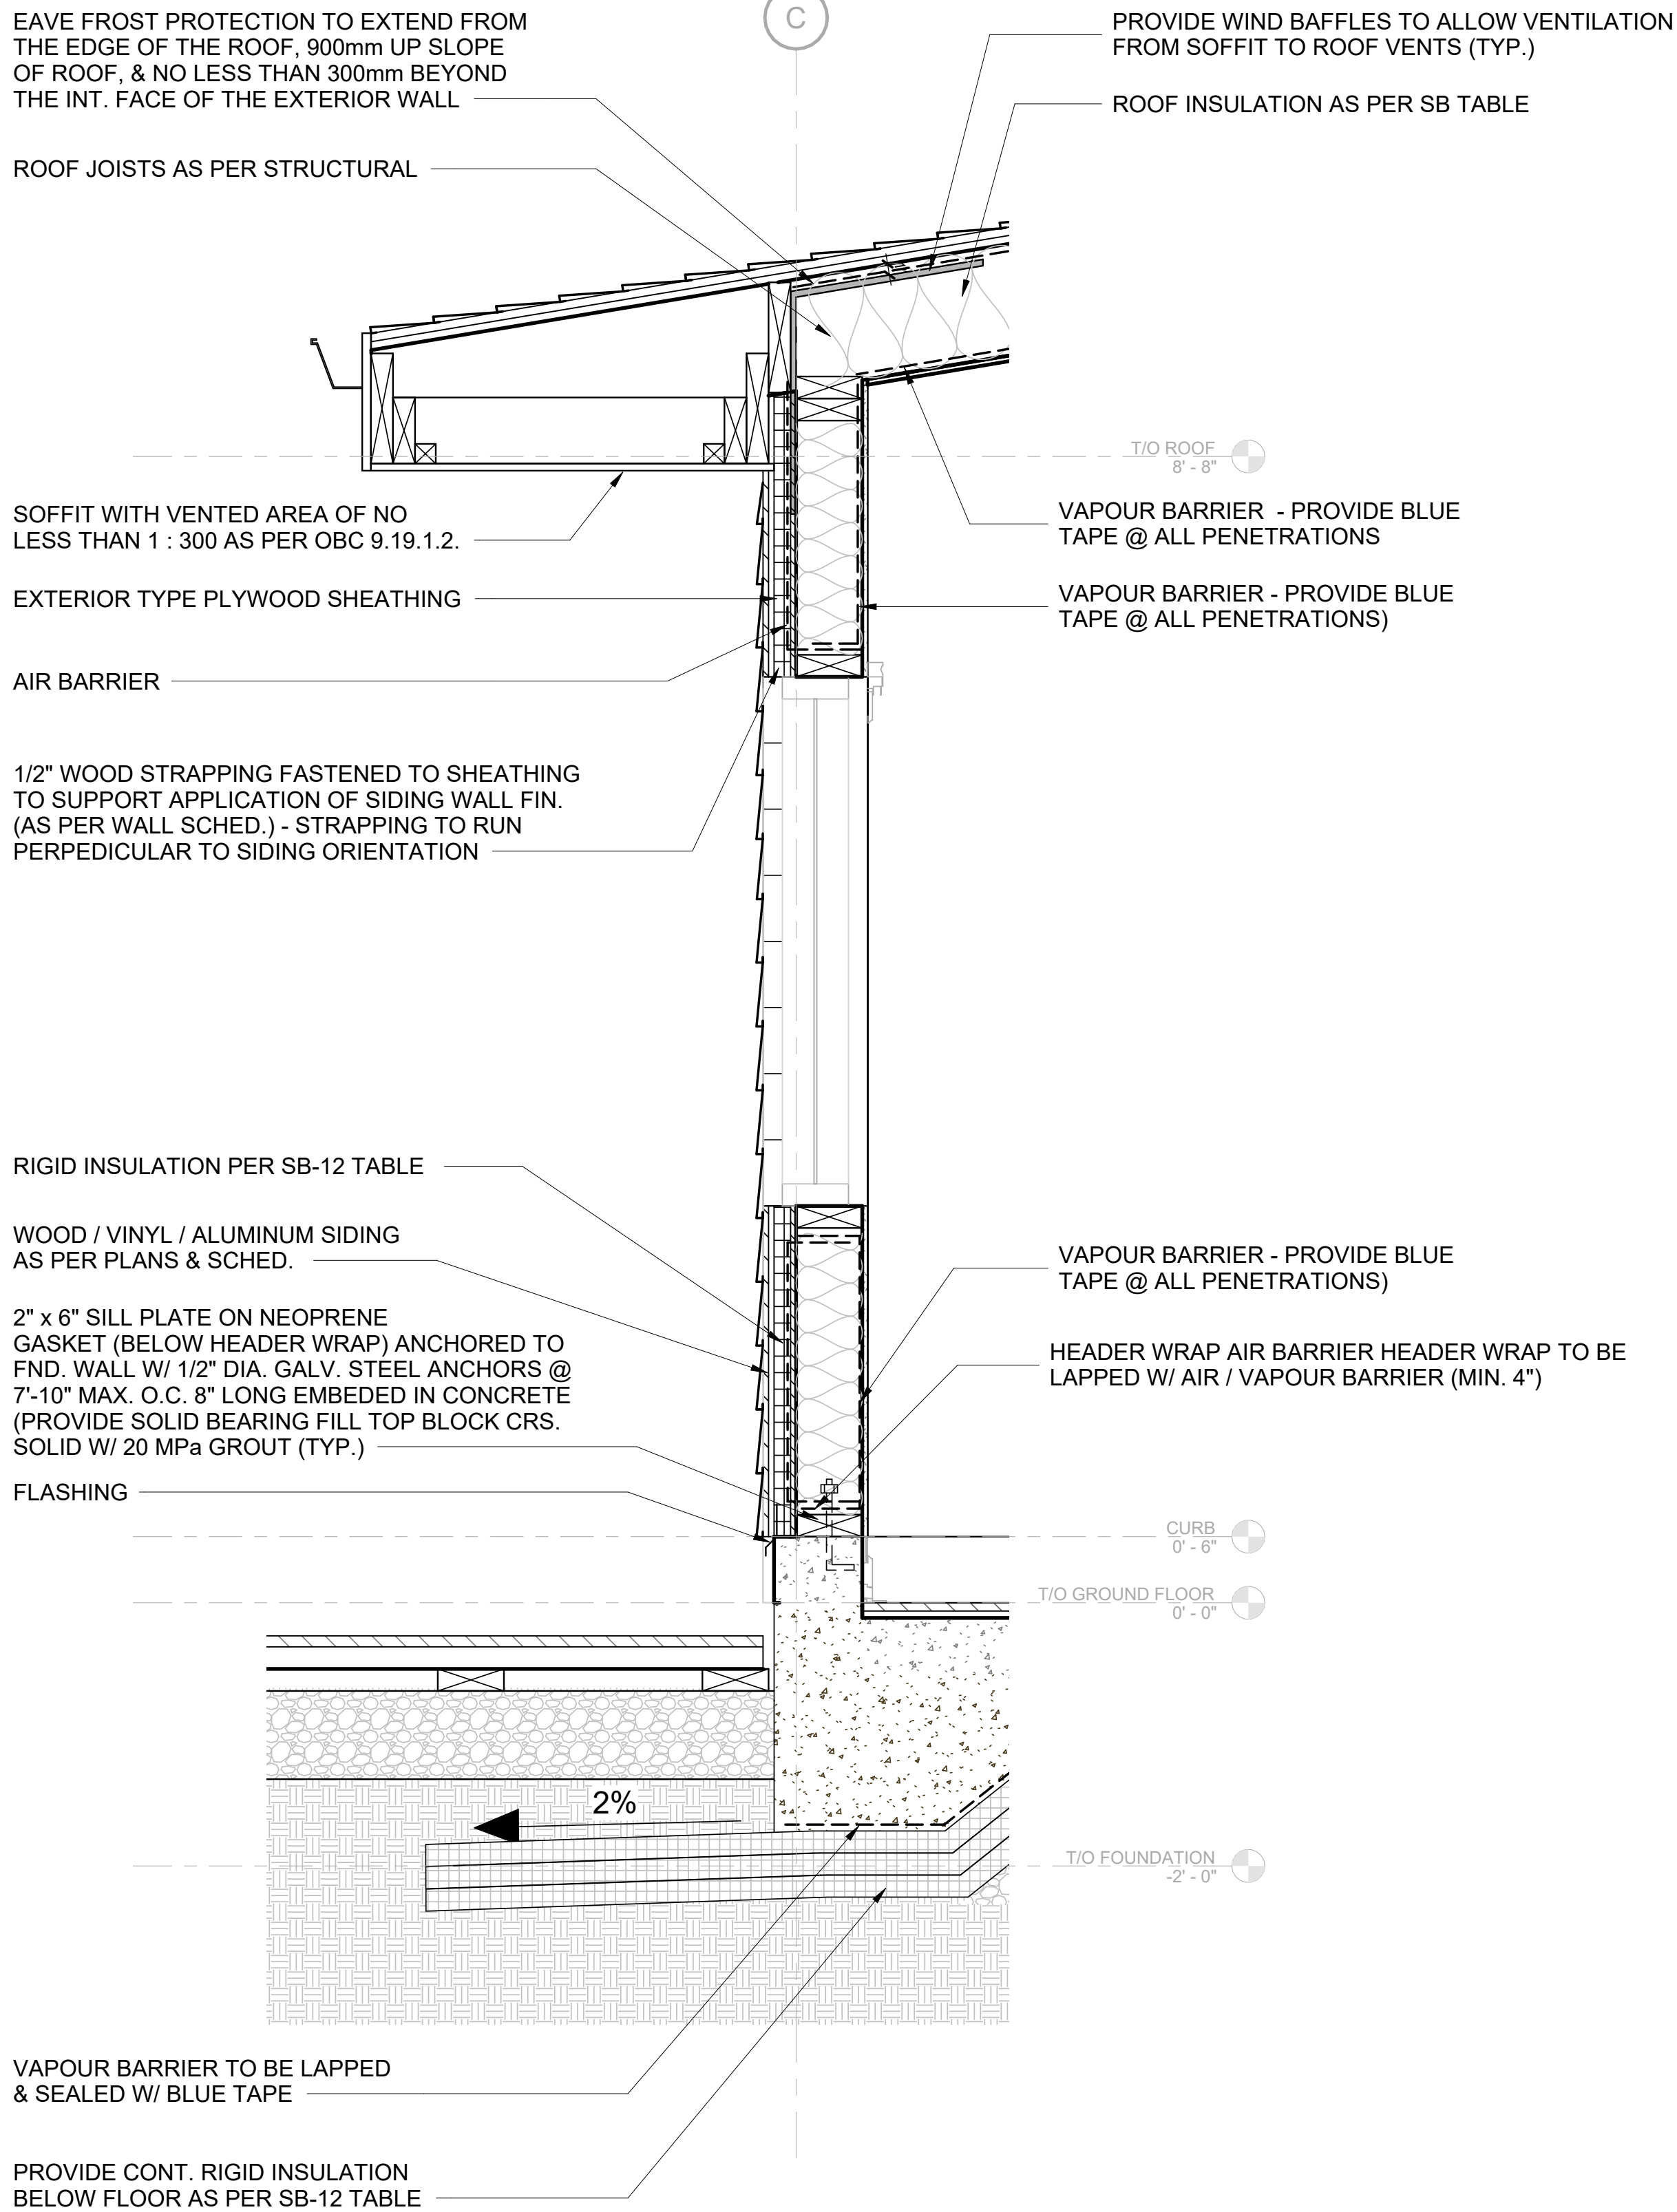

1 WALL SECTION 1
A-403 1" = 1'-0"

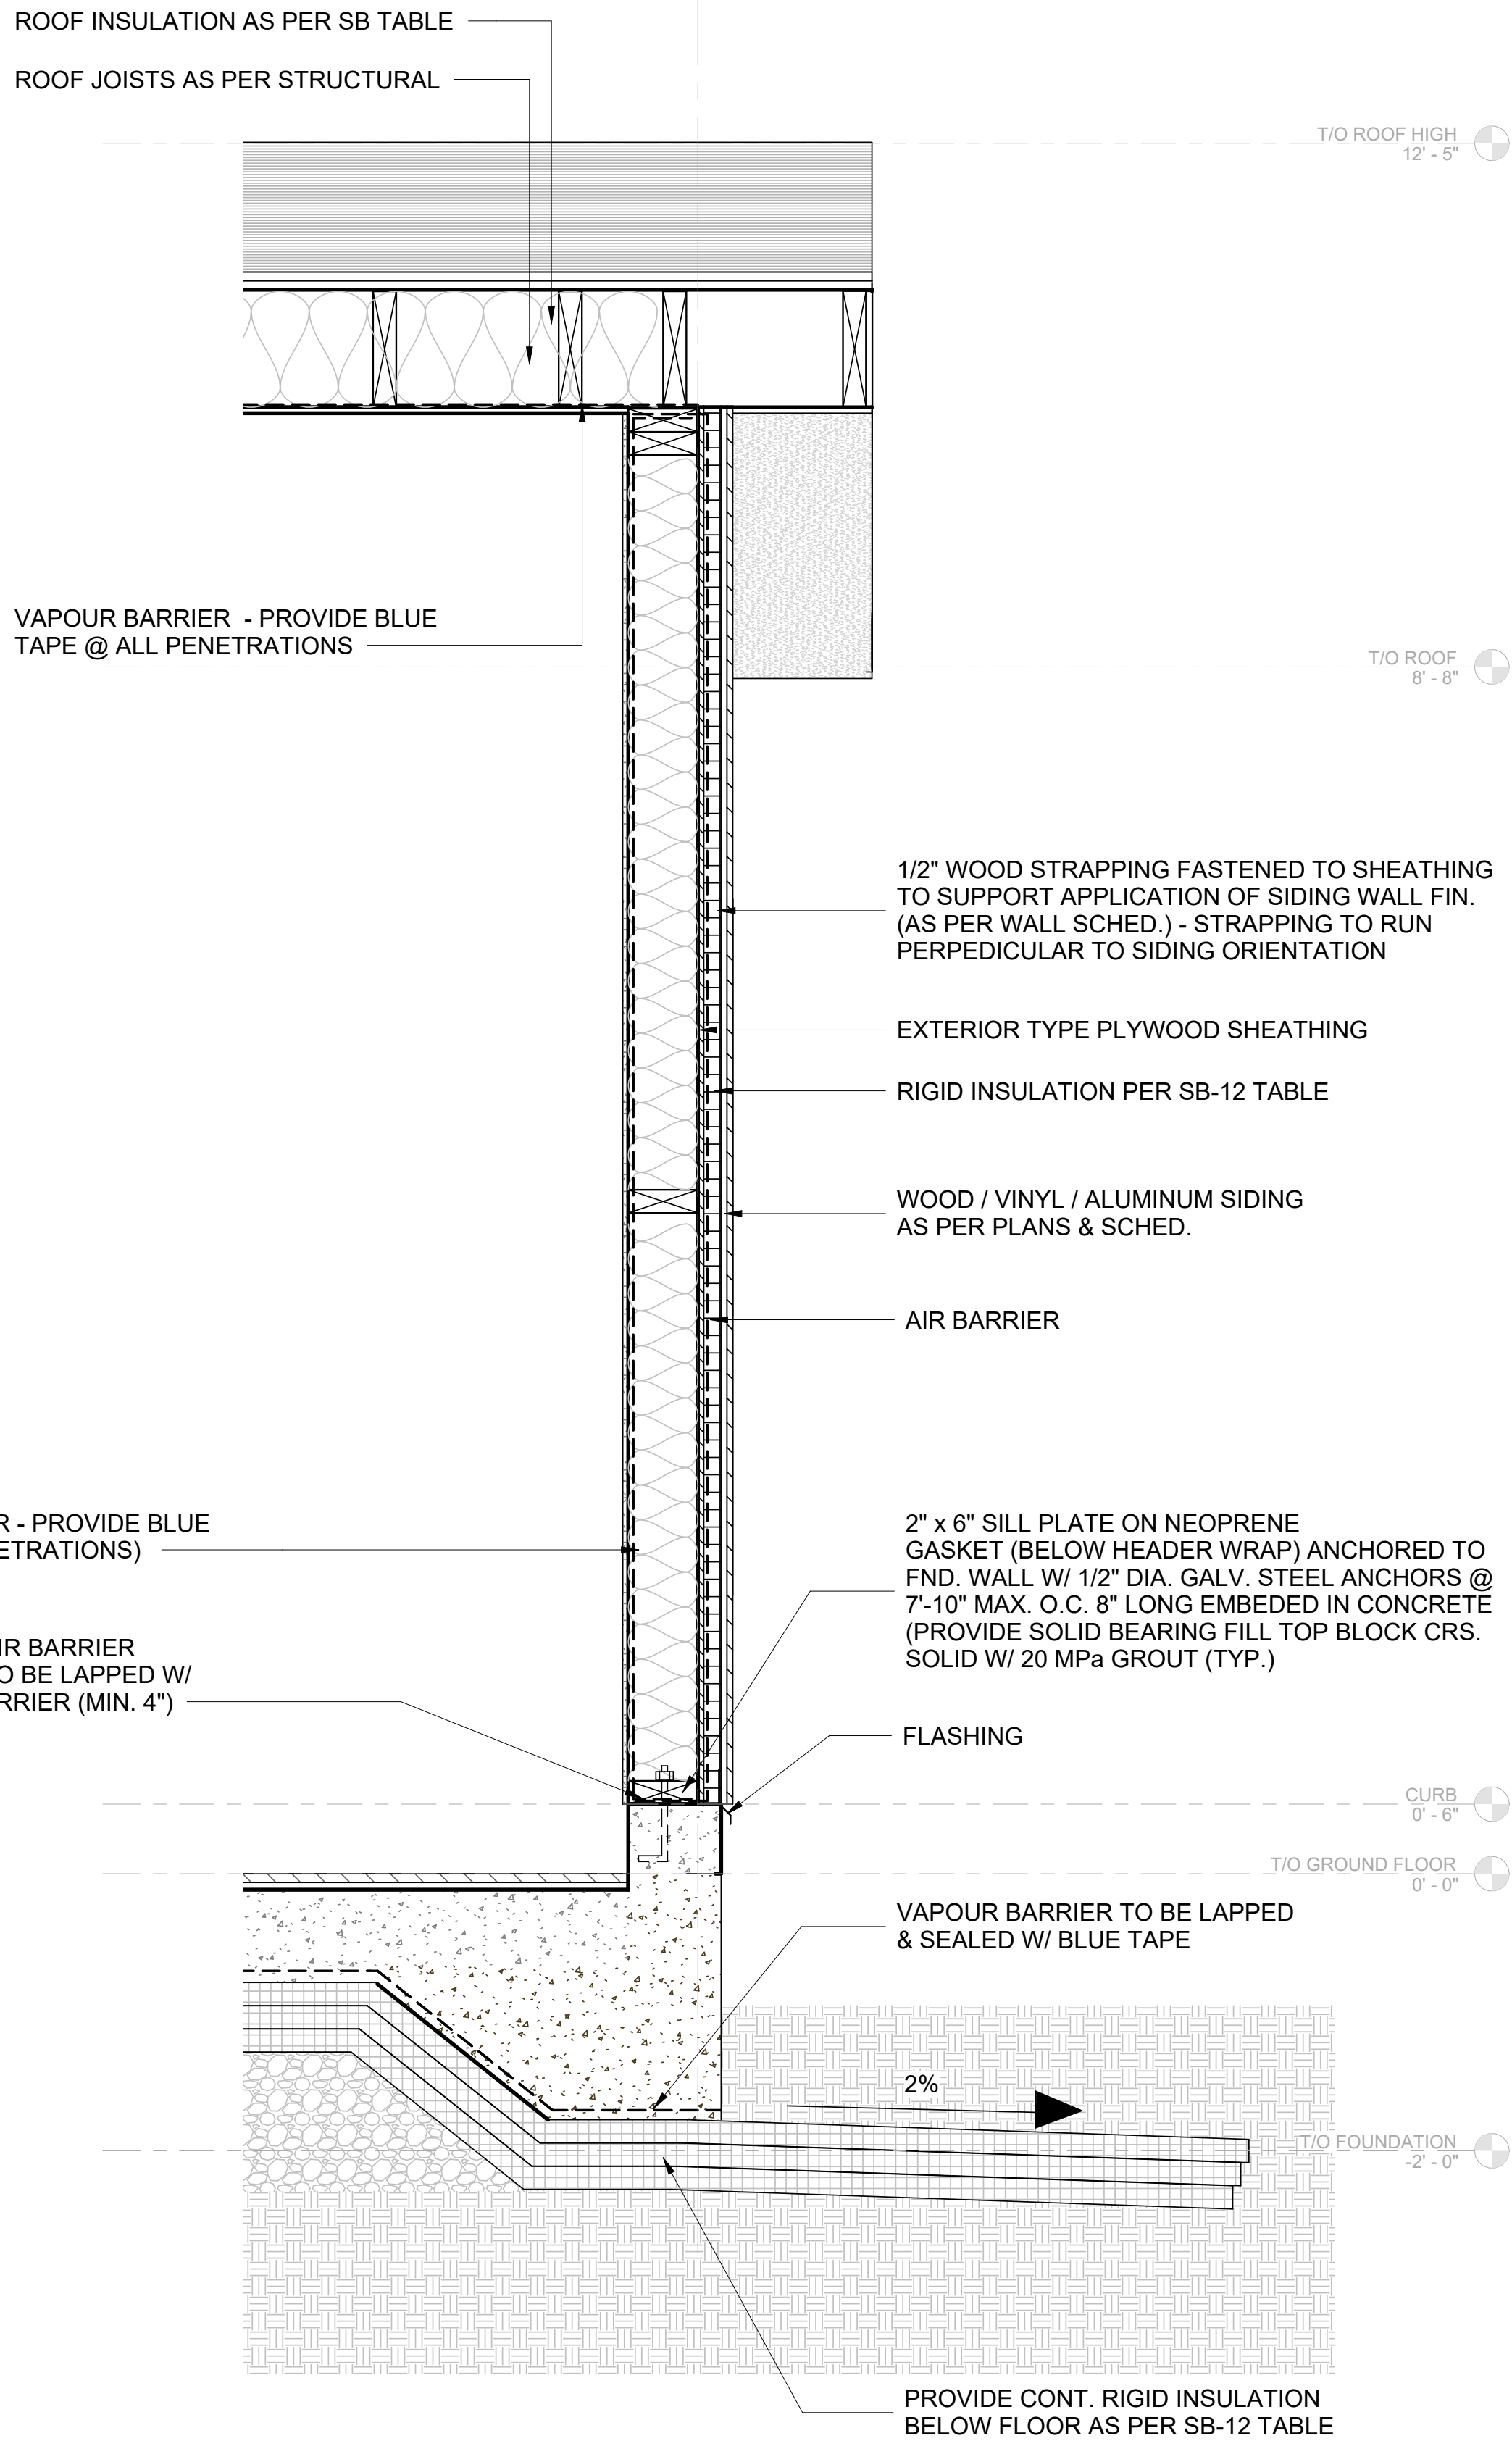

2 WALL SECTION 2
A-403 1" = 1'-0"

6	NP/ MH	Final drawings	11/15/24
5	NP/ MH	For Client Review	08/16/24
4	NP/ MH	For coordination	07/03/24
3	NP/ MH	For Client Review	06/10/24
2	NP/ MH	Review	03/09/24
1	NP/ MH	Review	02/07/24

Iss.	By	Description	Date YY-MM-DD
Issuance Schedule			

Revisions :
All previous issues of this drawing are superseded.



THESE DRAWINGS ARE NOT FOR CONSTRUCTION
NO CONSTRUCTION TO BEGIN UNTIL APPROVAL HAS BEEN GIVEN BY ALL AUTHORITIES HAVING JURISDICTION. A BUILDING PERMIT IS ISSUED AND REVIEWED BY THE ARCHITECT TO CONFIRM COMMENTS MADE BY THE AHJ IN WRITING.

DRAWINGS NOT FOR CONSTRUCTION
Drawings are not for construction until approved permit from the authorities having jurisdiction has been received by the architect and approved in writing.

DRAWINGS ARE NOT TO BE SCALED

All drawings and specifications are instruments of service and the property of the architect, and must be returned at the completion of the work.

OFNTSC - Housing Library

3 BEDROOM - ZONE 2

WALL SECTION DETAILS

scale: 1" = 1'-0"
drawn by: NP
reviewed by: MH
job number: 23011
plot date: 11/15/2024

drawing number:

A-403

2024-11-18 2:42:05 PM

MILLWORK GENERAL NOTES:

- SOLID BLOCKING BELOW ALL UPPER CABINETS
- CAULKING BETWEEN MILLWORK COUNTERS AND WALLS
- MILLWORK DOORS AND DRAWERS TO HAVE SOFT CLOSING HARDWARE

FINISHES:

- DOOR STYLE: PANELS TO BE FLAT STYLE DOOR
- FRAMING: SOLID WOOD FRAMING AND WOOD VENEER
- FINISH: LAMINATE FINISH
- BACKSPLASH - 4" BACK AND SIDE SPLASH - SAME MATERIAL AS THE COUNTERTOP

6	NP/	Final drawings	11/15/24
5	NP/	For Client Review	08/16/24
4	NP/	For coordination	07/03/24
3	NP/	For Client Review	06/10/24
2	NP/	Review	03/09/24
1	NP/	Review	02/07/24

Iss.	By	Description	Date YY-MM-DD
Issuance Schedule			

Revisions :
All previous issues of this drawing are superseded.



THESE DRAWINGS ARE NOT FOR CONSTRUCTION
NO CONSTRUCTION TO BEGIN UNTIL APPROVAL HAS BEEN GIVEN BY ALL AUTHORITIES HAVING JURISDICTION. A BUILDING PERMIT IS ISSUED AND REVIEWED BY THE ARCHITECT TO CONFIRM COMMENTS MADE BY THE AHJ IN WRITING.

DRAWINGS NOT FOR CONSTRUCTION
Drawings are not for construction until approved permit from the authorities having jurisdiction has been received by the architect and approved in writing.

DRAWINGS ARE NOT TO BE SCALED
Contractor must verify all dimensions on the drawings and report any discrepancies to the architect before proceeding with the work.

All drawings and specifications are instruments of service and the property of the architect, and must be returned at the completion of the work.

OFNTSC - Housing Library

3 BEDROOM - ZONE 2



ENLARGED MILLWORK DETAIL

scale: As indicated
drawn by: NP
reviewed by: MH
job number: 23011
plot date: 11/15/2024



drawing number:

A-500


2024-11-18 2:42:08 PM

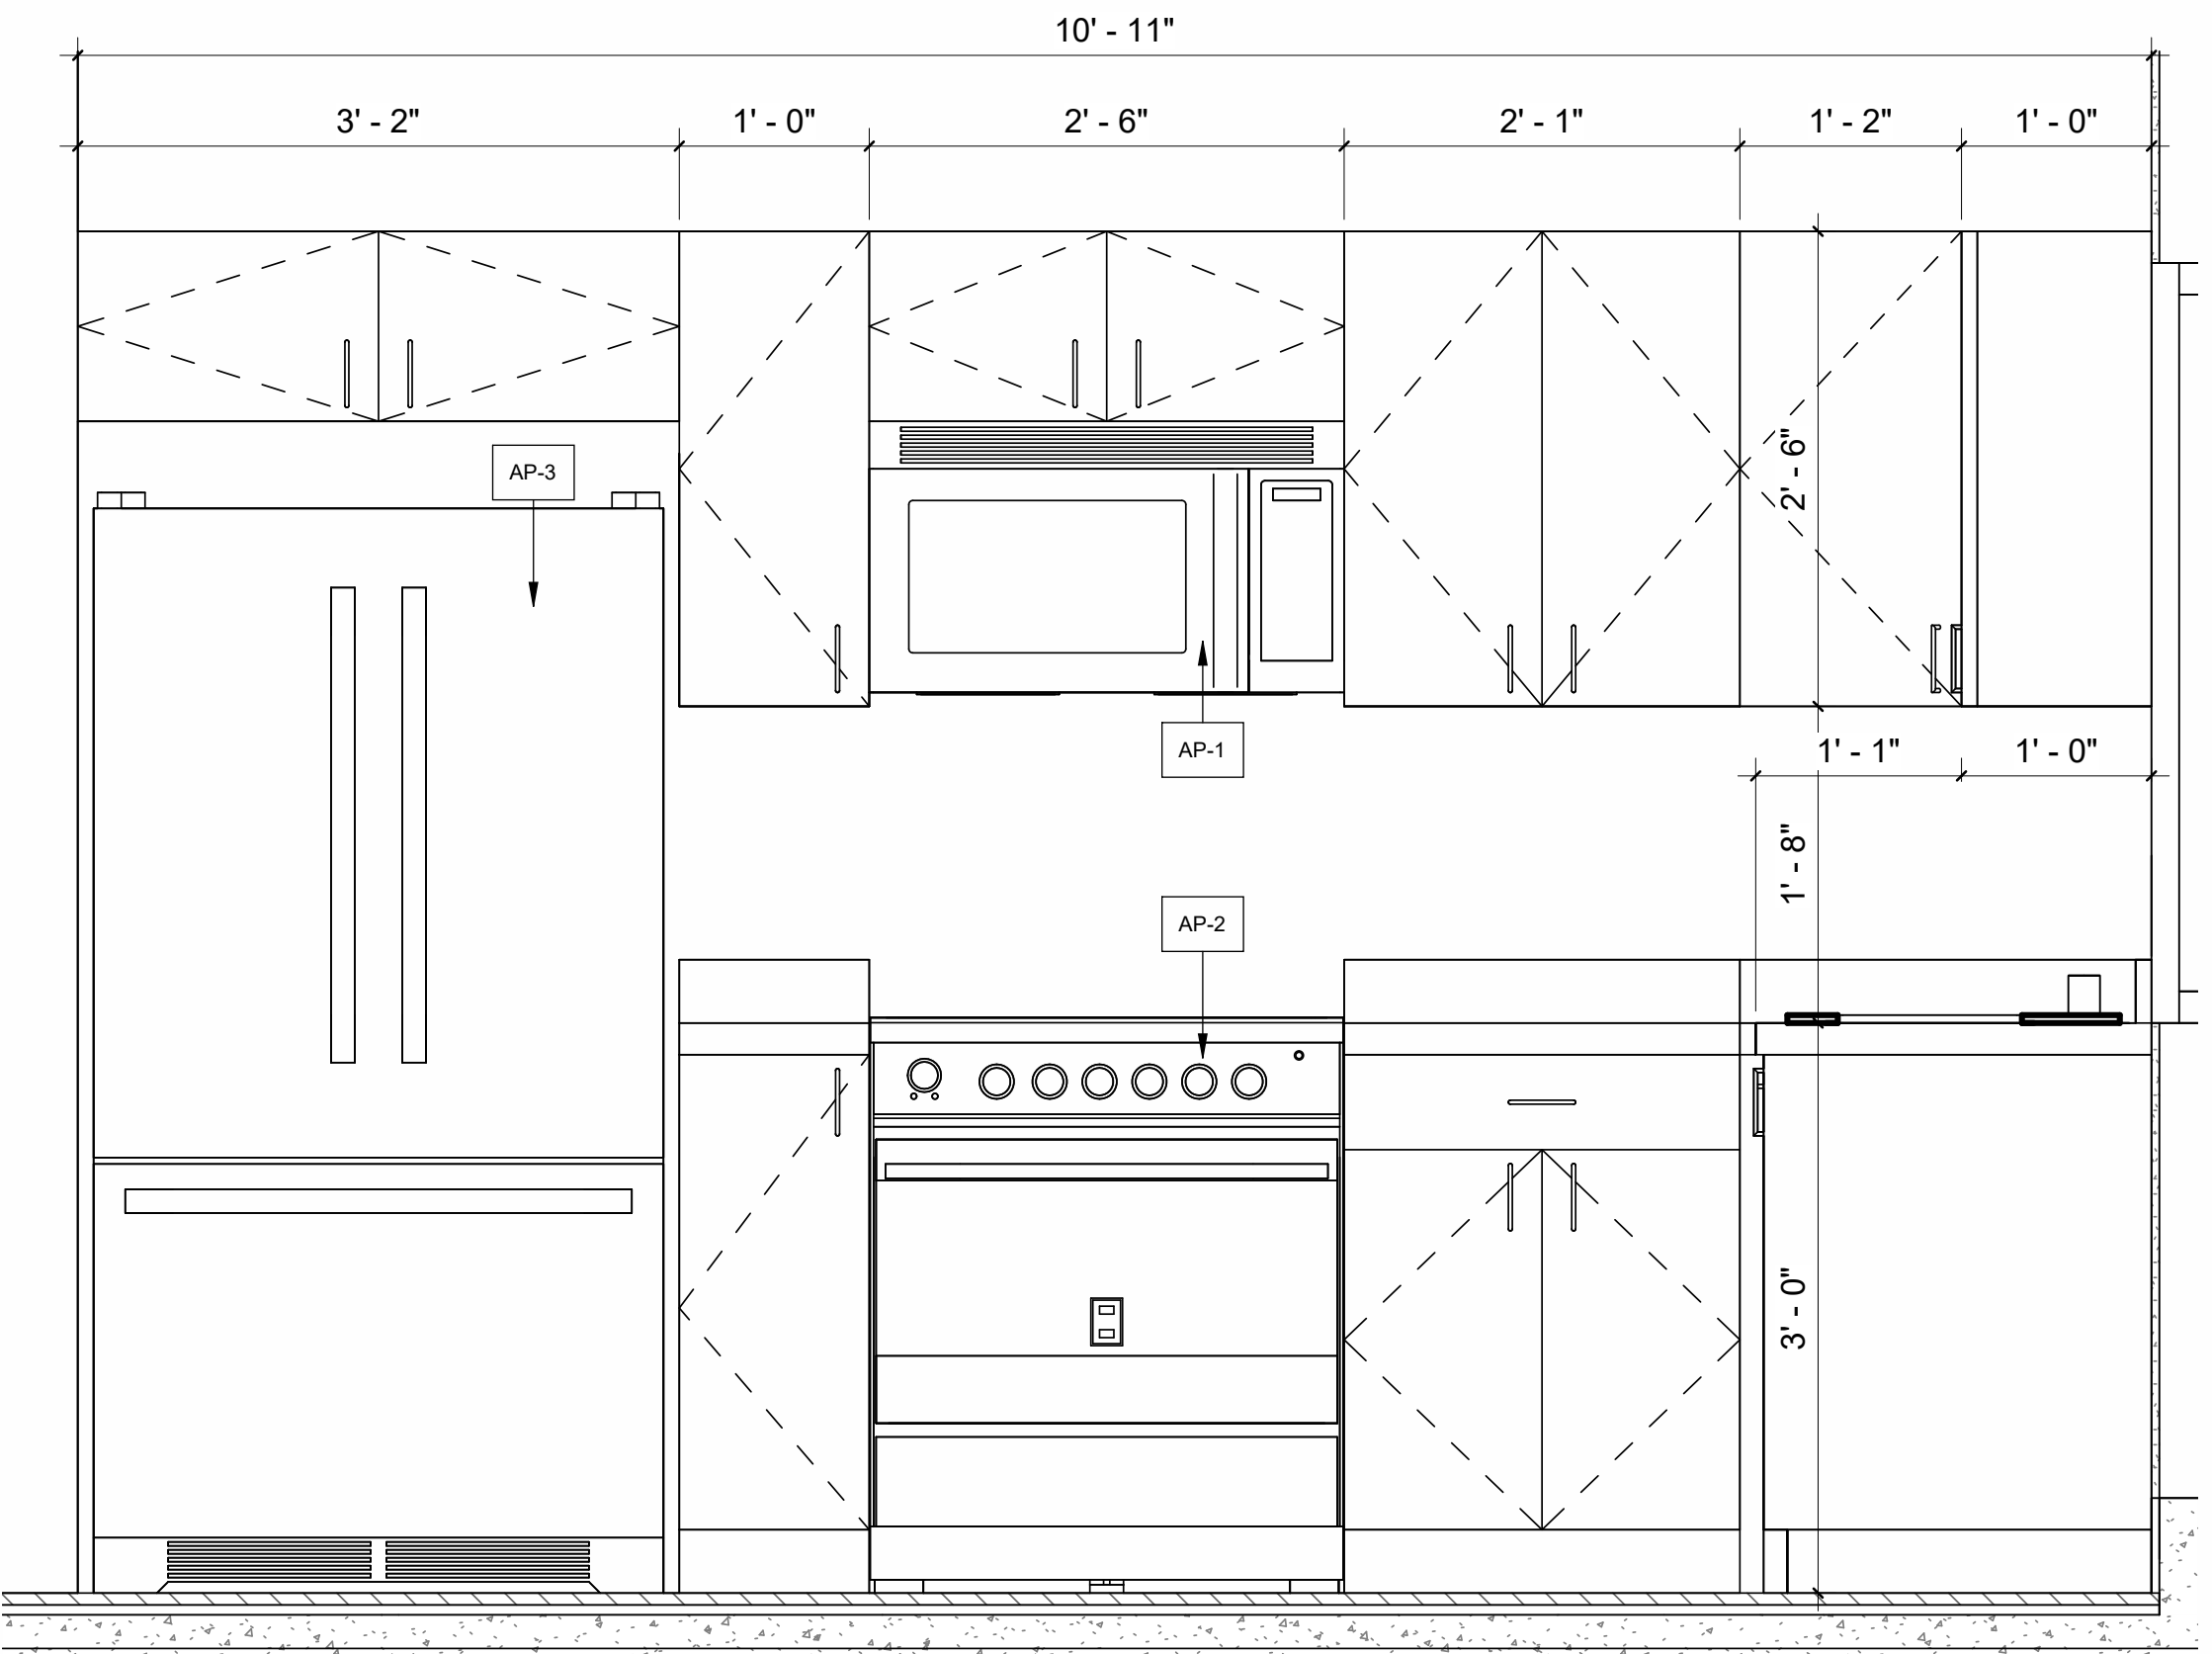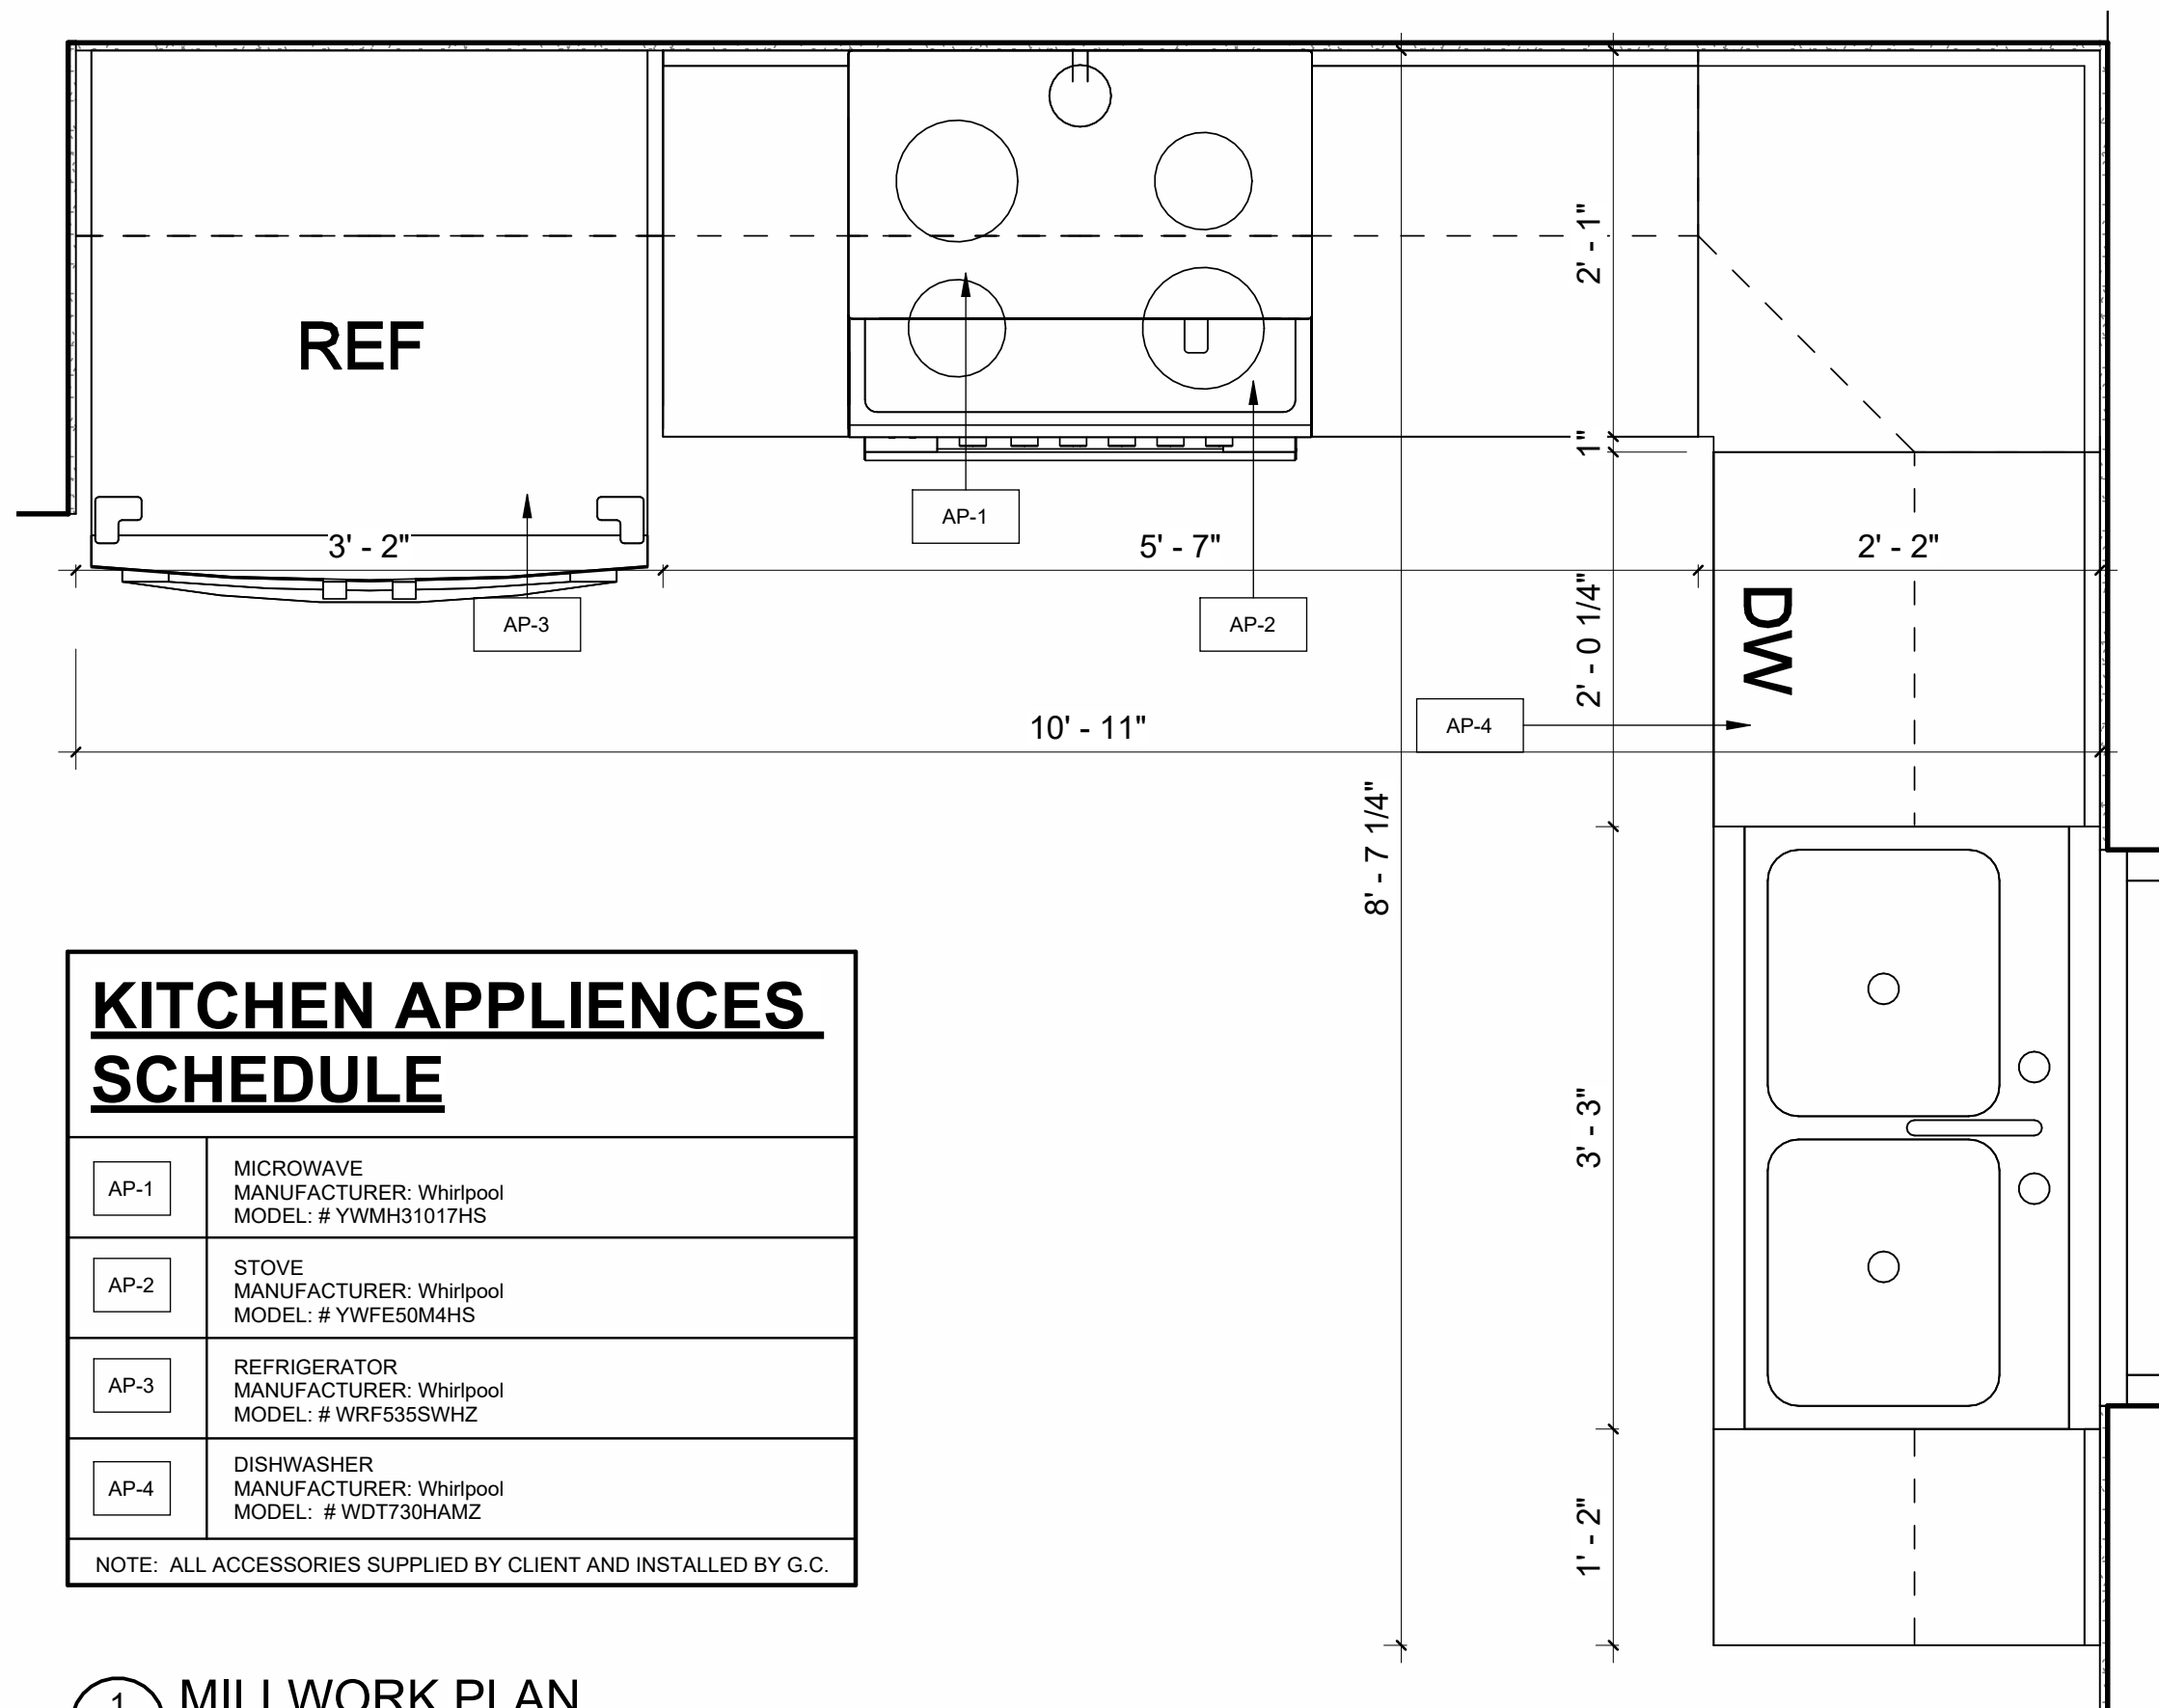

3 MILLWORK VIEW 1
1" = 1'-0"

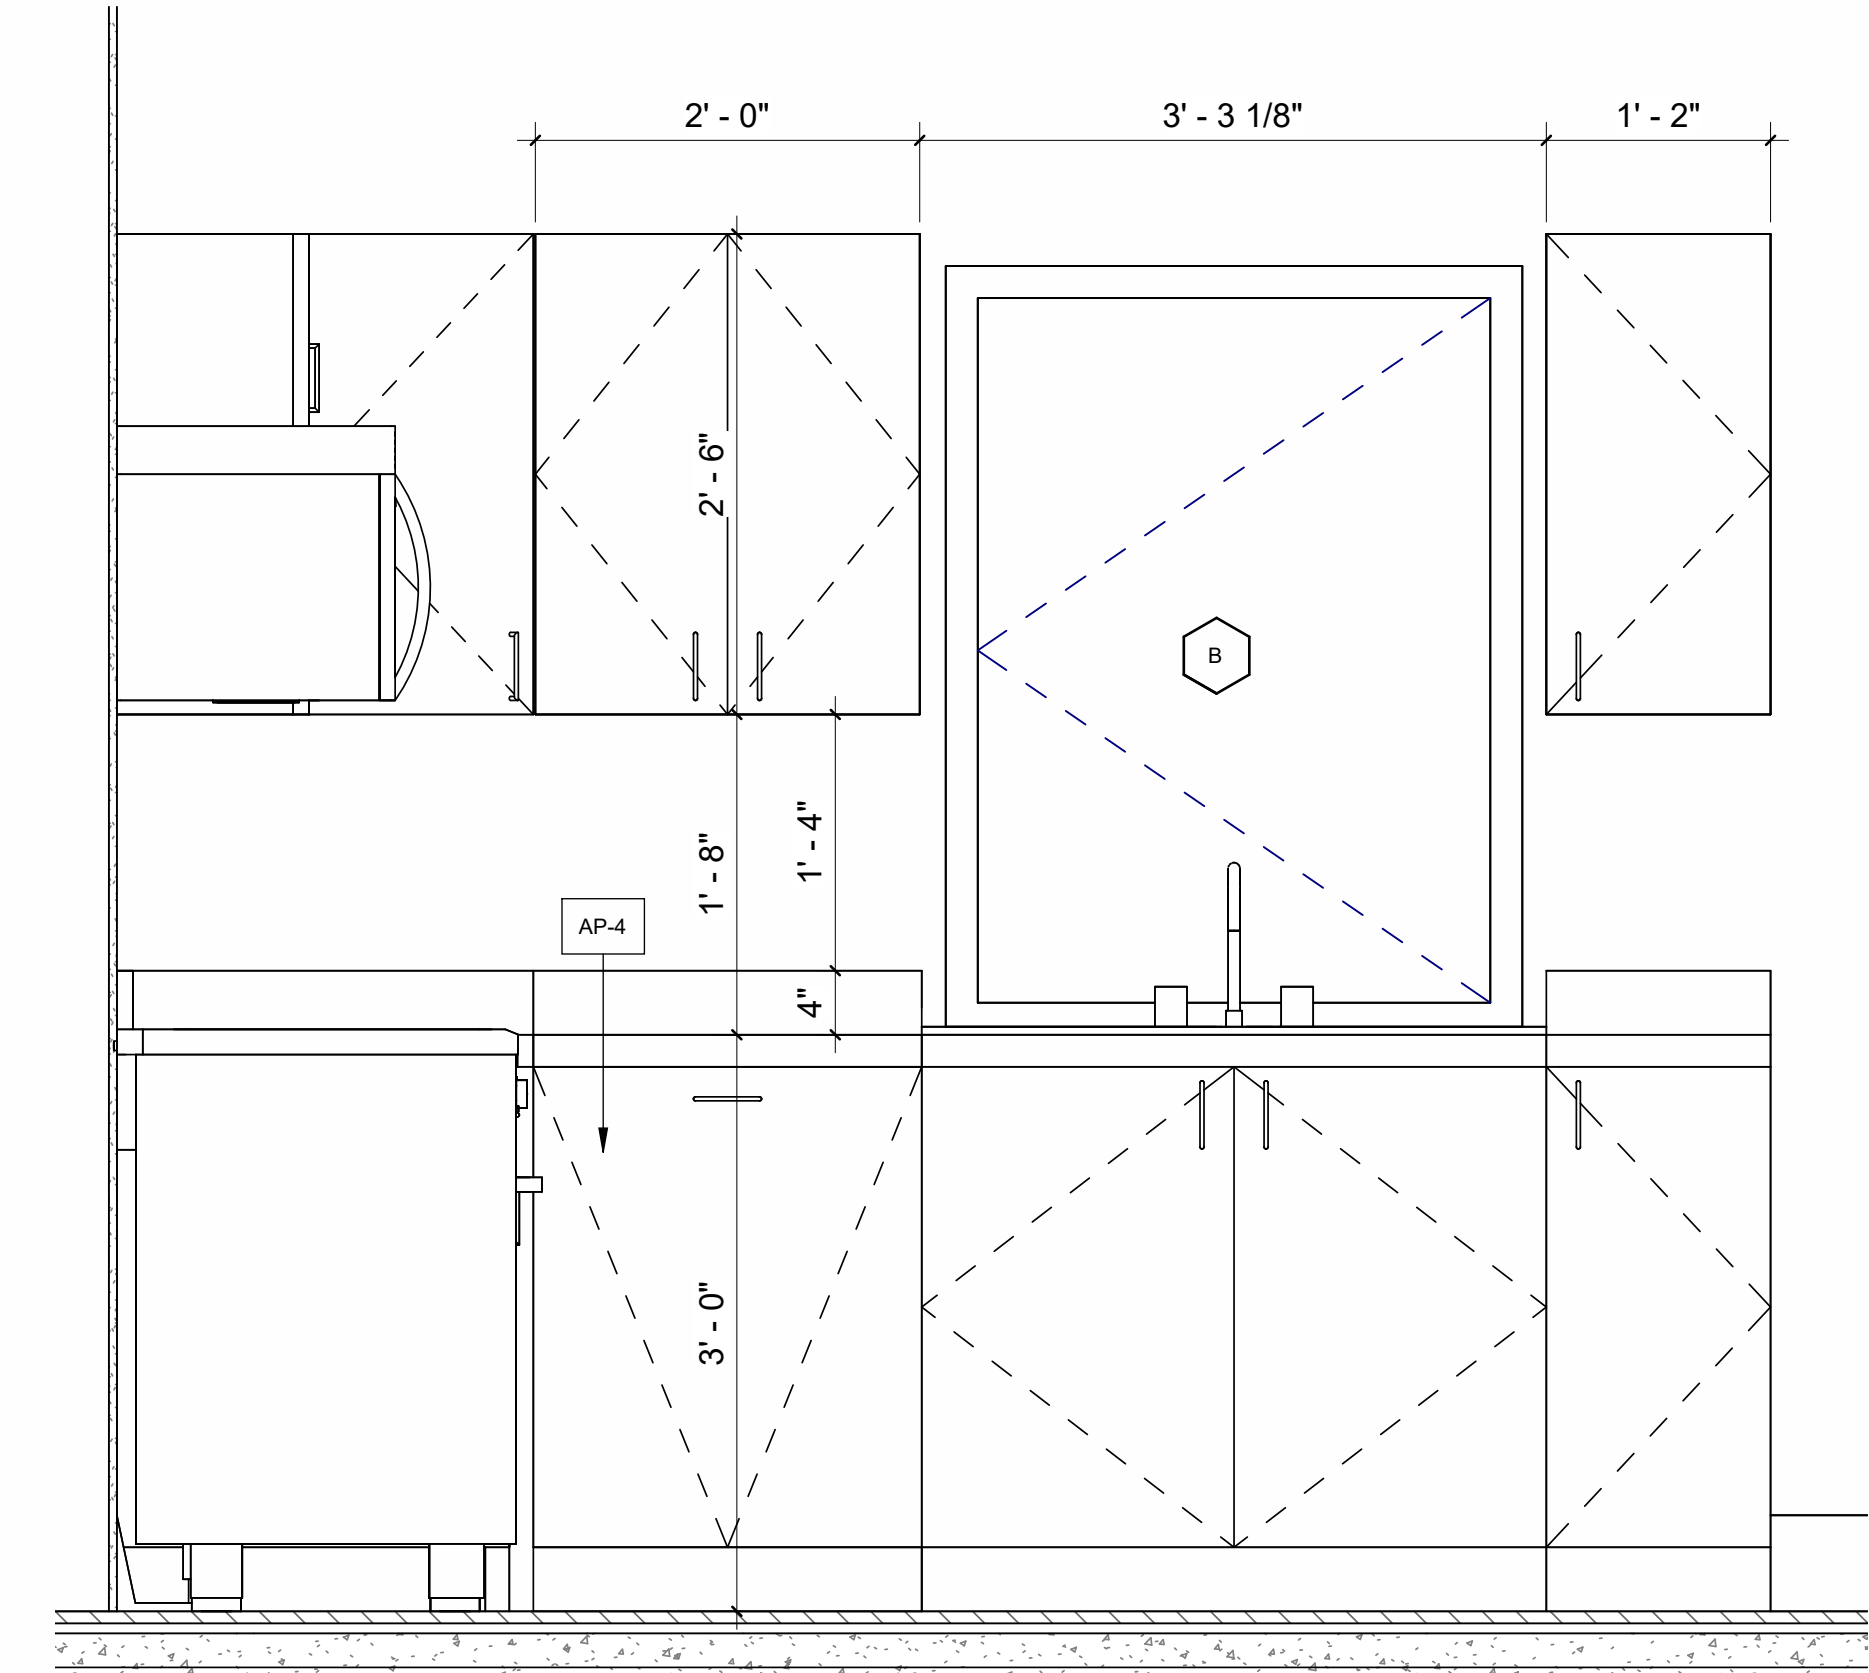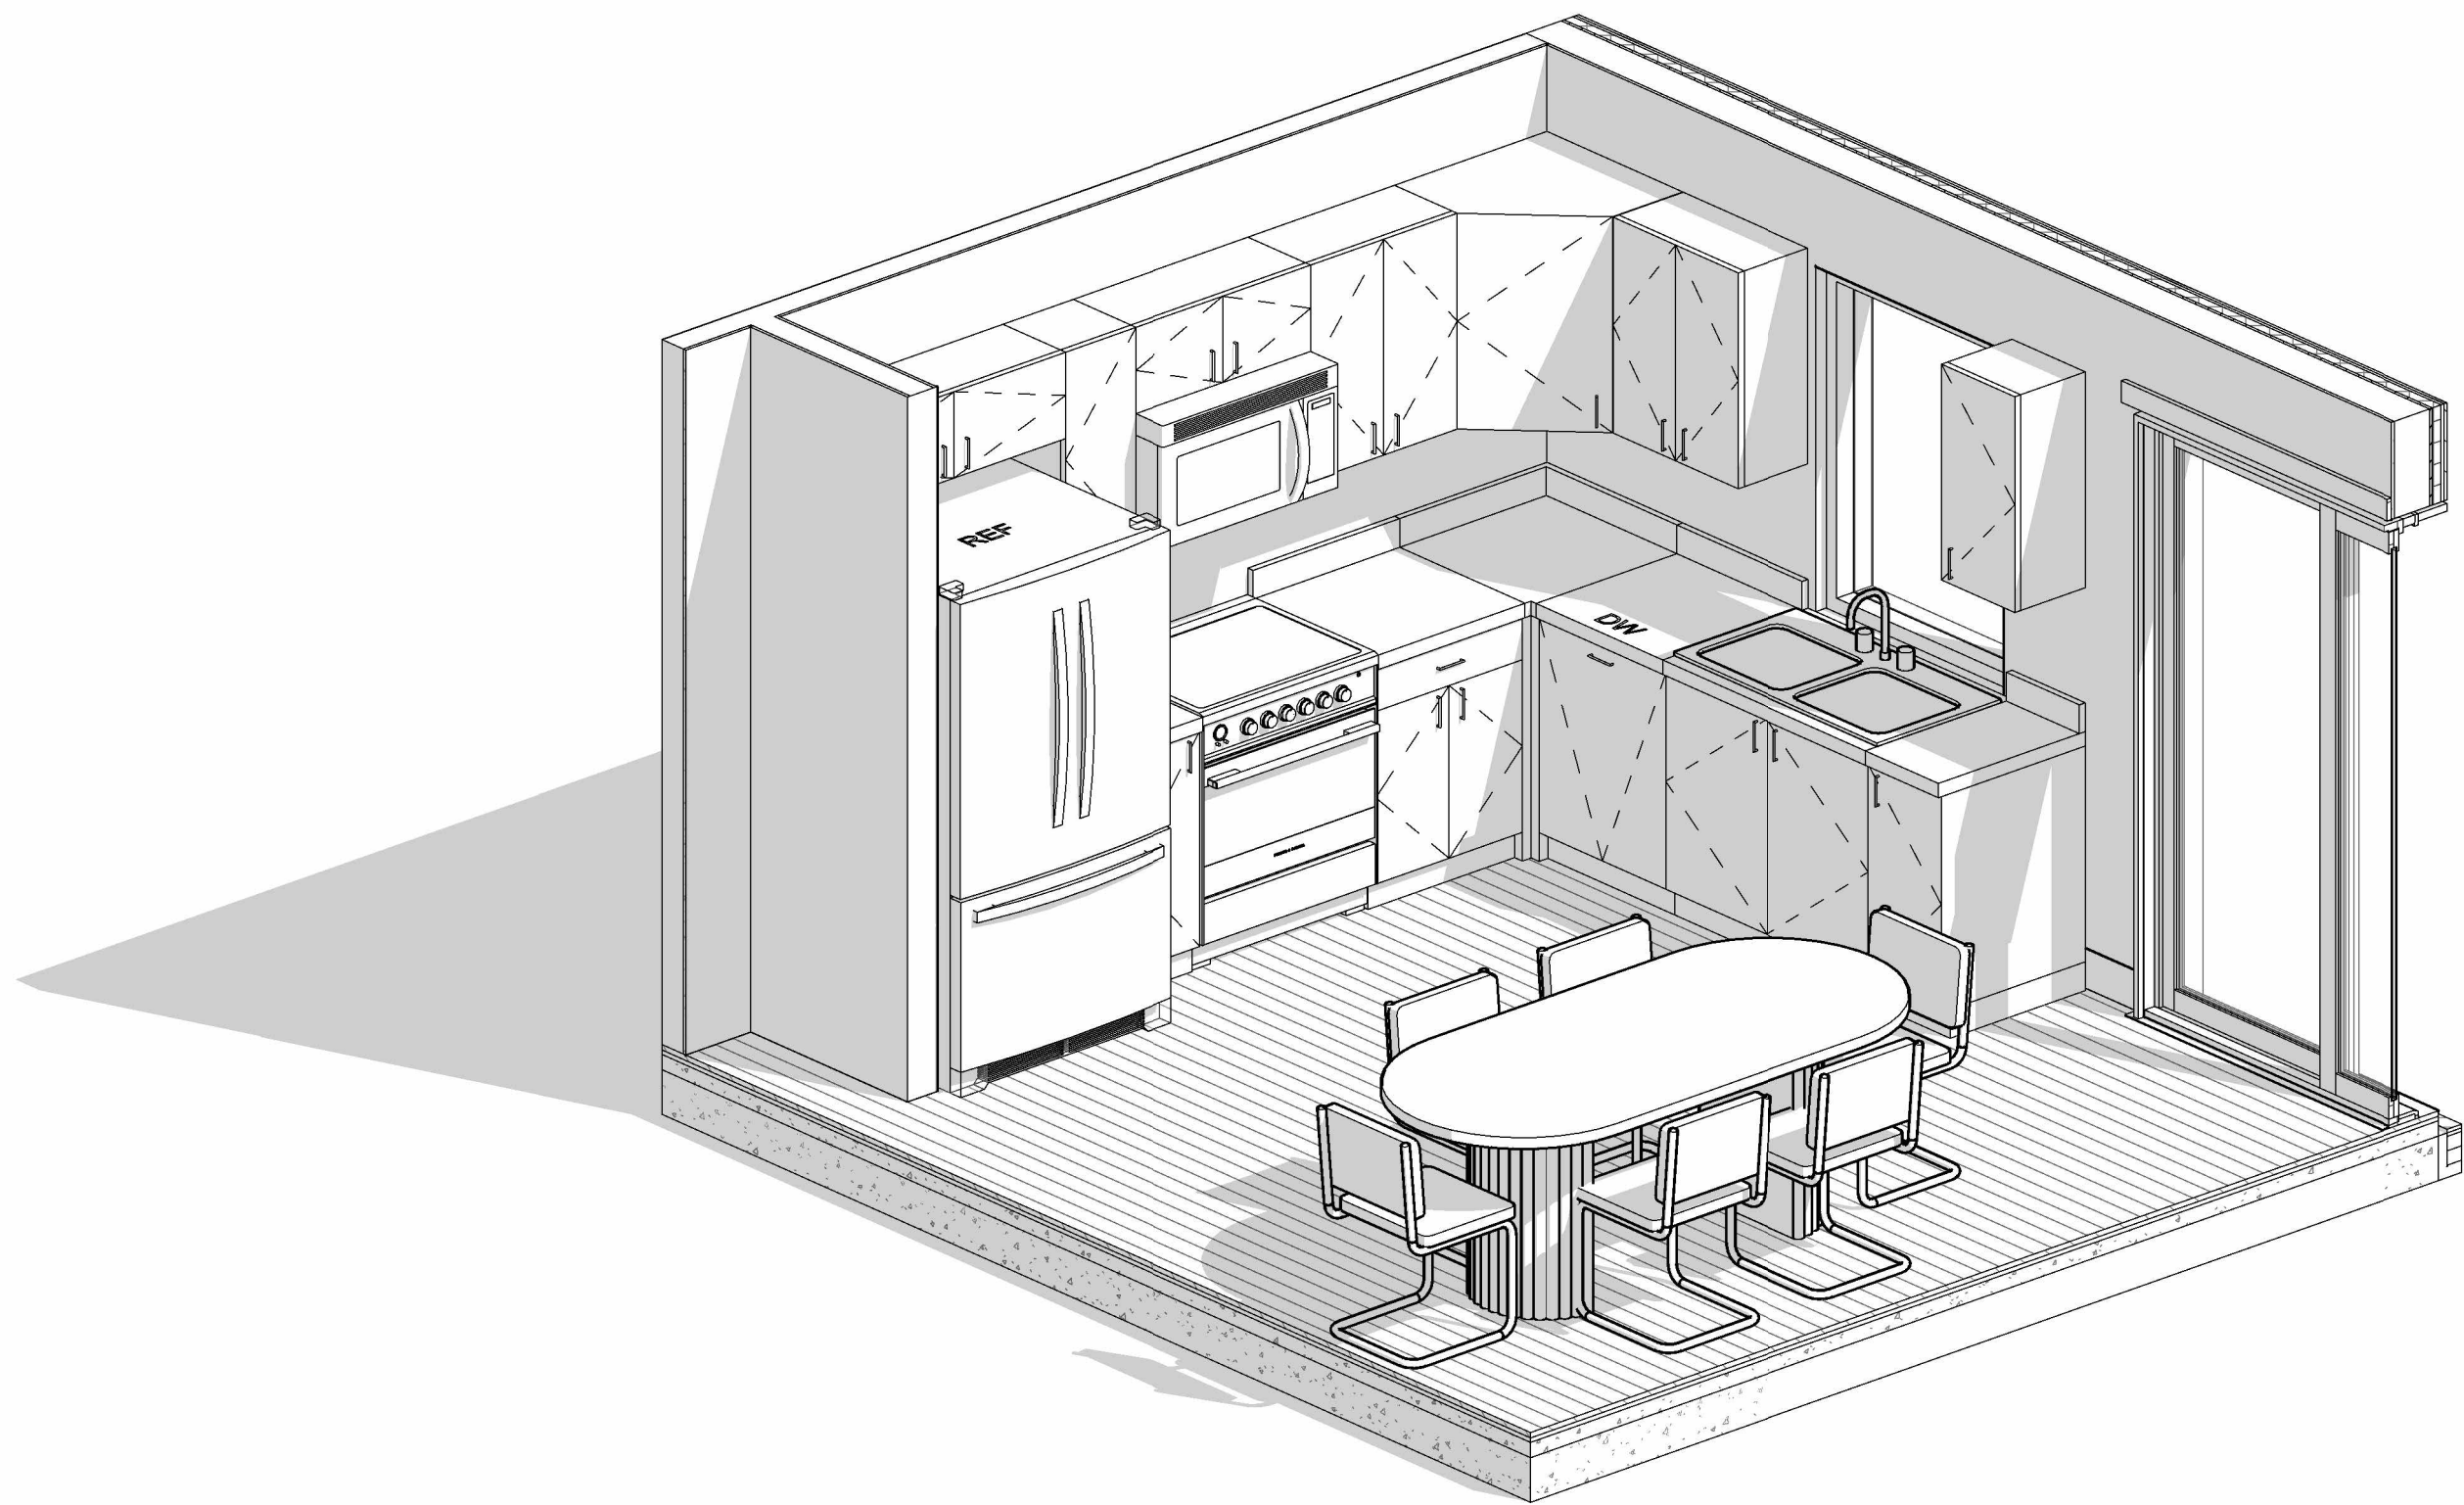

2 MILLWORK VIEW 2
1" = 1'-0"

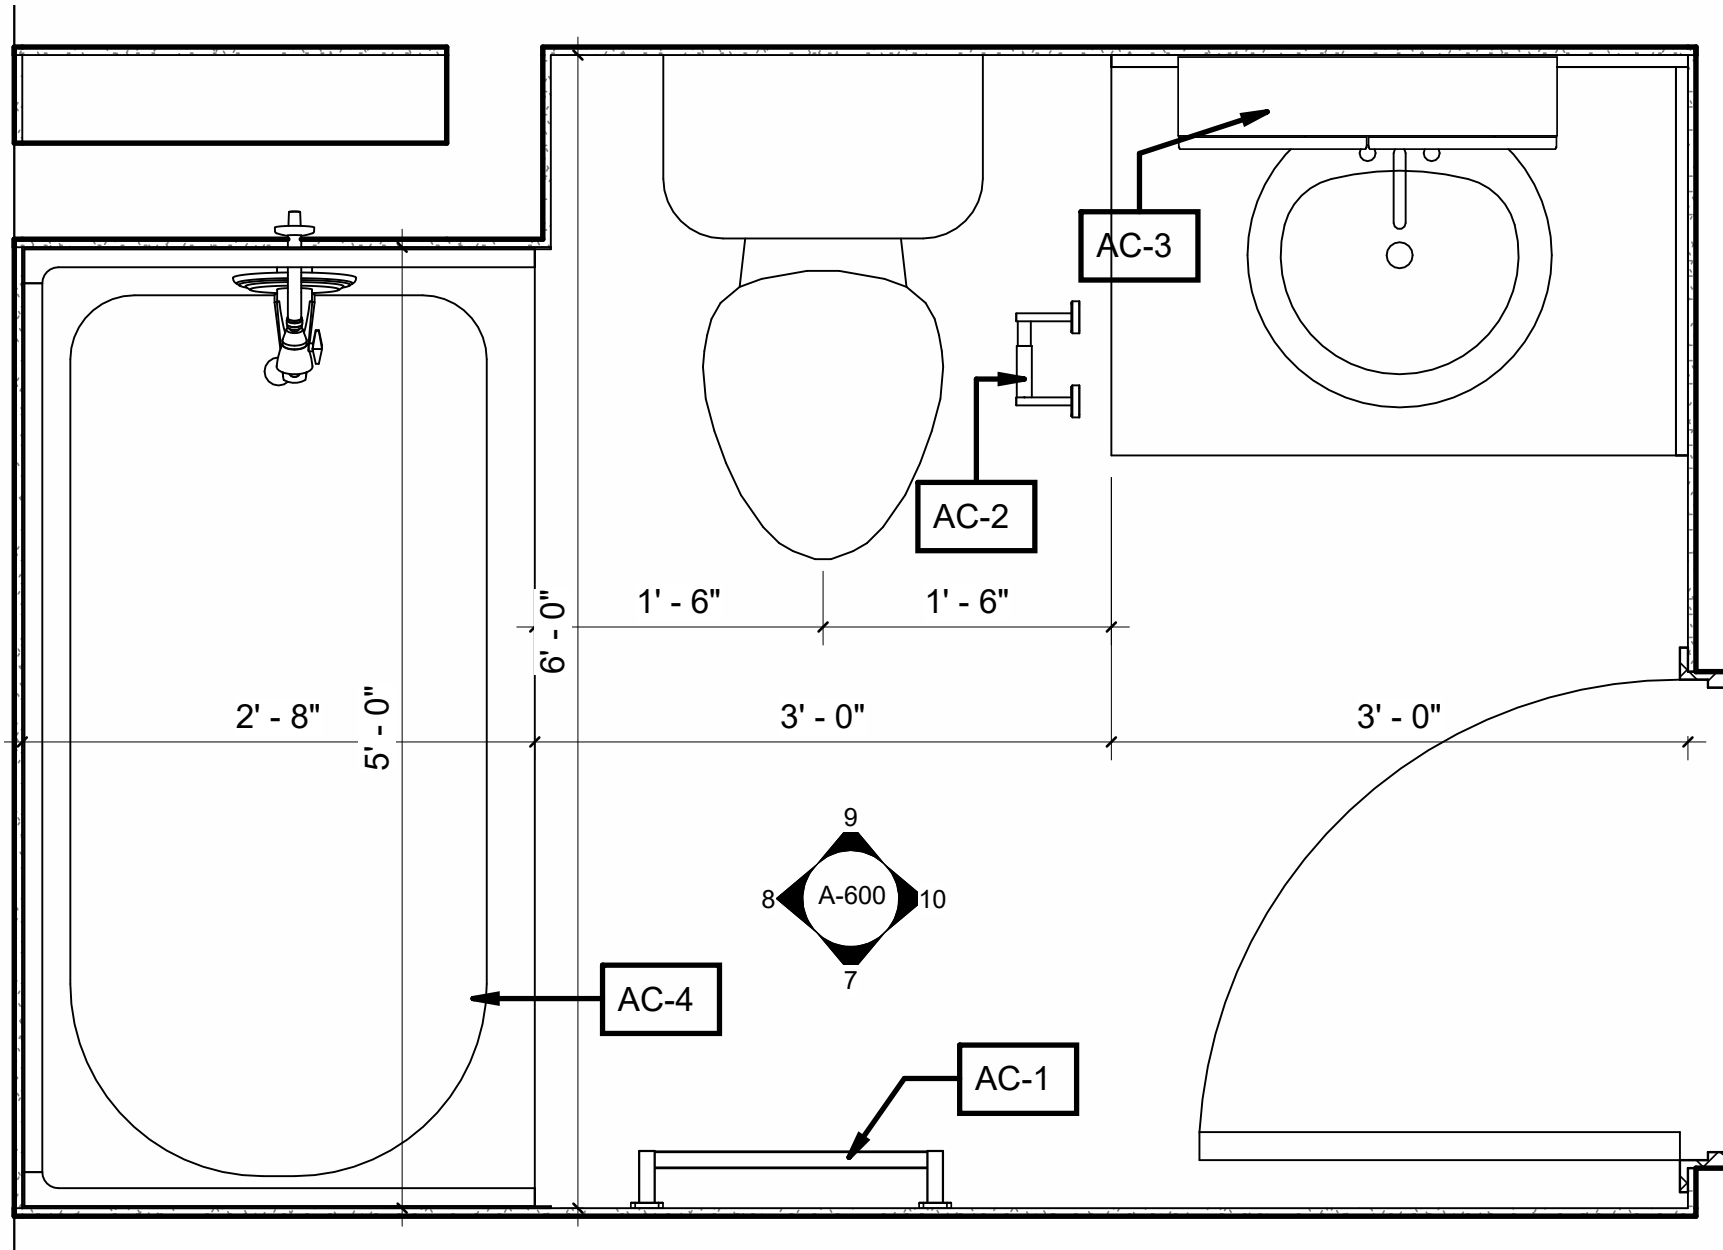


1 BATHROOM 1 ENLARGED PLAN
A-600 1" = 1'-0"


WASHROOM ACCESSORIES SCHEDULE

AC-1	TOWEL ROD MANUFACTURER: BOBRICK
AC-2	SURFACE-MOUNTED TOILET TISSUE DISPENSER MANUFACTURER: BOBRICK MODEL: B-685
AC-3	MIRROR CABINETS MANUFACTURER: HOMCOM
AC-4	ONE-PIECE SHOWER MANUFACTURER: MAAX MODEL: CAMELIA TS-6032
AC-5	SHOWER ROD MANUFACTURER: BOBRICK MODEL: B-6047 AND B-204


NOTE: ALL ACCESSORIES SUPPLIED BY CLIENT AND INSTALLED BY G.C.

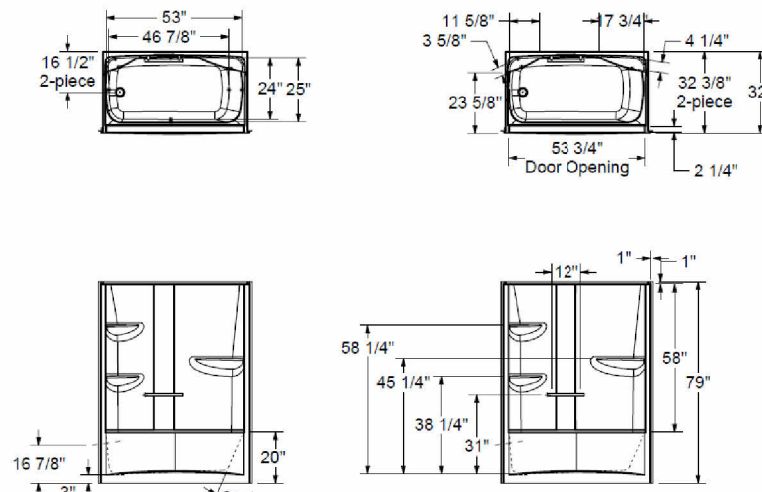


AC-4 - CAMELIA TS-6032 ACRYLIC
ALCOVE ONE-PIECE TUB SHOWER

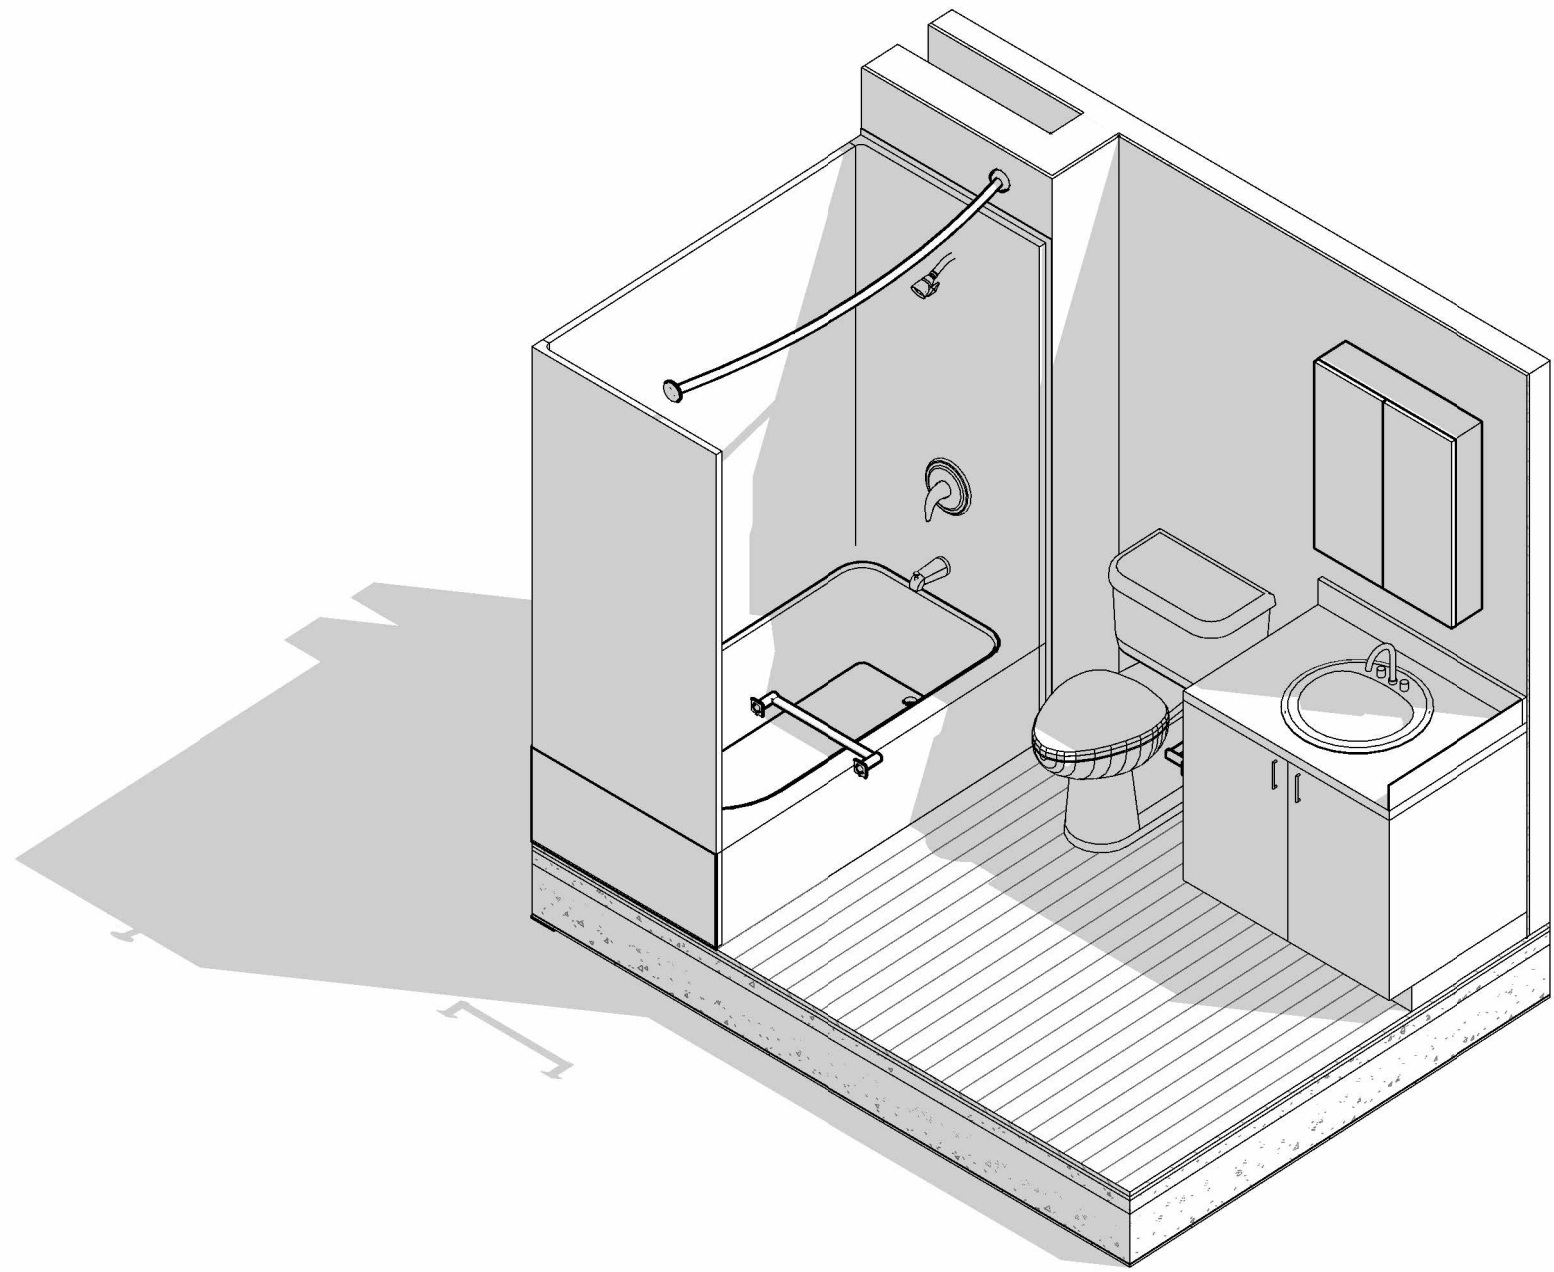


6 3D VIEW BATHROOM 1
A-600

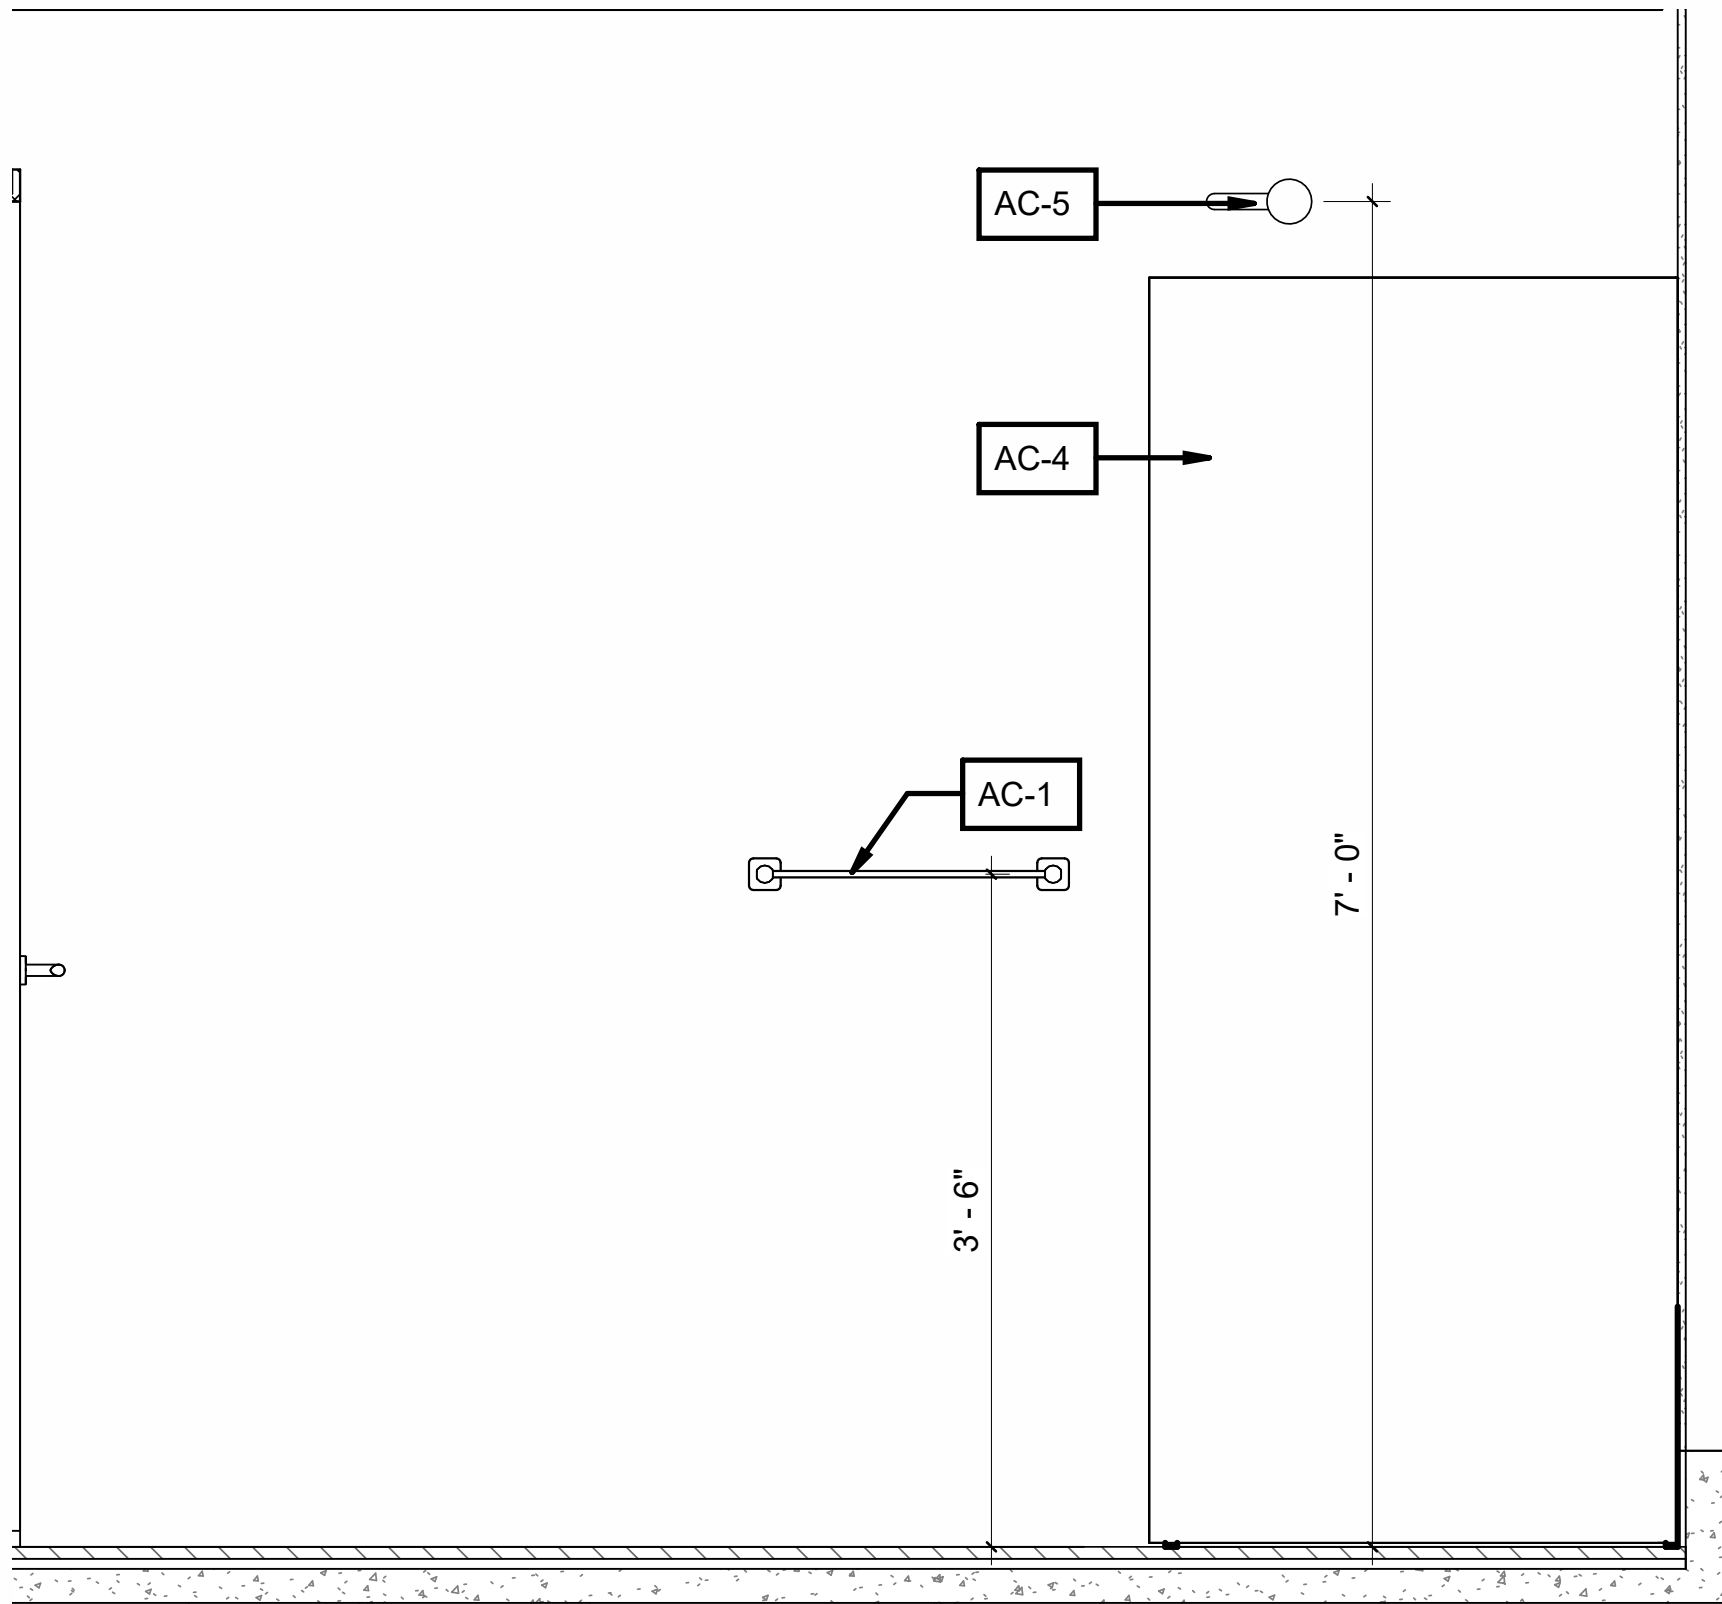


7 Elevation 1 - a
A-600 1" = 1'-0"

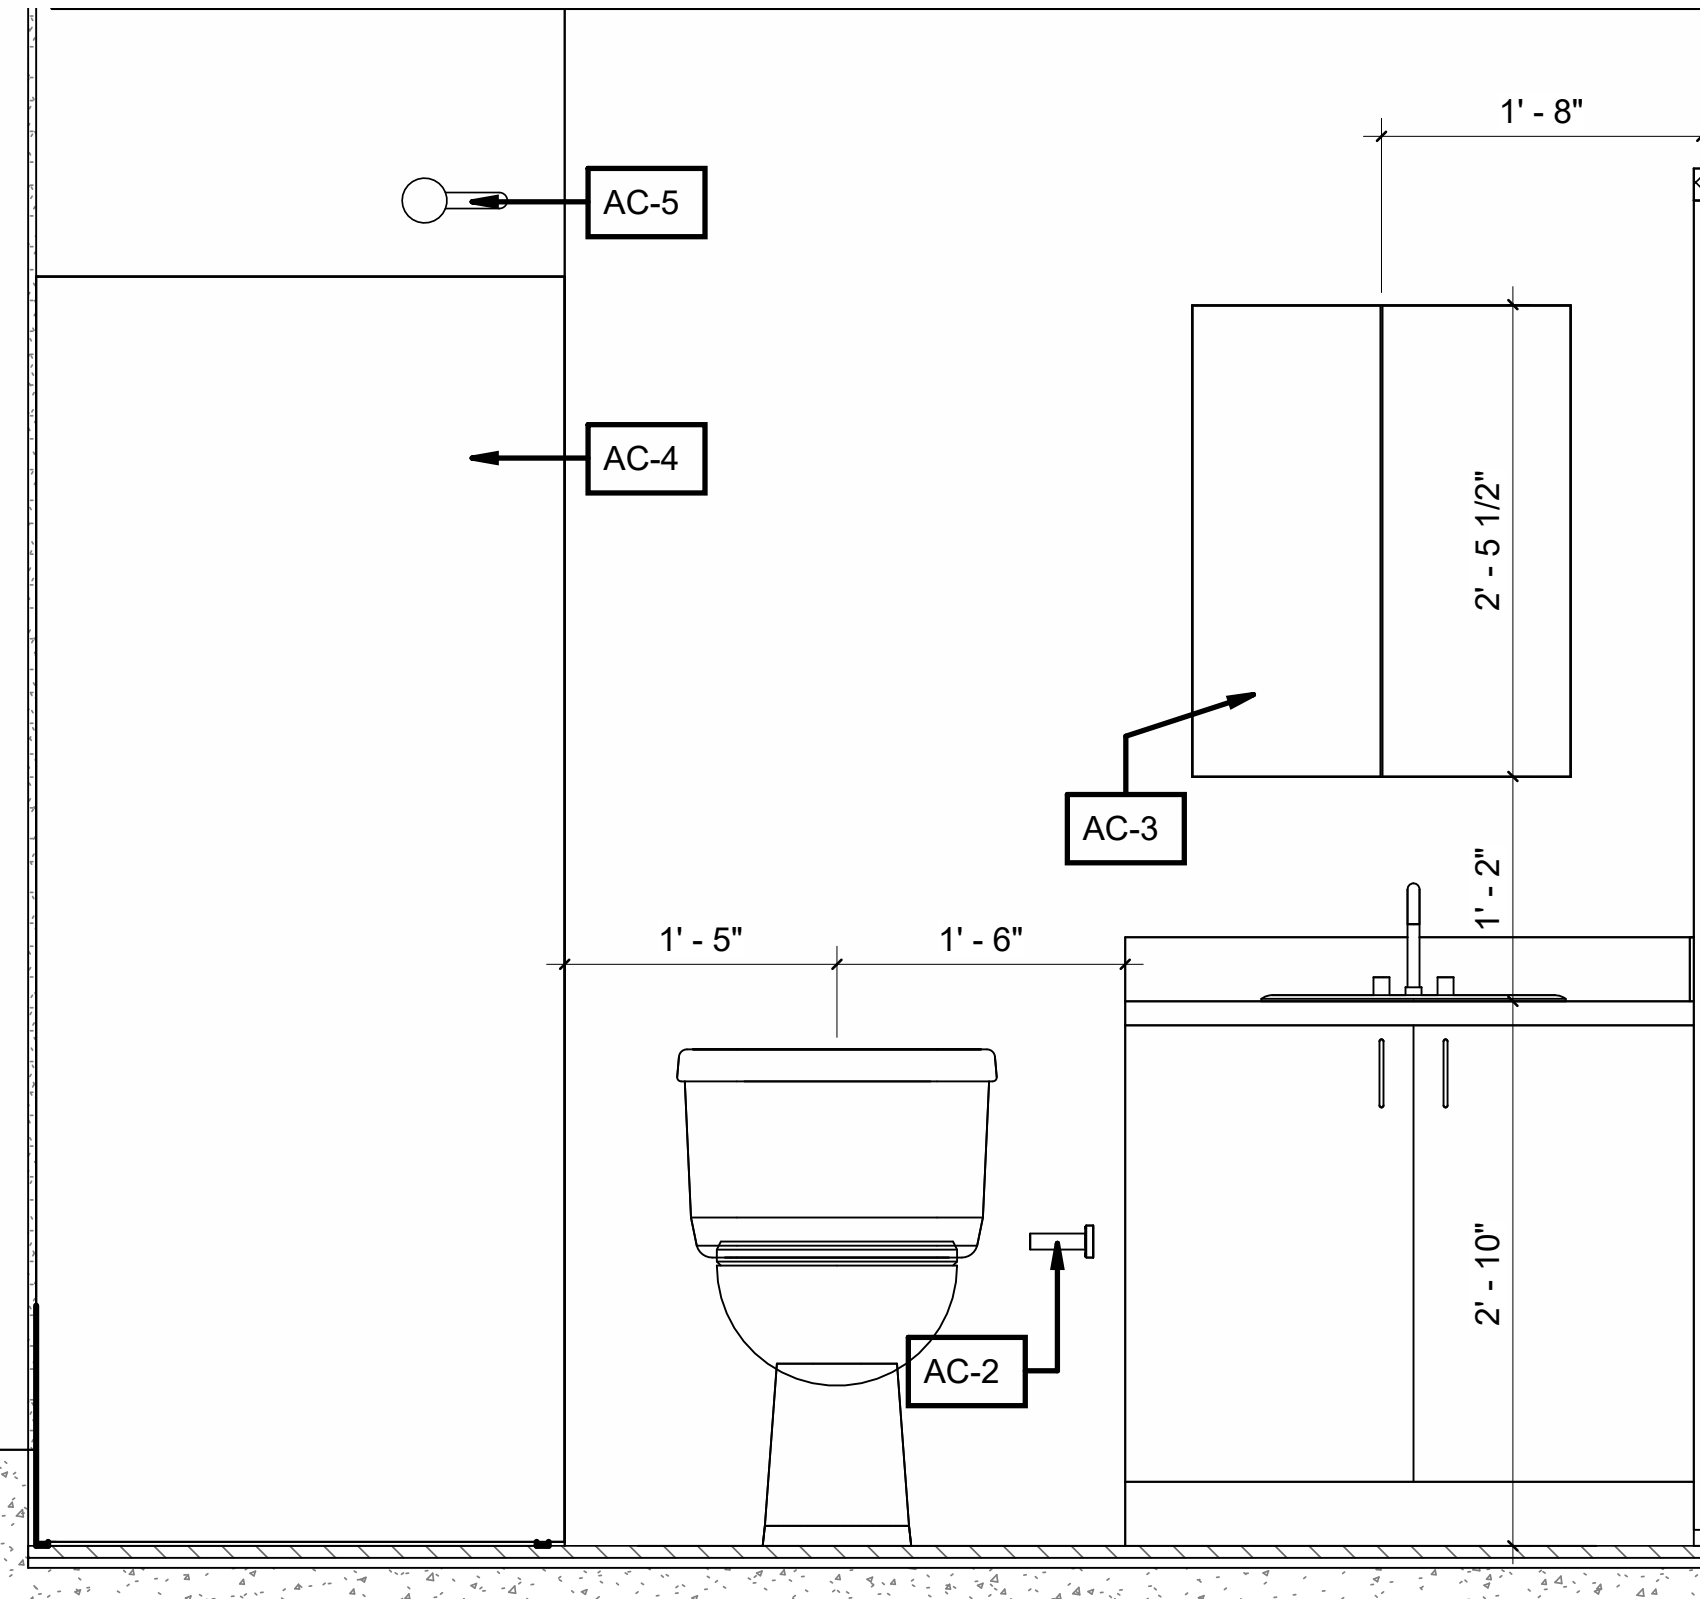

9 Elevation 1 - c
A-600 1" = 1'-0"

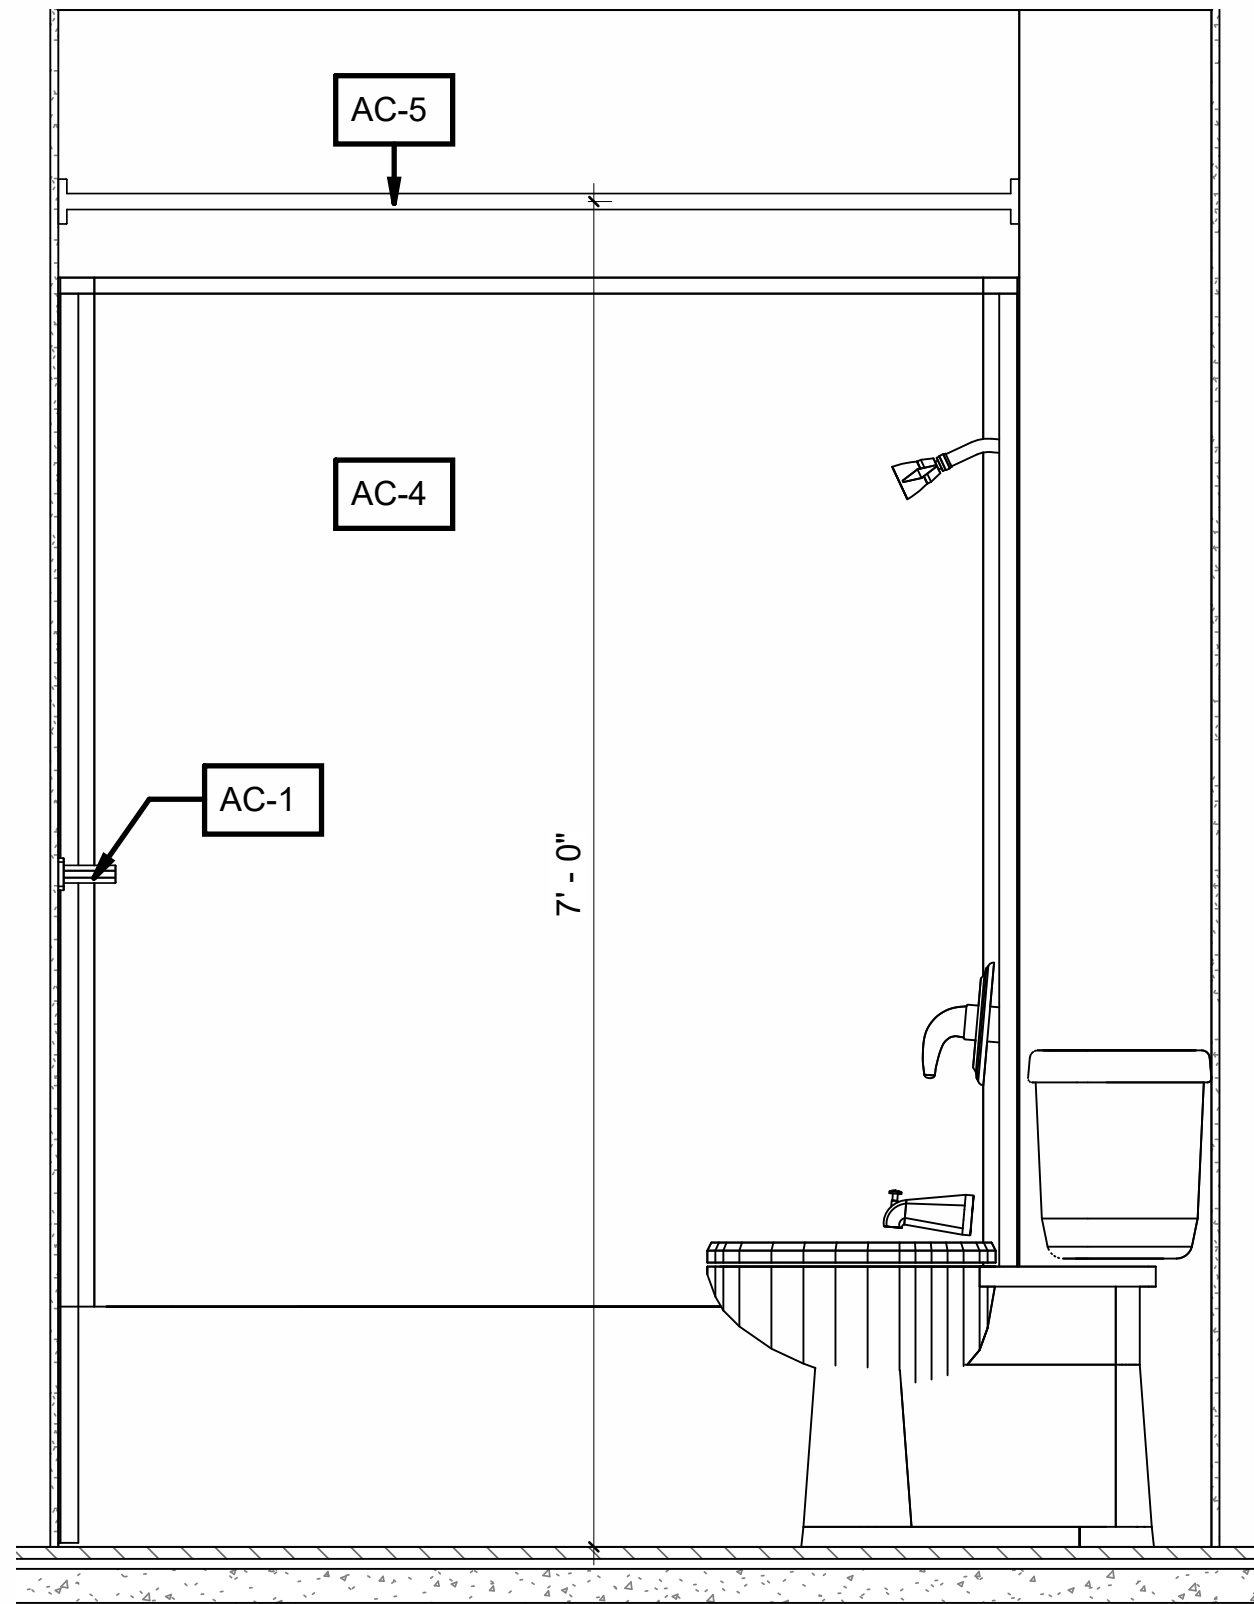

8 Elevation 1 - b
A-600 1" = 1'-0"

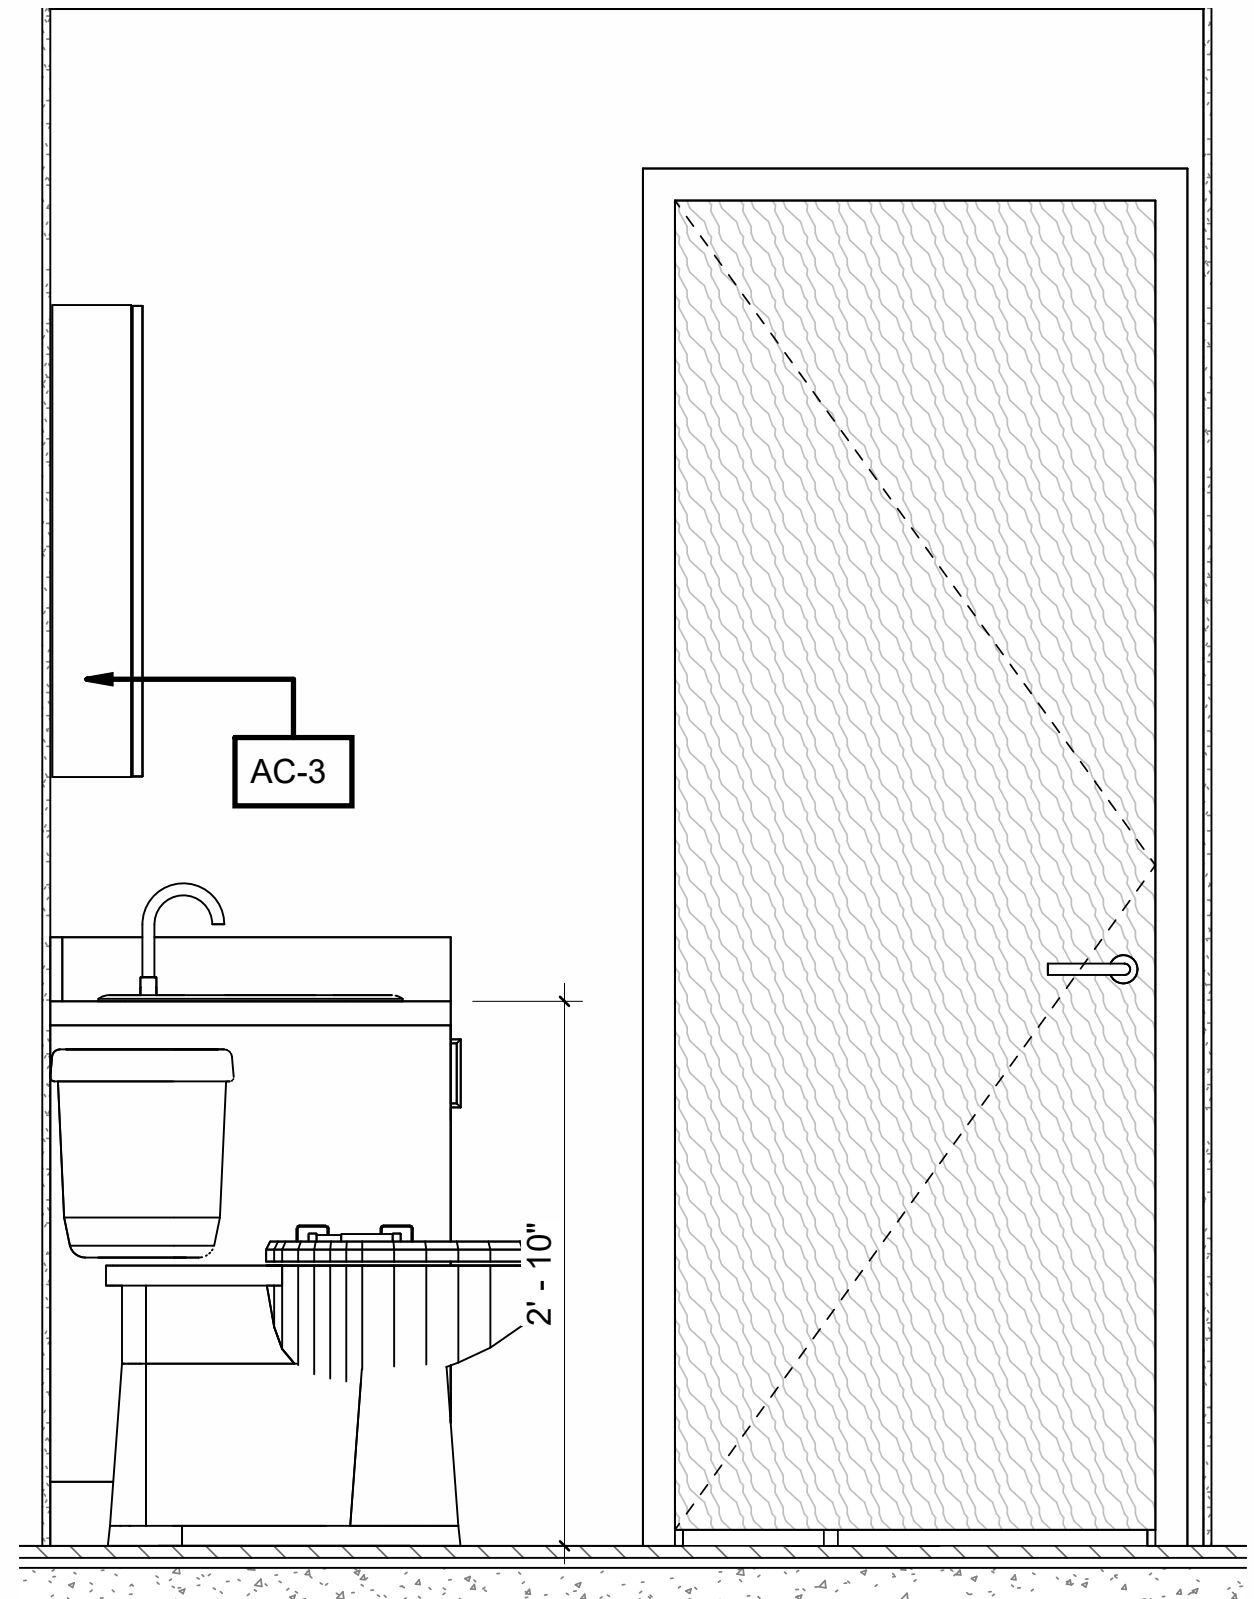

10 Elevation 1 - d
A-600 1" = 1'-0"

GENERAL NOTES:

- SOLID BLOCKING BELOW MIRROR CABINETS, ALL GRAB BARS, TOWEL ROD AND SHOWER FAUCET

VANITY CABINETS NOTES:

- CAULKING BETWEEN VANITY COUNTERS AND WALLS
- CABINETS DOORS AND DRAWERS TO HAVE SOFT CLOSING HARDWARE
- DOOR STYLE: PANELS TO BE FLAT STYLE DOOR
- FRAMING: SOLID WOOD FRAMING AND WOOD VENEER
- FINISH: LAMINATE FINISH
- BACKSPLASH - 4" BACK AND SIDE SPLASH - SAME MATERIAL AS THE COUNTERTOP

6	NP/ MH	Final drawings	11/15/24
5	NP/ MH	For Client Review	08/16/24
4	NP/ MH	For coordination	07/03/24
3	NP/ MH	For Client Review	06/10/24
2	NP/ MH	Review	03/09/24
1	NP/ MH	Review	02/07/24

Iss.	By	Description	Date YY-MM-DD
Issuance Schedule			

Revisions :

All previous issues of this drawing are superseded.



THESE DRAWINGS ARE NOT FOR CONSTRUCTION
NO CONSTRUCTION TO BEGIN UNTIL APPROVAL HAS BEEN GIVEN BY ALL AUTHORITIES HAVING JURISDICTION. A BUILDING PERMIT IS ISSUED AND REVIEWED BY THE ARCHITECT TO CONFIRM COMMENTS MADE BY THE AHJ IN WRITING.

DRAWINGS NOT FOR CONSTRUCTION
Drawings are not for construction until approved permit from the authorities having jurisdiction has been received by the architect and approved in writing.

DRAWINGS ARE NOT TO BE SCALED

Contractor must verify all dimensions on the drawings and report any discrepancies to the architect before proceeding with the work.

All drawings and specifications are instruments of service and the property of the architect, and must be returned at the completion of the work.

OFNTSC - Housing Library

3 BEDROOM - ZONE 2

ENLARGED BATHROOM 1

scale: As indicated
drawn by: NP
reviewed by: MH
job number: 23011
plot date: 11/15/2024
drawing number:

A-600

GENERAL NOTES:

- SOLID BLOCKING BELOW MIRROR
- CABINETS, ALL GRAB BARS, TOWEL ROD AND SHOWER FAUCET

VANITY CABINETS NOTES:

- CAULKING BETWEEN VANITY COUNTERS AND WALLS
- CABINETS DOORS AND DRAWERS TO HAVE SOFT CLOSING HARDWARE
- DOOR STYLE: PANELS TO BE FLAT STYLE DOOR
- FRAMING: SOLID WOOD FRAMING AND WOOD VENEER
- FINISH: LAMINATE FINISH
- BACKSPLASH - 4" BACK AND SIDE SPLASH - SAME MATERIAL AS THE COUNTERTOP

6	NP/ MH	Final drawings	11/15/24
5	NP/ MH	For Client Review	08/16/24
4	NP/ MH	For coordination	07/03/24
3	NP/ MH	For Client Review	06/10/24
2	NP/ MH	Review	03/09/24
1	NP/ MH	Review	02/07/24

Iss.	By	Description	Date YY-MM-DD
Issuance Schedule			

Revisions :
All previous issues of this drawing are superseded.



THESE DRAWINGS ARE NOT FOR CONSTRUCTION
NO CONSTRUCTION TO BEGIN UNTIL APPROVAL HAS BEEN GIVEN BY ALL AUTHORITIES HAVING JURISDICTION. A BUILDING PERMIT IS ISSUED AND REVIEWED BY THE ARCHITECT TO CONFIRM COMMENTS MADE BY THE AHJ IN WRITING.

DRAWINGS NOT FOR CONSTRUCTION
Drawings are not for construction until approved permit from the authorities having jurisdiction has been received by the architect and approved in writing.

DRAWINGS ARE NOT TO BE SCALED

Contractor must verify all dimensions on the drawings and report any discrepancies to the architect before proceeding with the work.

All drawings and specifications are instruments of service and the property of the architect, and must be returned at the completion of the work.

OFNTSC - Housing Library

3 BEDROOM - ZONE 2


ENLARGED BATHROOM 2

scale: As indicated
drawn by: NP
reviewed by: MH
job number: 23011
plot date: 11/15/2024

drawing number:

A-601



2024-11-18 2:42:14 PM

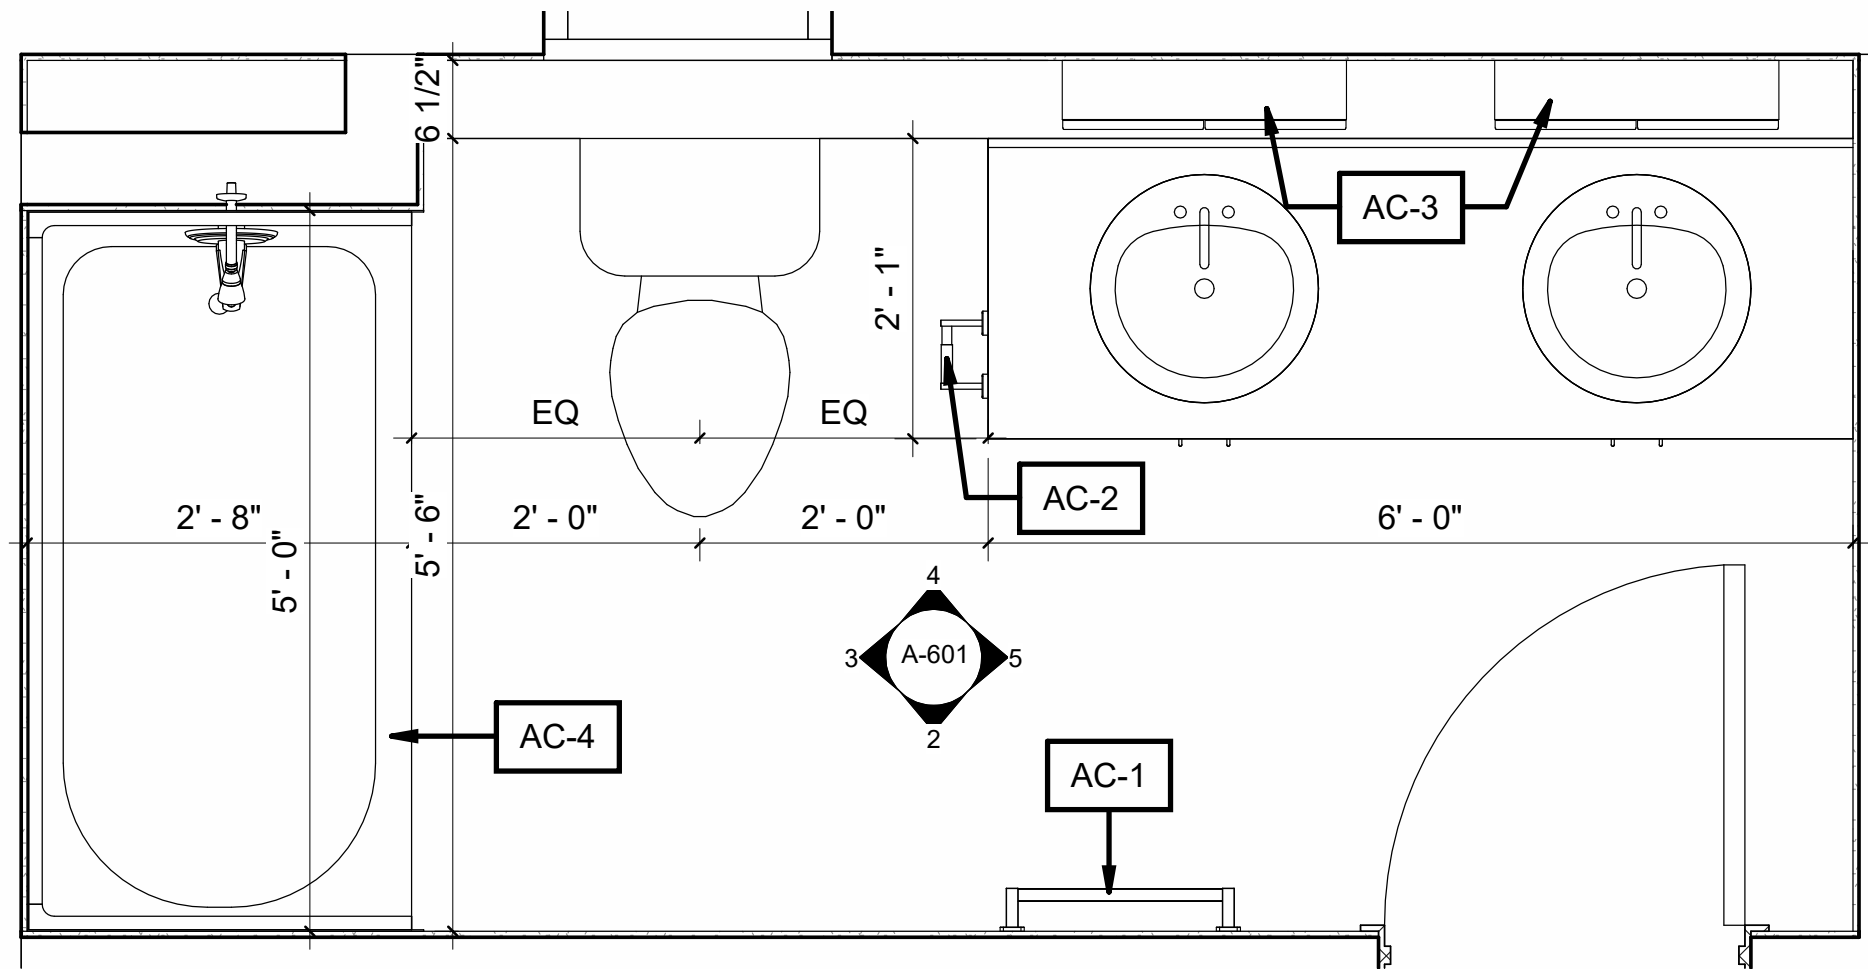


1 BATHROOM 2 ENLARGED PLAN
A-601 3/4" = 1'-0"

WASHROOM ACCESSORIES SCHEDULE


AC-1	TOWEL ROD MANUFACTURER: BOBRICK
AC-2	SURFACE-MOUNTED TOILET TISSUE DISPENSER MANUFACTURER: BOBRICK MODEL: B-685
AC-3	MIRROR CABINETS MANUFACTURER: HOMCOM
AC-4	ONE-PIECE SHOWER MANUFACTURER: MAAX MODEL: CAMELIA TS-6032
AC-5	SHOWER ROD MANUFACTURER: BOBRICK MODEL: S-6047 AND B-204
NOTE: ALL ACCESSORIES SUPPLIED BY CLIENT AND INSTALLED BY G.C.	

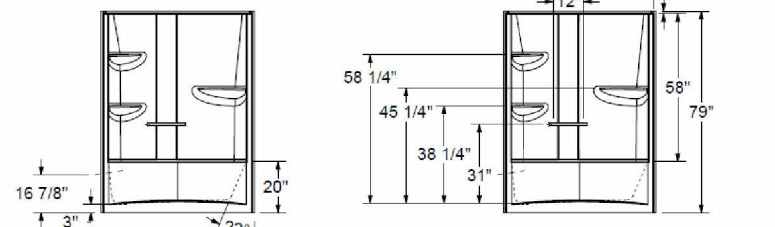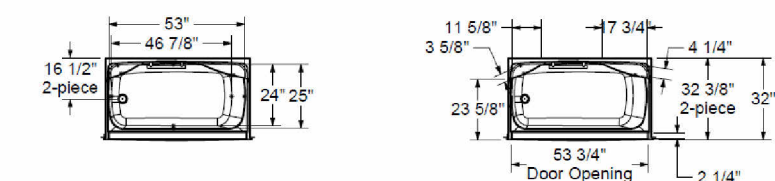


AC-4 - CAMELIA TS-6032 ACRYLIC
ALCOVE ONE-PIECE TUB SHOWER

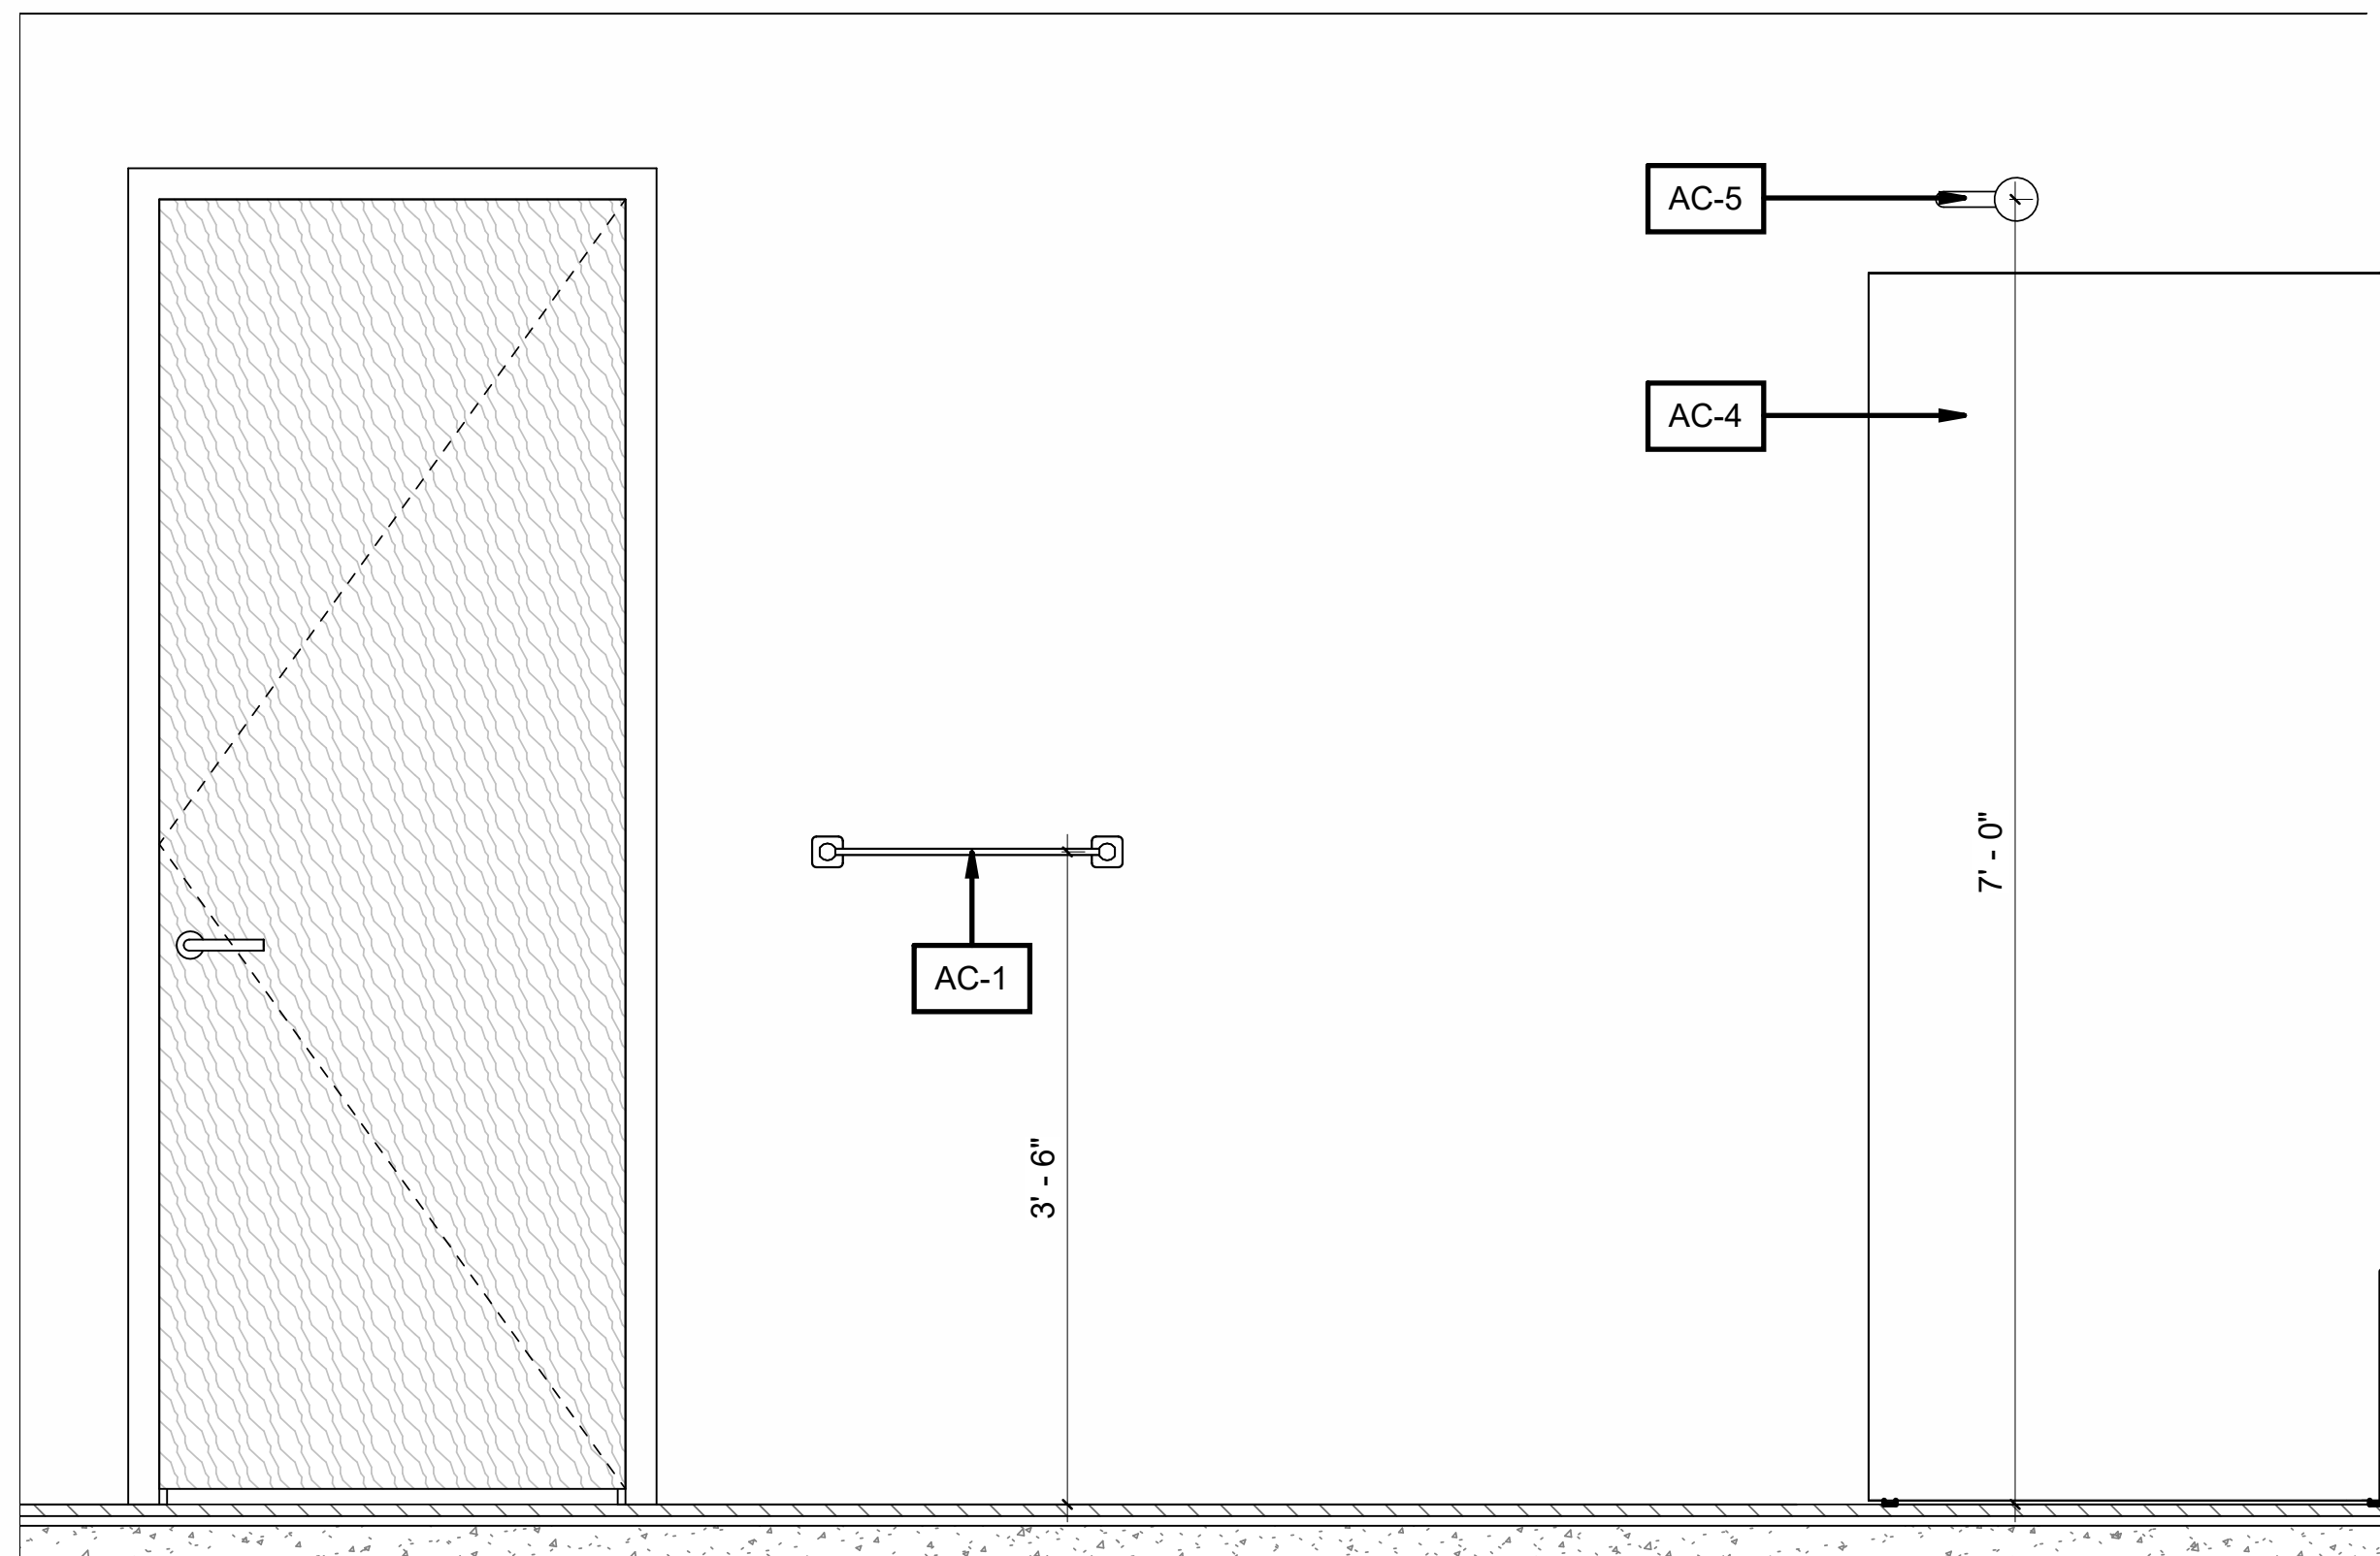


2 Elevation 2 - a
A-601 1" = 1'-0"

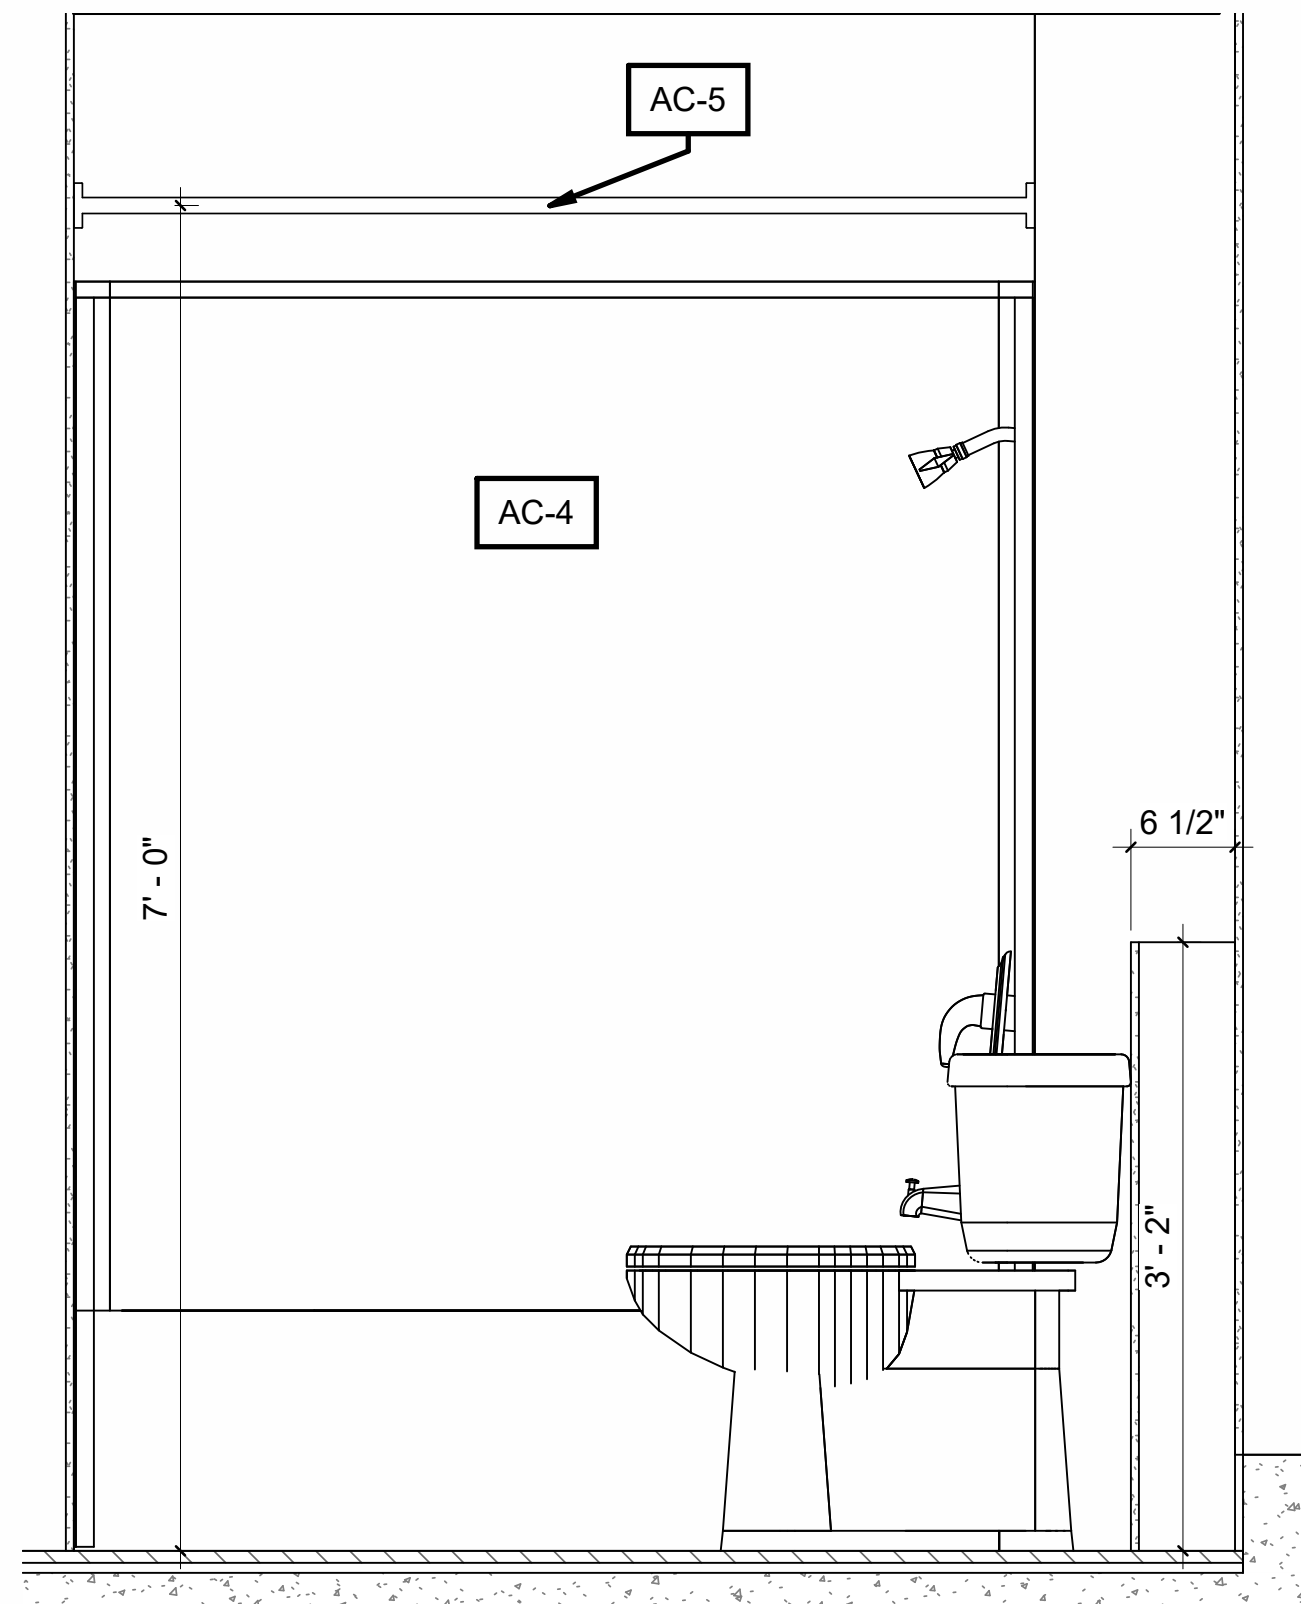

3 Elevation 2 - b
A-601 1" = 1'-0"

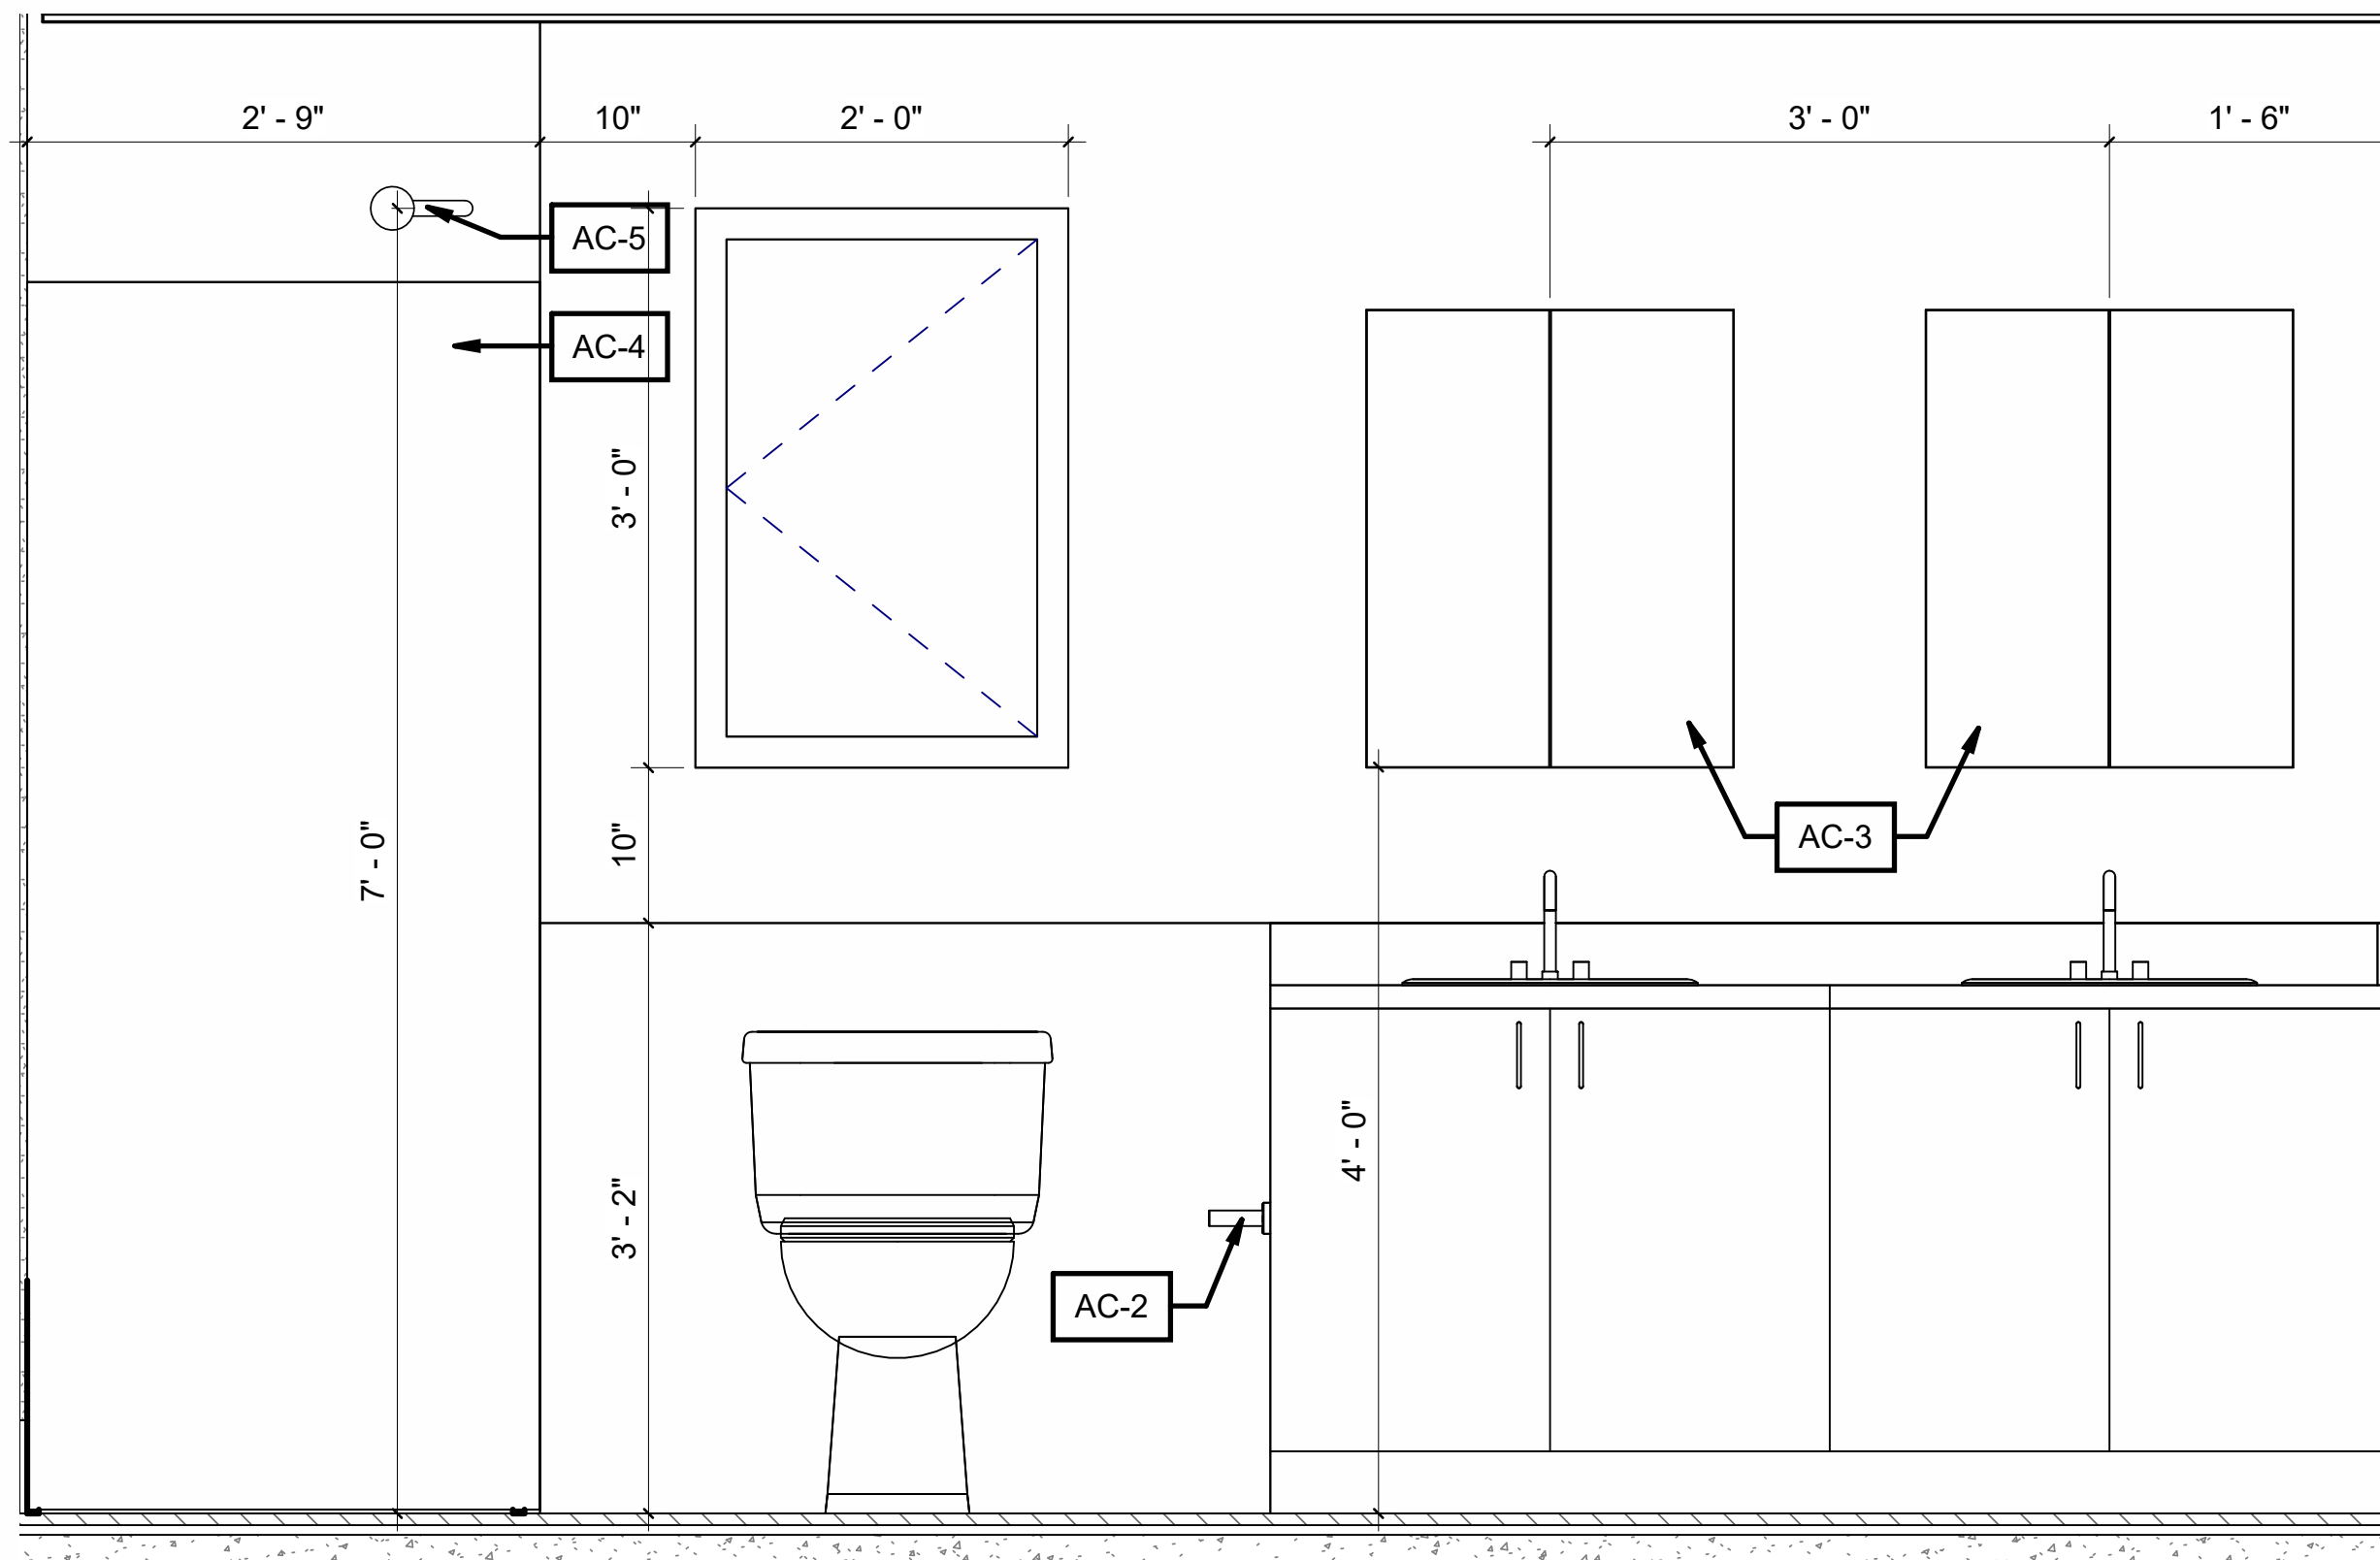


4 Elevation 2 - c
A-601 1" = 1'-0"

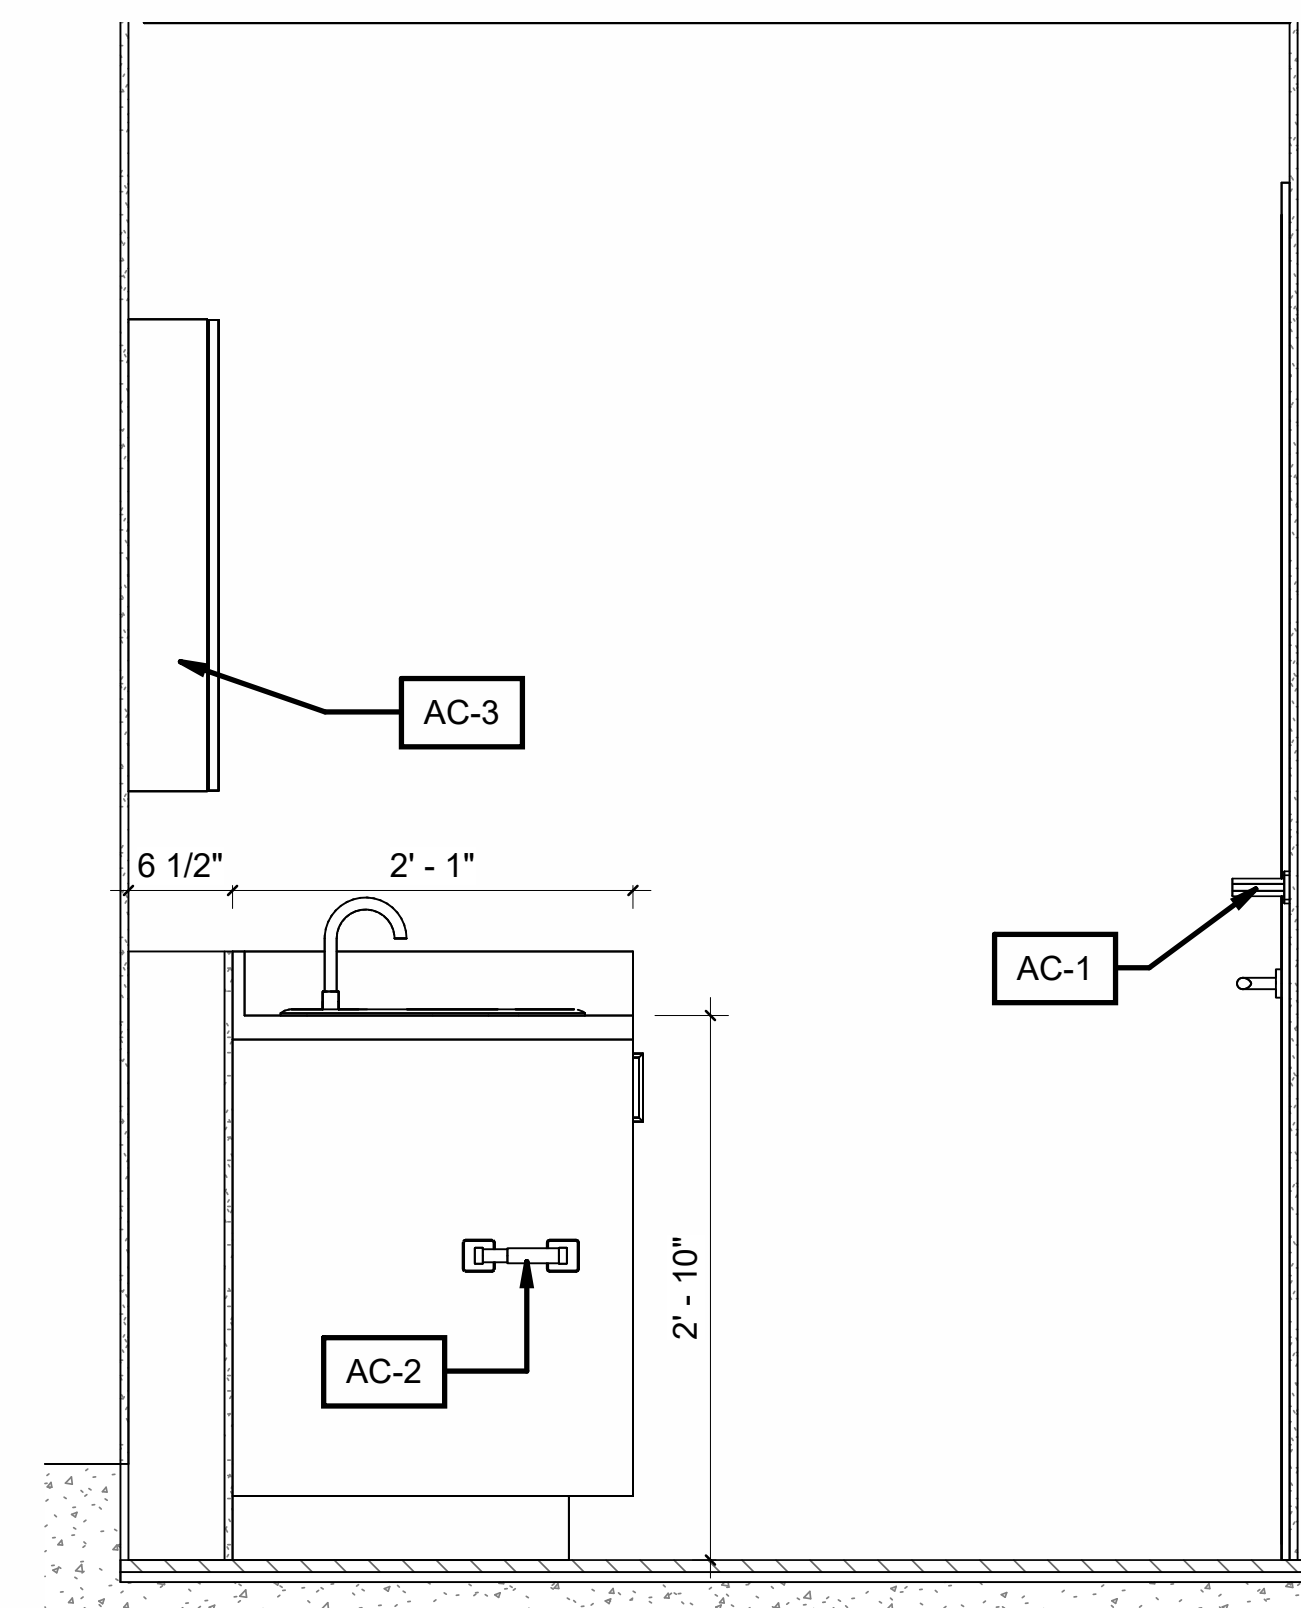

5 Elevation 2 - d
A-601 1" = 1'-0"

6 3D VIEW BATHROOM 2
A-601

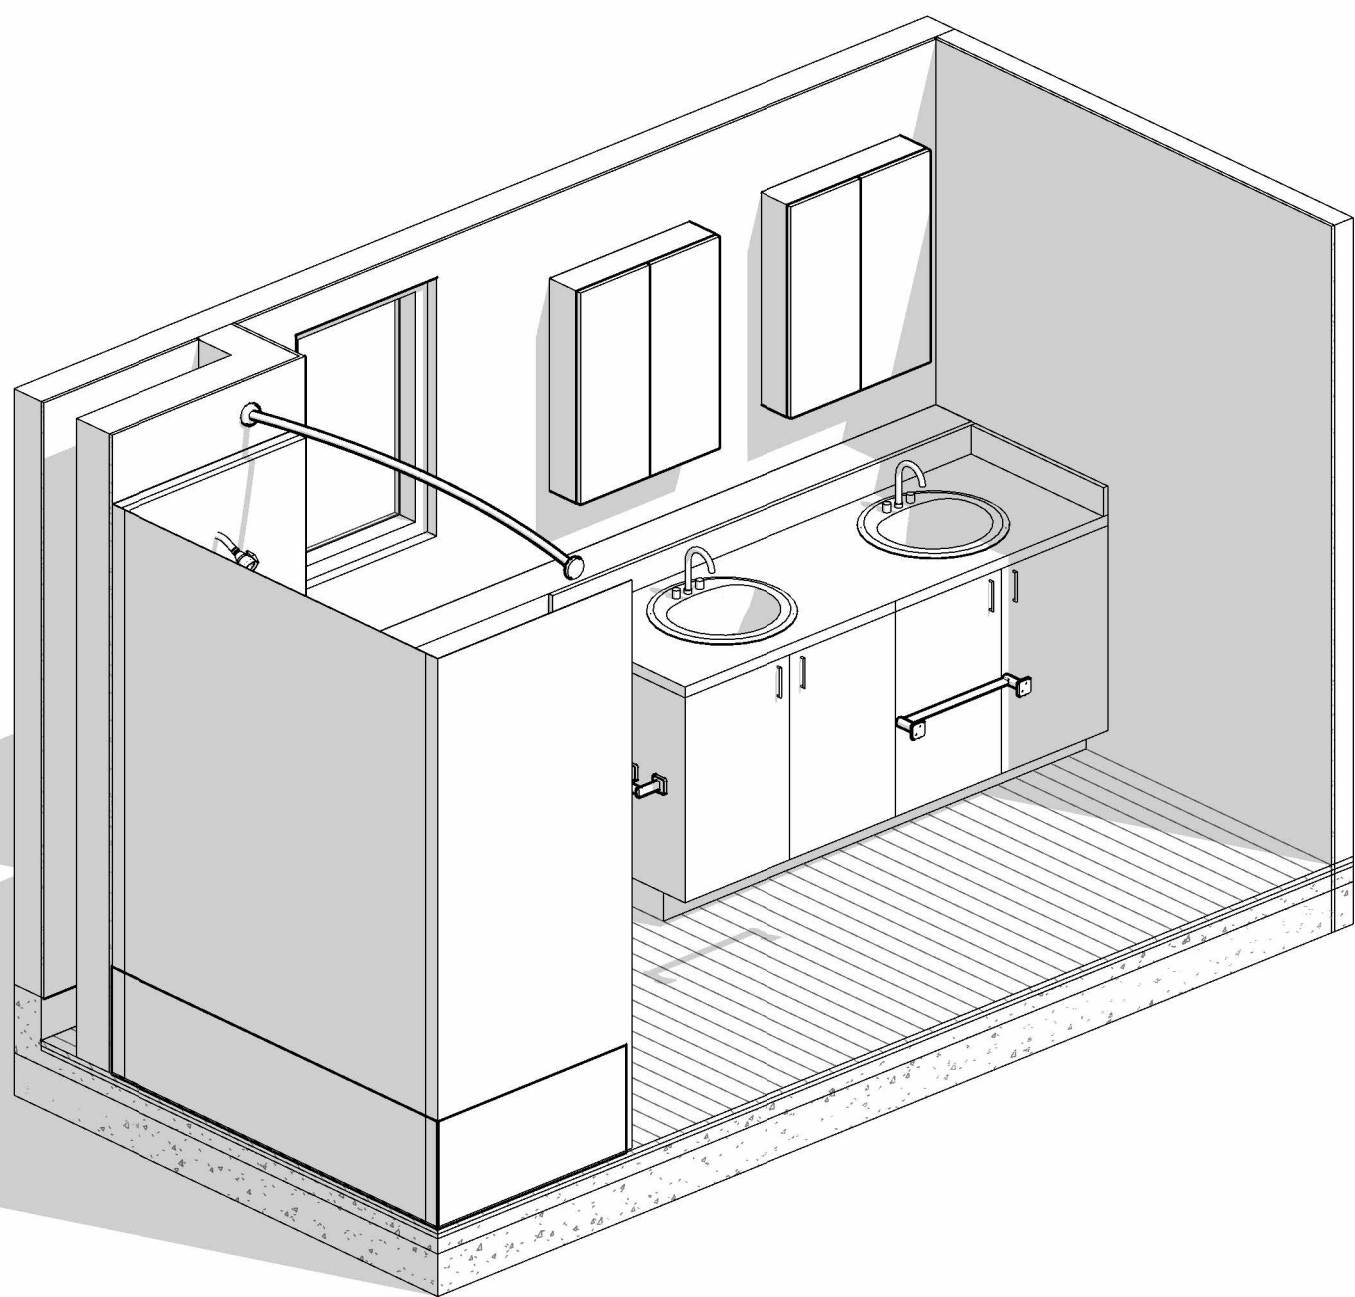

DOOR SCHEDULE										
TYPE	NAME	To Room: Name	DOOR				FRAME		HARDWARE SET	COMMENTS
			WIDTH	HEIGHT	MATERIAL	FINISH	MATERIAL	FINISH		
	D1 TRA_SINGLE_FLUSH_HM	HALLWAY	3'-0"	7'-0"	HM	PAINTED	HM	PAINTED	1	
D1: 1										
	D2 TRA_DOUBLE_FLASHING	CL.	4'-0"	7'-0"	SCW	PAINTED	SCW	PAINTED	2	
D2: 1										
	D3 TRA_SINGLE_FLUSH_SCW	BEDROOM	2'-6"	7'-0"	SCW	PAINTED	SCW	PAINTED	3	
	D3 TRA_SINGLE_FLUSH_SCW	DEN	2'-6"	7'-0"	SCW	PAINTED	SCW	PAINTED	3	
	D3 TRA_SINGLE_FLUSH_SCW	BATHROOM	2'-6"	7'-0"	SCW	PAINTED	SCW	PAINTED	4	
	D3 TRA_SINGLE_FLUSH_SCW	LAUNDRY/MECH.	2'-6"	7'-0"	SCW	PAINTED	SCW	PAINTED	5	
	D3 TRA_SINGLE_FLUSH_SCW	W.I.C.	2'-6"	7'-0"	SCW	PAINTED	SCW	PAINTED	5	
	D3 TRA_SINGLE_FLUSH_SCW	BATHROOM	2'-6"	7'-0"	SCW	PAINTED	SCW	PAINTED	4	
	D3 TRA_SINGLE_FLUSH_SCW	BEDROOM	2'-6"	7'-0"	SCW	PAINTED	SCW	PAINTED	3	
D3: 7										
	D4 TRA_DOUBLE_SLIDING	CL.	4'-0"	7'-0"	SCW	PAINTED	SCW	PAINTED	6	
	D4 TRA_DOUBLE_SLIDING	CL.	4'-0"	7'-0"	SCW	PAINTED	SCW	PAINTED	6	
D4: 2										
	D5 TRA_SINGLE_FLUSH_SCW	LIN.	1'-8"	7'-0"	SCW	PAINTED	SCW	PAINTED	5	
D5: 1										
	D6 TRA_SLIDING_GLASS	DINING/LIVING ROOM	6'-0"	7'-0"	ALUM./GLAZED	ANODIZED BLACK	ALUM.	ANODIZED BLACK	7	
D6: 1										
Grand total: 13										

HARDWARE SCHEDULE

SET #1 (EXTERIOR MAIN ENTRANCE DOOR)

3 EA. HINGES
1 EA. ALUMINUM THRESHOLD
1 EA. DOOR SWEEP
1 EA. WEATHER STRIPPING / SEAL
1 EA. RAIN DRIP CAP
1 EA. STOP
1EA. ENTRY LOCKSET SET

SET #2 (INTERIOR CLOSET DOOR)

2 X 1.5 PR HINGES
2 EA. LEAVER
2 EA. DOOR STOP

SET #3 (INTERIOR BEDROOM DOOR)

1.5 PR HINGES
1 EA. LEAVER
1 EA. PRIVACY SET
1 EA. DOOR STOP

SET #4 (INTERIOR BATHROOM)

1.5 PR HINGES
1 EA. LEAVER
1 EA. PRIVACY SET
1 EA. DOOR STOP

SET #5 (INTERIOR LAUNDRY/MECH; W.I.C.; LIN. DOOR)

1.5 PR HINGES
1 EA. LEAVER
1 EA. DOOR STOP

SET #6 (INTERIOR CLOSET SLIDING DOOR)

SLIDING DOOR SET



SET #7 (EXTERIOR TERRACE SLIDING GLASD ENTRANCE DOOR)

SLIDING DOOR SET
1 EA. ALUMINUM THRESHOLD
1 EA. DOOR SWEEP
1 EA. WEATHER STRIPPING / SEAL
1 EA. RAIN DRIP CAP
1 EA. PRIVACY SET

DOOR SCHEDULE NOTES

- DO NOT SCALE DRAWINGS.
- ALL MATERIAL AND WORKMANSHIP SHALL COMPLY WITH ALL APPLICABLE CANADIAN CONSTRUCTION STANDARDS AND THE ONTARIO BUILDING CODE (2012).
- OVERALL DIMENSIONS PROVIDED FOR DOOR SCHEDULE ARE ROUGH-OPENING SIZES.
- OVERALL FRAME DIMENSIONS SHALL BE SIZED ACCORDINGLY.
- THE CONTRACTOR SHALL SITE VERIFY ALL DIMENSIONS AND EXISTING CONDITIONS ON SITE AND SHALL REPORT ALL DISCREPANCIES TO THE CONSULTANT PRIOR TO DOOR FABRICATION.
- GENERAL CONTRACTOR TO PROVIDE SHOP DRAWINGS FOR ALL DOORS AS FOLLOWS:
 - FINISH HARDWARE SCHEDULE PREPARED BY AN ARCHITECTURAL HARDWARE CONSULTANT (AHC), IN VERTICAL FORMAT TO DHI SEQUENCE AND FORMAT FOR THE HARDWARE SCHEDULE.
 - KEYING SCHEDULE PREPARED BY AN ARCHITECTURAL HARDWARE CONSULTANT (AHC), TO DHI KEYING SYSTEMS AND NOMENCLATURE, INCLUDING ALL SPECIAL KEYING NOTES AND STAMPING INSTRUCTIONS.
 - WIRING DIAGRAMS, INCLUDING A WRITTEN DESCRIPTION OF THE FUNCTIONAL USE OF ALL ELECTRICAL HARDWARE, INCLUDE DOOR AND FRAME ELEVATIONS SHOWING THE LOCATION OF EACH ITEM OF ELECTRICAL HARDWARE TO BE INSTALLED, INCLUDING A DIAGRAM SHOWING NUMBER AND SIZE OF ALL CONDUCTORS.
 - PROVIDE ALL APPLICABLE CLOSURE TRIM TO OPENINGS AS REQUIRED. COLOUR OF TRIM TO MATCH COLOUR OF DOOR FRAMES.
 - PROVIDE SEALANT AROUND DOOR FRAMES INSIDE AND OUT. SEALANT COLOUR TO MATCH COLOUR OF FRAMES.
 - COORDINATE WITH OWNER KEYING OF ALL DOORS.
 - DOOR HARDWARE SUPPLIER IS RESPONSIBLE FOR SUPPLYING & INSTALLING ALL DOOR HARDWARE.
 - ALL HARDWARE IS TO BE LEVER STYLE.
 - ALL INTERIOR HARDWARE IS TO BE BRUSHED NICKEL FINISH.
 - CONFIRM ALL HARDWARE PRIOR TO CONSTRUCTION.
 - ALL QUANTITIES TO BE CONFIRMED BY CONTRACTOR PRIOR TO CONSTRUCTION.


DOOR TYPES

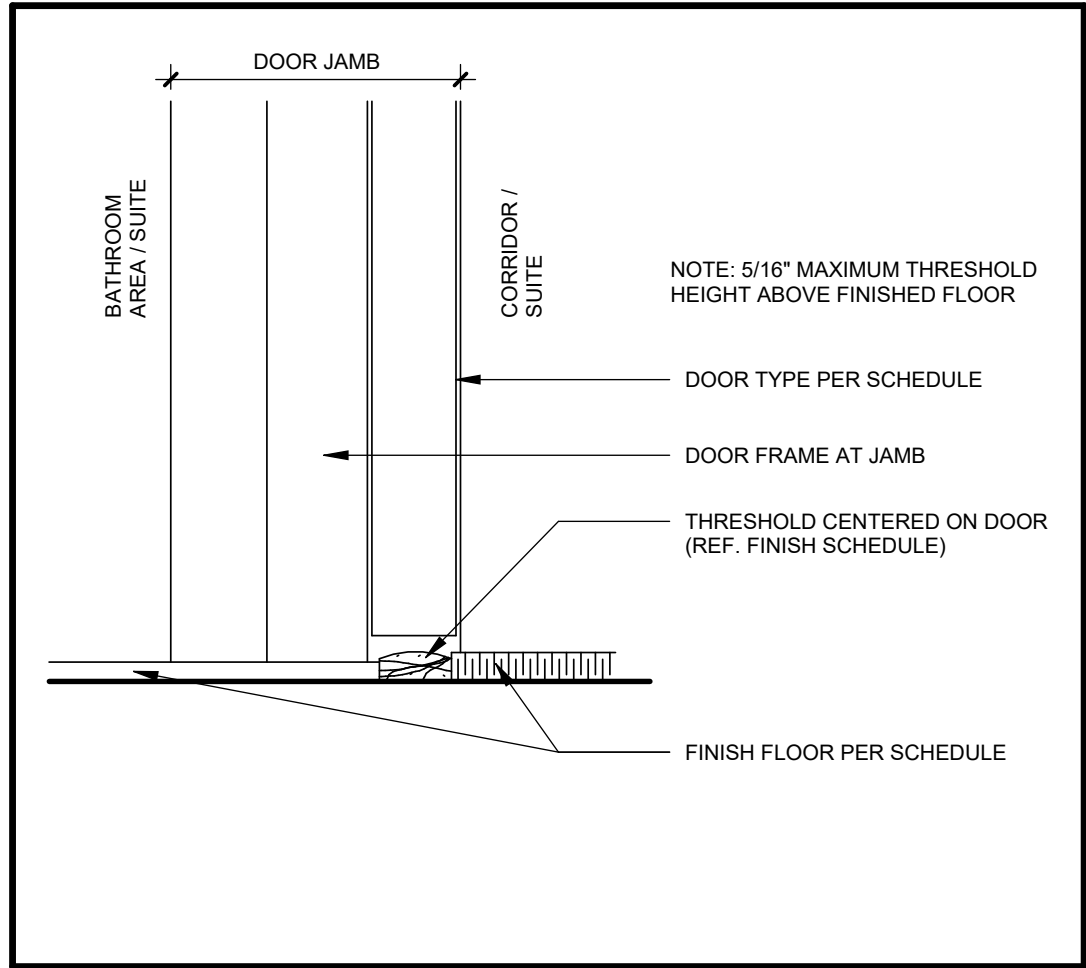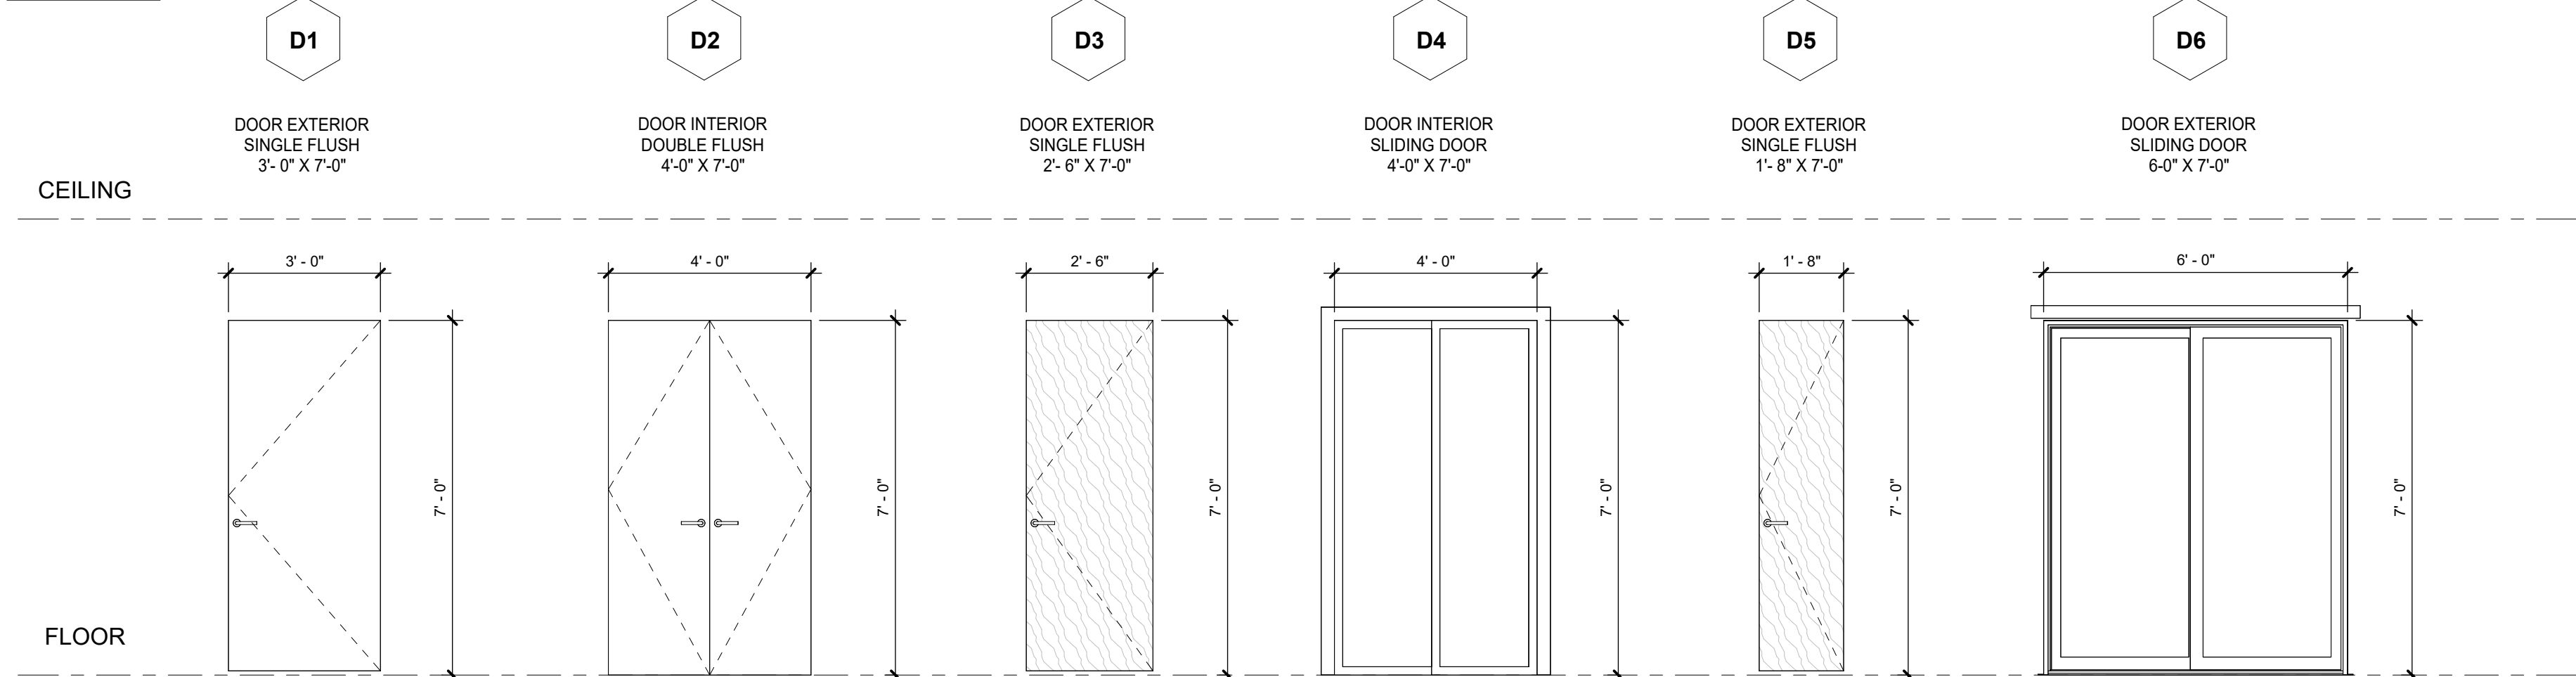

2 DOOR THRESHOLD DETAIL
A-700 3" = 1'-0"

WINDOW SCHEDULE				
TYPE	NAME	WIDTH	HEIGHT	COMMENTS
A	TRA_2_SECTION_1 OPENABLE	4'-6"	5'-0"	
A	TRA_2_SECTION_1 OPENABLE	4'-6"	5'-0"	
A	TRA_2_SECTION_1 OPENABLE	4'-6"	5'-0"	
A	TRA_2_SECTION_1 OPENABLE	4'-6"	5'-0"	
A	TRA_2_SECTION_1 OPENABLE	4'-6"	5'-0"	
A: 5				
B	TRA_1_SECTION	3'-0"	4'-0"	
B	TRA_1_SECTION	3'-0"	4'-0"	
B	TRA_1_SECTION	3'-0"	4'-0"	
B	TRA_1_SECTION	3'-0"	4'-0"	
B	TRA_1_SECTION	3'-0"	4'-0"	
B: 5				
C	TRA_1_SECTION	2'-0"	3'-0"	
C: 1				
Grand total: 11				

WINDOW TYPES

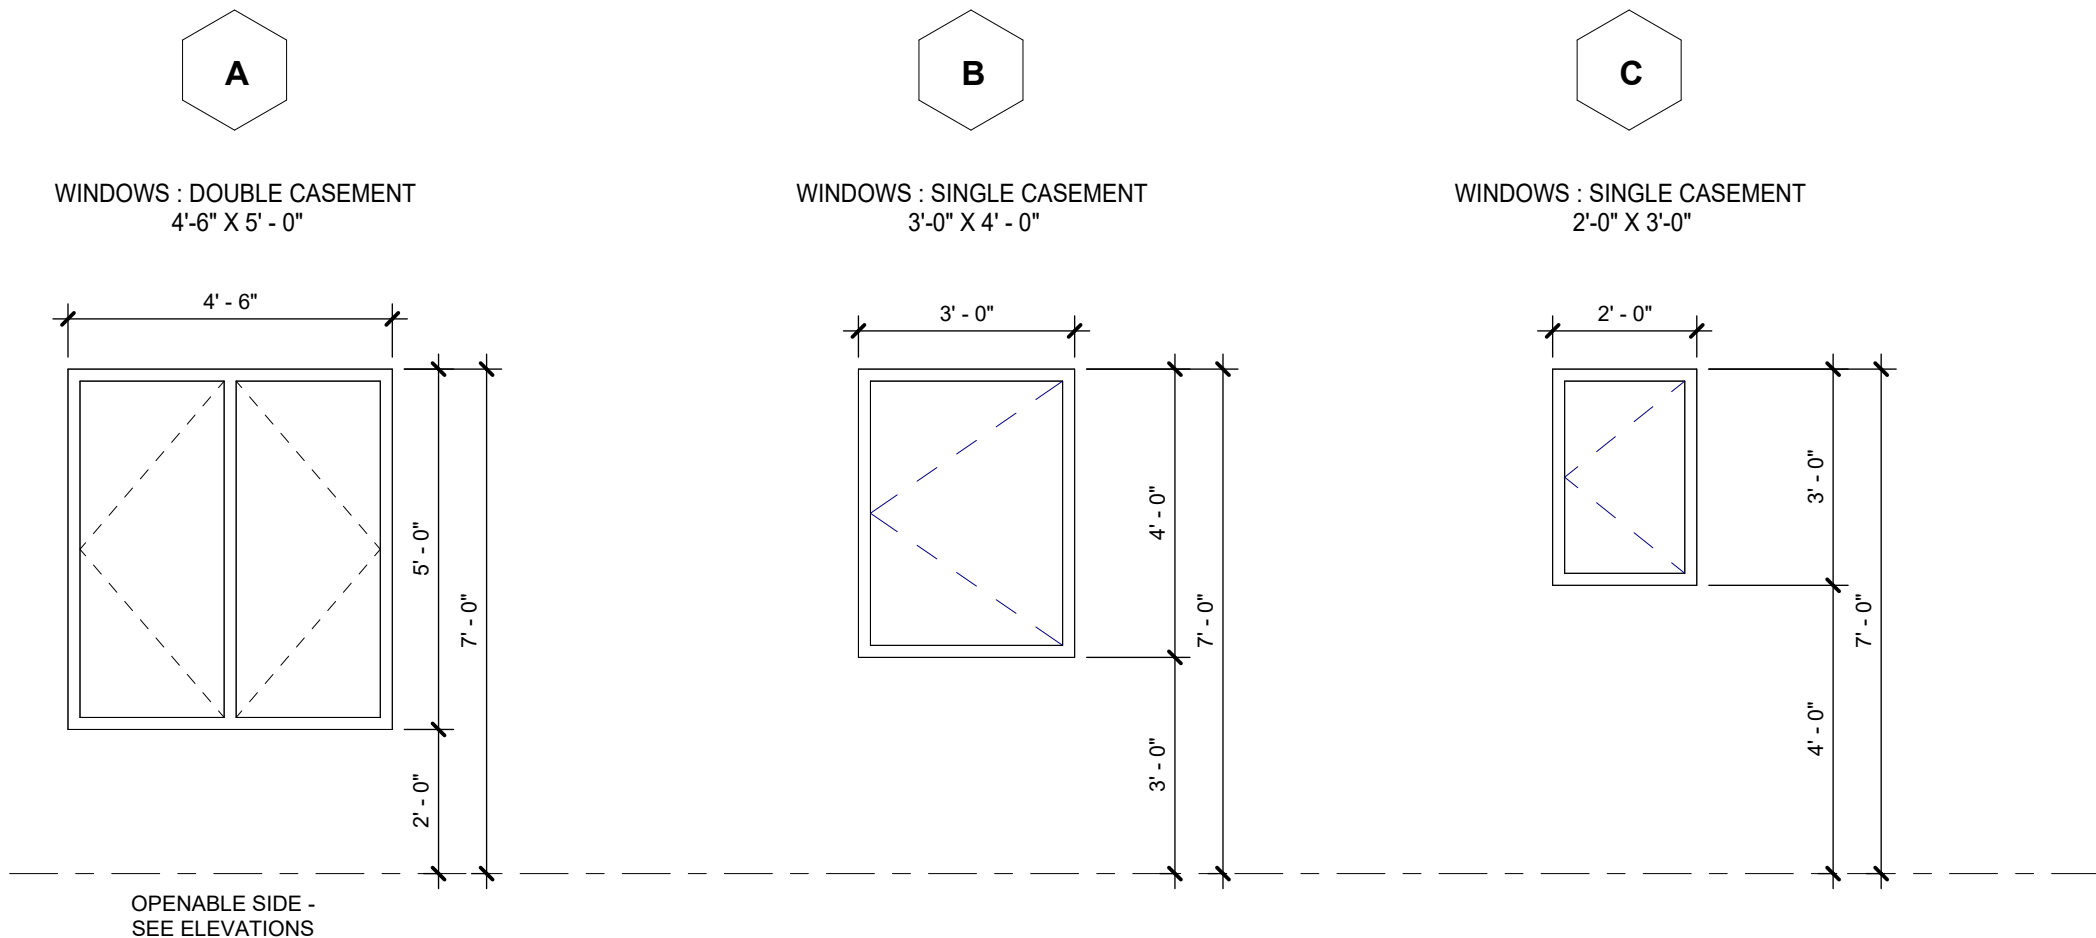

WINDOW NOTES:

- ALL WINDOWS TO BE THERMALLY BROKEN WITH LOW-E DOUBLE GLAZED
- DARK GREY VINYL FRAME
- WINDOWS TO BE DOUBLE PANE ENERGY STAR RATED, ARGON FILLED
- FIELD CONFIRM ALL DIMENSIONS FOR ALL SCREENS (TYP.)
- DIMENSIONS SHOWN ARE PROPOSED FINISHED OPENINGS
- WINDOW SUPPLIER AND FRAMER TO COORDINATE SIZE OF ROUGH OPENING.
- WINDOW SUPPLIER TO CONFIRM SIZE OF OPENING ON SITE BEFORE MFG

SHOP DRAWING NOTE:


- OWNER / CONTRACTOR TO ENSURE SHOP DRAWING SUBMITTALS ARE PREPARED BY SYSTEMS DESIGNER (WALL, FLOOR, STAIR, WINDOW, DOOR ETC.)
- CONTRACTOR TO REVIEW AND APPROVE THE ABOVE MENTIONED SHOP DRAWINGS PRIOR TO SUBMISSION TO THE ARCHITECT. PLANS / DRAWINGS SHOWN ARE FOR REFERENCE AND DESIGN INTENT ONLY AND ARE NOT INTENDED FOR FABRICATION - TYP.

6	NP/ MH	Final drawings	11/15/24
5	NP/ MH	For Client Review	08/16/24
4	NP/ MH	For coordination	07/03/24
3	NP/ MH	For Client Review	06/10/24
2	NP/ MH	Review	03/09/24
1	NP/ MH	Review	02/07/24

Iss.	By	Description	Date YY-MM-DD
Issuance Schedule			

Revisions :

All previous issues of this drawing are superseded.

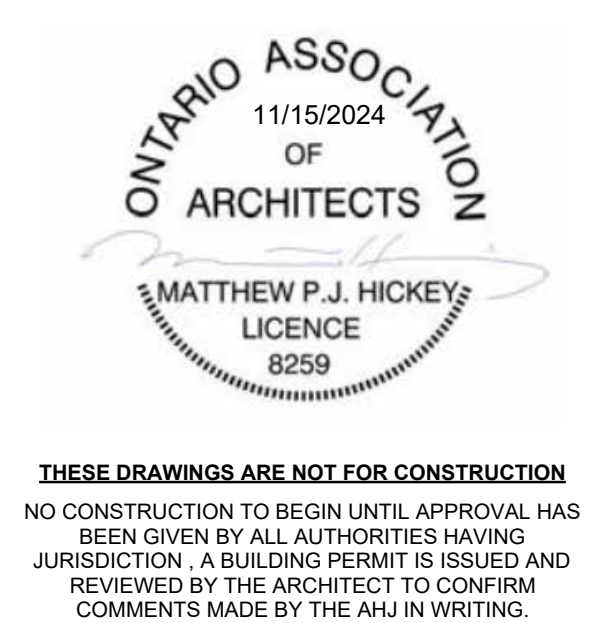

DRAWINGS NOT FOR CONSTRUCTION

Drawings are not for construction until approved permit from the authorities having jurisdiction has been received by the architect and approved in writing.

DRAWINGS ARE NOT TO BE SCALED

Contractor must verify all dimensions on the drawings and report any discrepancies to the architect before proceeding with the work.

All drawings and specifications are instruments of service and the property of the architect, and must be returned at the completion of the work.

OFNTSC - Housing Library

3 BEDROOM - ZONE 2

DOOR & WINDOW SCHEDULE

scale: As indicated
drawn by: NP
reviewed by: MH
job number: 23011
plot date: 11/15/2024

drawing number:

A-700

2024-11-18 2:42:15 PM



P.O. Box 77 • 1804 6th Line • Chertswood Rd. Chertswood, ON, NOA 1M0
519.445.2137 www.tworow.com info@tworow.com

6	NP/ MH	Final drawings	11/15/24
5	NP/ MH	For Client Review	08/16/24
4	NP/ MH	For coordination	07/03/24
3	NP/ MH	For Client Review	06/10/24
2	NP/ MH	Review	03/09/24
1	NP/ MH	Review	02/07/24

Iss.	By	Description	Date YY-MM-DD
------	----	-------------	------------------

Issuance Schedule

Revisions :

All previous issues of this drawing are superseded.



THESE DRAWINGS ARE NOT FOR CONSTRUCTION
NO CONSTRUCTION TO BEGIN UNTIL APPROVAL HAS BEEN GIVEN BY ALL AUTHORITIES HAVING JURISDICTION. A BUILDING PERMIT IS ISSUED AND REVIEWED BY THE ARCHITECT TO CONFIRM COMMENTS MADE BY THE AHJ IN WRITING.

DRAWINGS NOT FOR CONSTRUCTION

Drawings are not for construction until approved permit from the authorities having jurisdiction has been received by the architect and approved in writing.

DRAWINGS ARE NOT TO BE SCALED

Contractor must verify all dimensions on the drawings and report any discrepancies to the architect before proceeding with the work.

All drawings and specifications are instruments of service and the property of the architect, and must be returned at the completion of the work.

OFNTSC - Housing Library

3 BEDROOM - ZONE 2

RENDERINGS


scale:

drawn by: NP
reviewed by: MH
job number: 23011
plot date: 11/15/2024


drawing number:

A-800

2024-11-18 2:42:16 PM

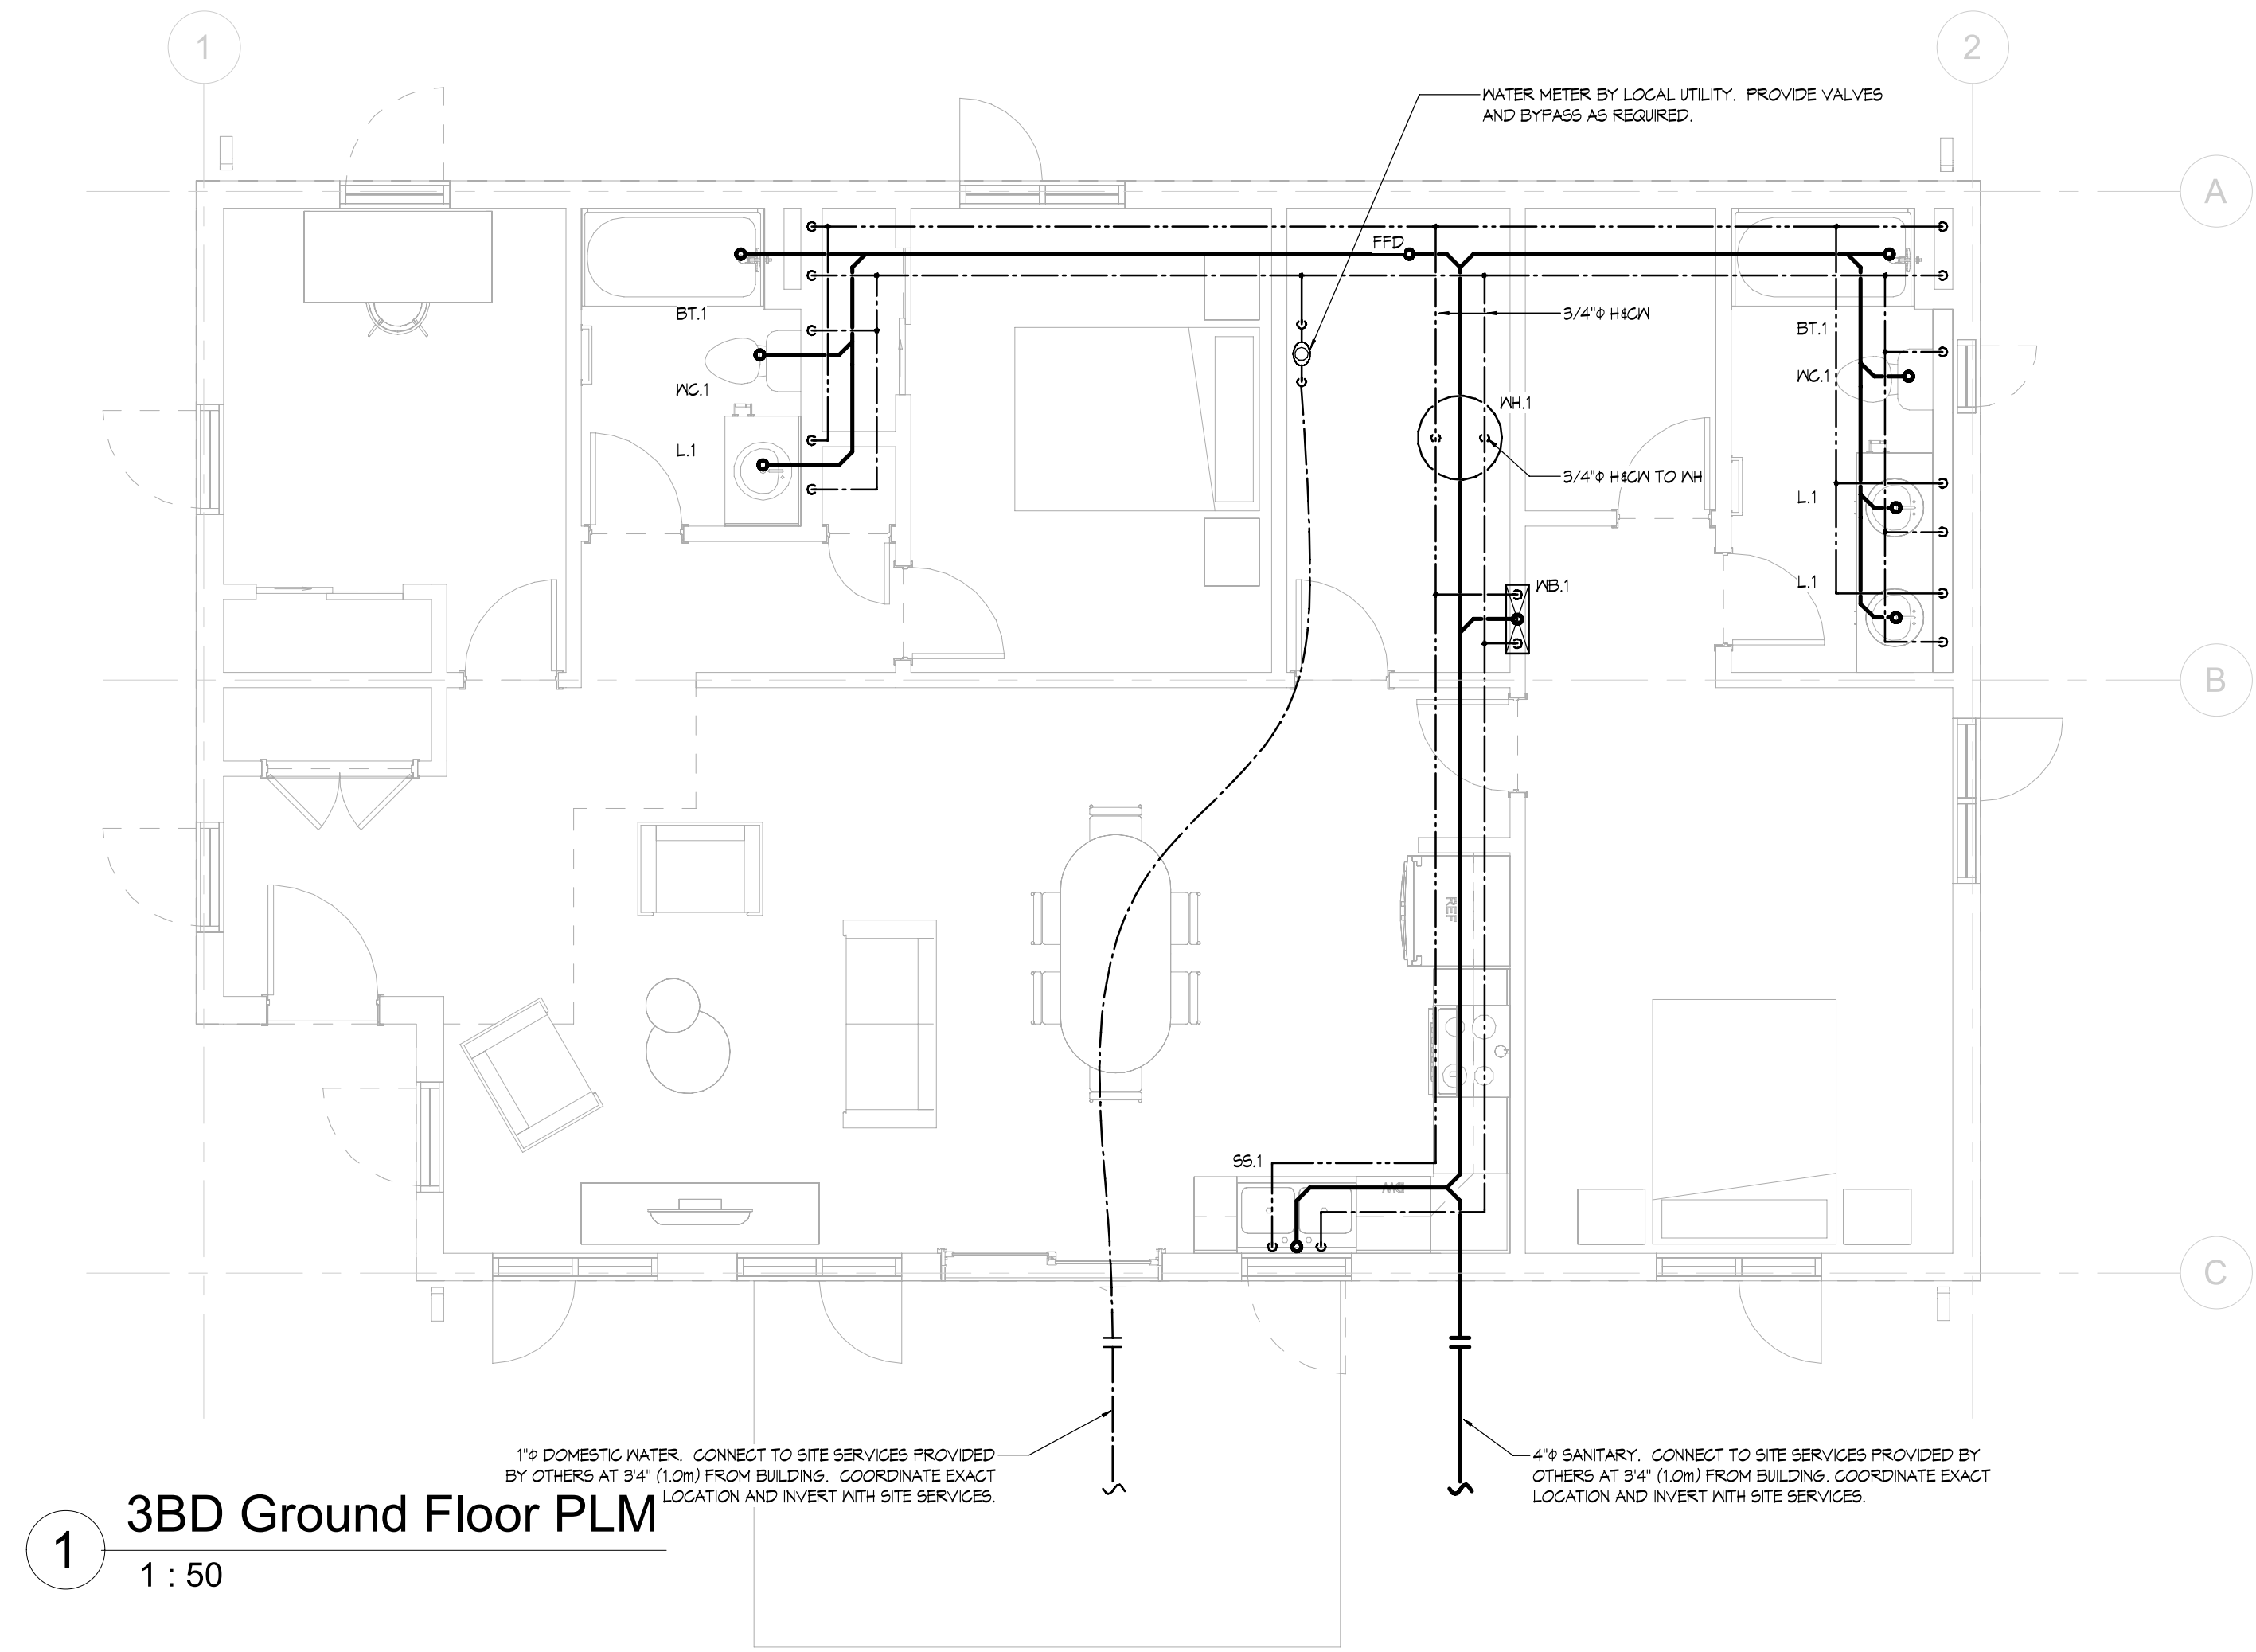

1 3BD Ground Floor PLM
1 : 50

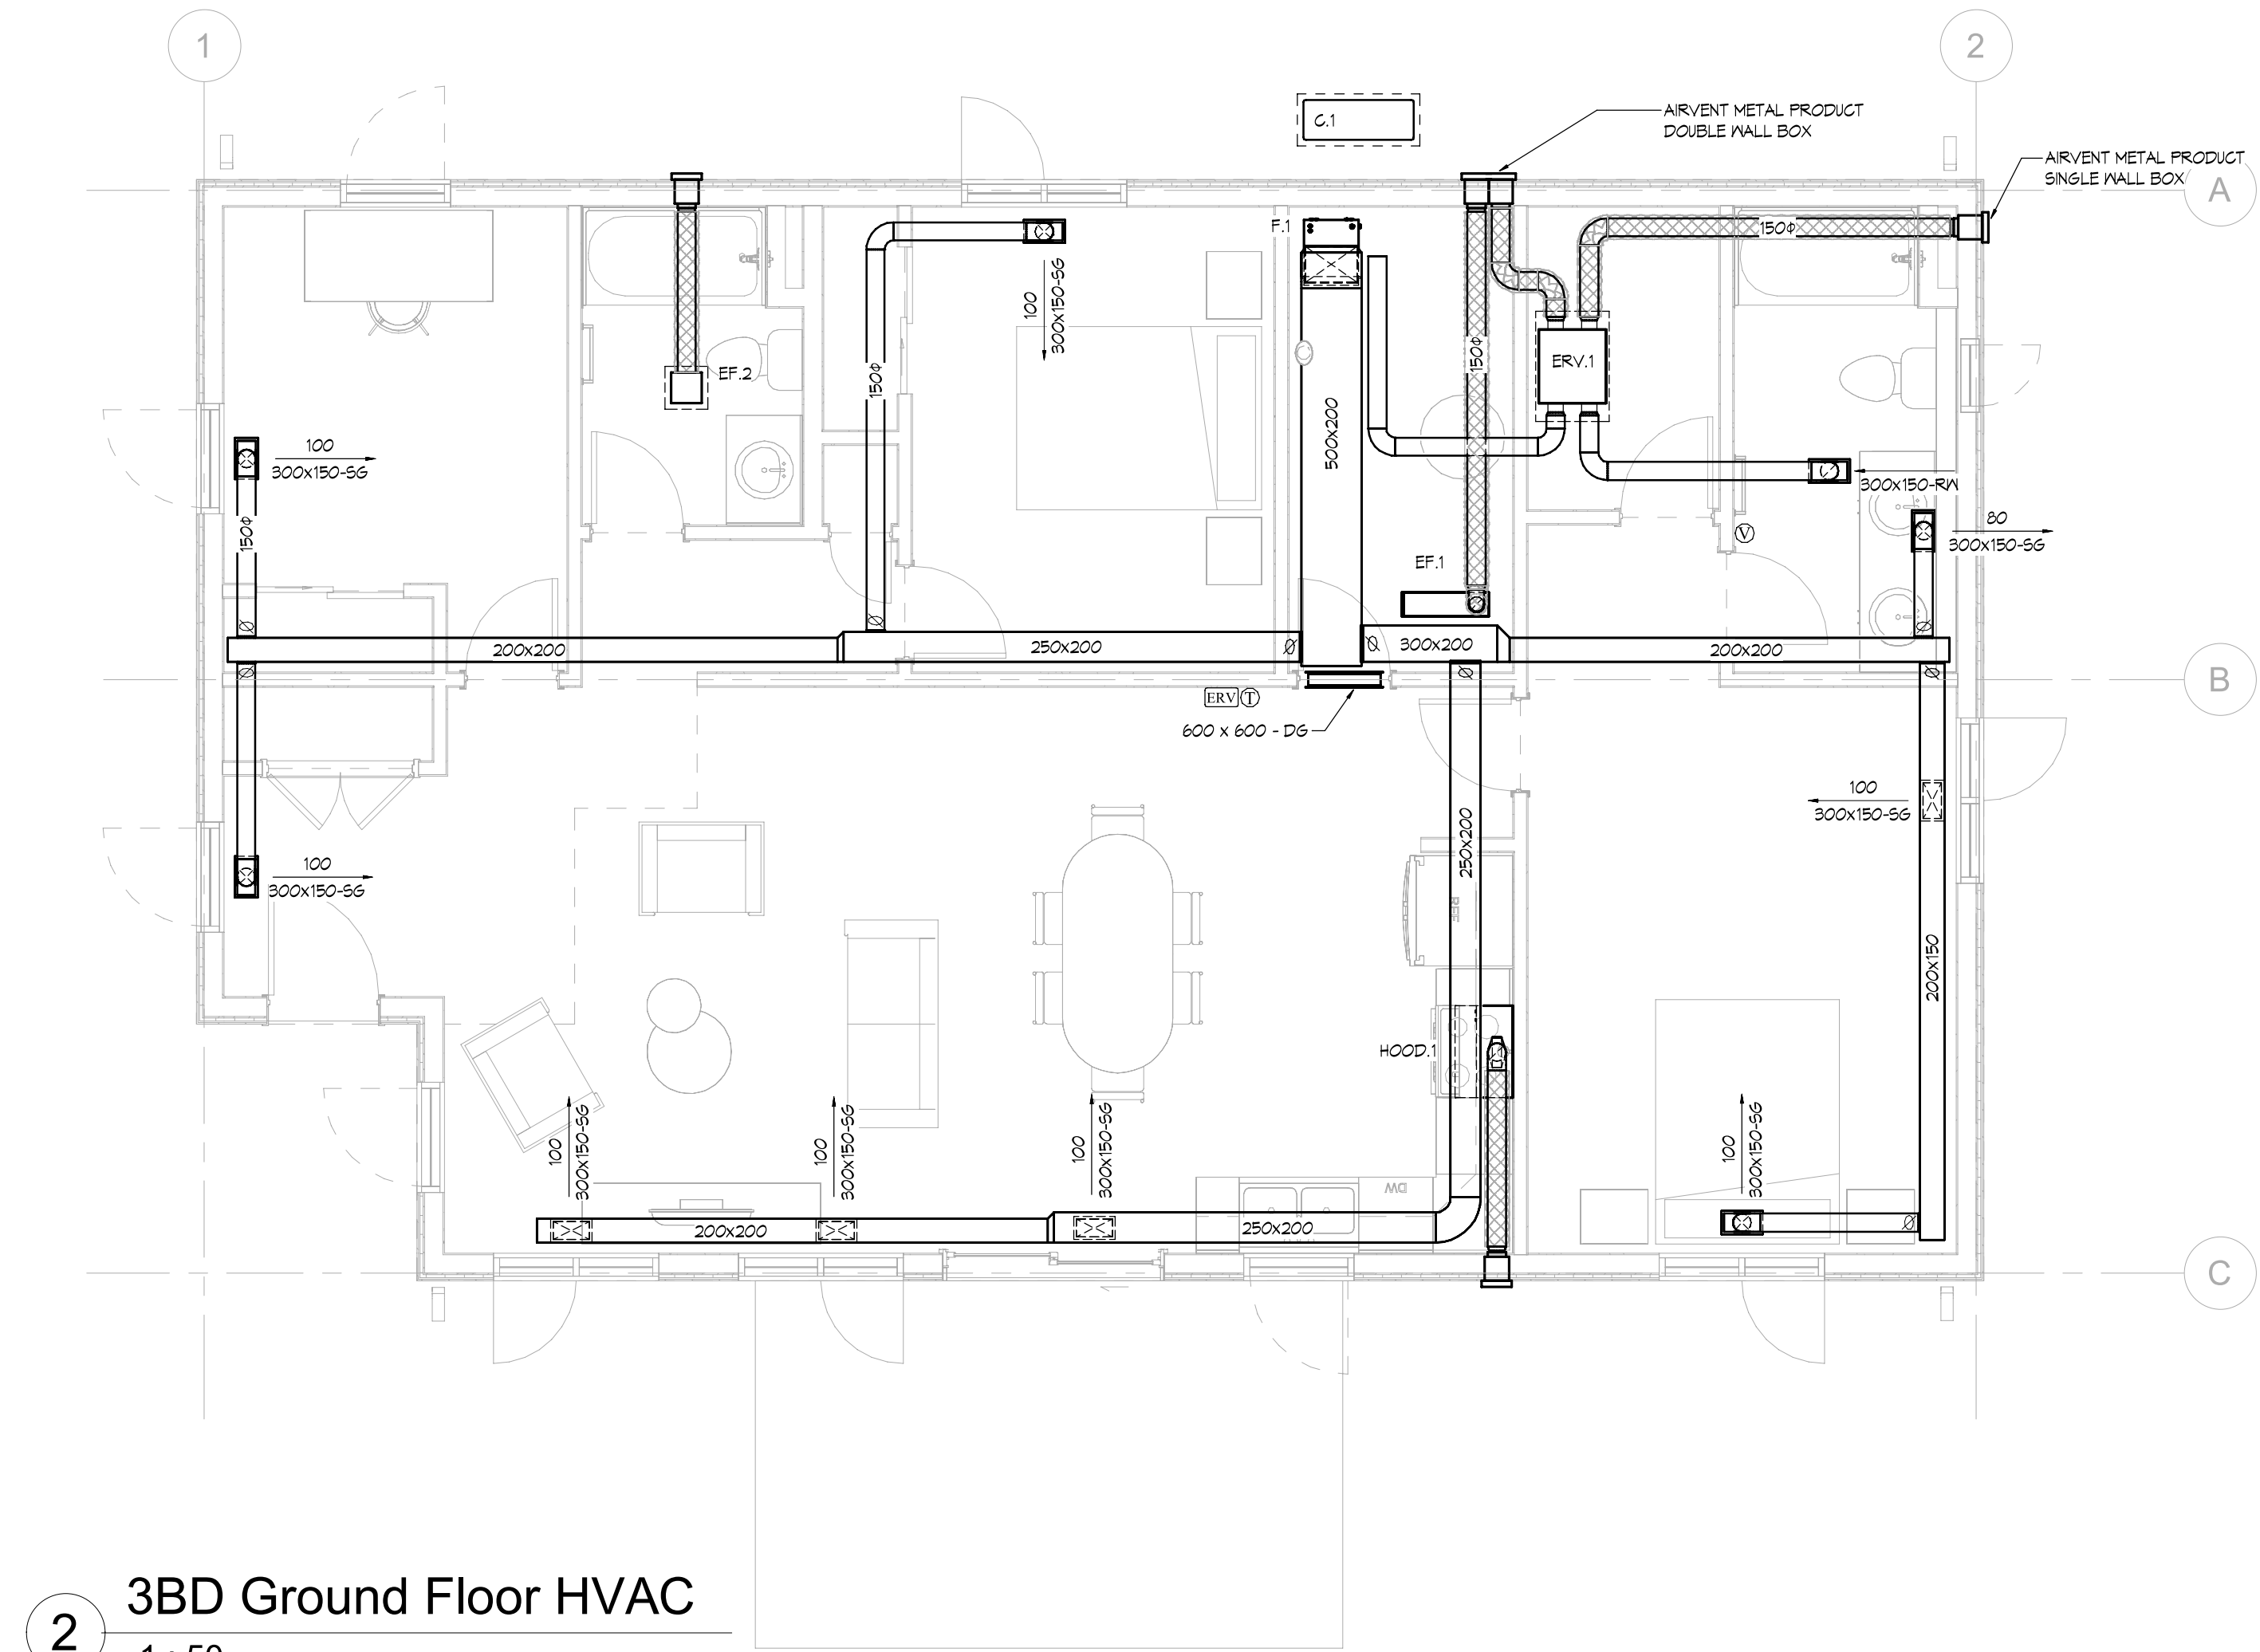

2 3BD Ground Floor HVAC
1 : 50



Stamped for prototypical design only. All local codes and standards are to be confirmed with project location prior to construction.

No	DESCRIPTION	DATE
2	ISSUED FOR CLIENT REVIEW.	2024.11.06
1	ISSUED FOR COORDINATION.	2024.10.18



PROJECT:
OFNTSC - HOUSING LIBRARY

DATE:	2024.06.13	DRAWN:	DS
SCALE:	1 : 50	CHECKED:	HR

DRAWING:
3BD HVAC & Plumbing

JOB NO.	DWG NO.
7198	M1 (3BD)

MECHANICAL LEGEND	
	SUPPLY DUCT
	RETURN OR EXHAUST DUCT
	ACOUSTIC INSULATION 1/2" (13mm)
	THERMAL INSULATION 2" (50mm)
	CLARIFIER FIRE DUCT WRAP
	SUPPLY DIFFUSER OR GRILLE
	RETURN OR EXHAUST GRILLE
	DYNAMIC FIRE DAMPER
	FIRE STOP FLAP
	DYNAMIC FIRE SMOKE DAMPER
	MANUAL BALANCING DAMPER
	THERMOSTAT/ZONE SENSOR
	SPEED CONTROLLER
	REV. ACTING TSTAT
	CARBON DIOXIDE SENSOR
	COLD WATER (CW)
	HOT WATER (HW)
	REGULATING WATER
	SANITARY ABOVE GRADE
	SANITARY BELOW GRADE
	STORM ABOVE GRADE
	STORM BELOW GRADE
	GAS PIPING
	CLEAN OUT
	FLOOR DRAIN
	ROOF DRAIN
	FLOW CONTROL, ROOF DRAIN
	CATCHBASIN
	NON-FREEZE HOSE BIBB
	DOWN TO BELOW SLAB
	DUCT EXPOSED TO EXTERIOR
	CONNECT TO EXISTING
	ISOLATION VALVE
	BALANCING VALVE

PLUMBING FIXTURE SCHEDULE							
SYMBOL	FIXTURE	DESCRIPTION	CW	HW	DR	V	REMARKS
L.1	VANITY LAV	AMERICAN STANDARD RONDALYN 049019.020 DROP IN SINK, 4" CENTERSET MOEN CHATEAU L4621 TRAP, POP-UP ASSEMBLY / DRAIN, SUPPLIES WITH STOPS.	1/2" (13mm)	1/2" (13mm)	1-1/4" (32mm)	1-1/4" (32mm)	C/W FLOW RESTRICTOR TO O.B.C. REQ'TS.
WC.1	WATER CLOSET	AMERICAN STANDARD FLOWISE 2416216.010 WHITE, ELONGATED, INSULATED TANK, SLOW CLOSE SEAT COVER, SUPPLY WITH STOP.	1/2" (13mm)		3" (75mm)	1-1/2" (38mm)	4.8 LITRES PER FLUSH
BT.1	BATHTUB	MIRROL HAMPTON T8451 ONE PIECE, WHITE MOEN CHATEAU L2353, W/ TOE TESTER PRESSURE BALANCING MIXING VALVE, SUPPLIES WITH STOPS.	1/2" (13mm)	1/2" (13mm)	2" (50mm)	1 1/2" (38mm)	
SS.1	SERVICE SINK	KNIRDRED L806408-1/1, DOUBLE COMPARTMENT 20 GA, 18-10 STAINLESS STEEL WITH LEDGE, MOEN CHATEAU L423 TRAP, SUPPLIES WITH STOPS	1/2" (13mm)	1/2" (13mm)	2" (50mm)	1 1/2" (38mm)	C/W 1" DRAIN FITTING & 1/2" HW VALVE FOR DWI, DOUBLE COMPARTMENT (2) 16X14X8
WB.1	WASHING MACHINE BOX	QATEY QUADPRO WASHING MACHINE OUTLET BOX 1/4 TURN BALL VALVE W/ WATER HAMMER ARRESTOR	1/2" (13mm)	1/2" (13mm)	2" (50mm)	1-1/2" (38mm)	C/W SNAP ON FACEPLATE, SIDE BRACKETS FOR RECESSED MOUNTING, TEST PLUG.
WH.1	WATER HEATER	G&W 556405D3-30 OR EQUAL 40 GALLON	3/4" (19mm)	3/4" (19mm)			C/W T&P RELIEF TO SANITARY, ANTI-SCALD VALVE, ANTIROL ST-5 EXPANSION TANK, SET HEATER AT MIN 140°F.

HVAC EQUIPMENT SCHEDULE								
SYMBOL	UNIT	DESCRIPTION	ELEC.	REMARKS	WEIGHT	DIMENSIONS		
						L	W	H
EF.1	DRYER FAN	REVERSOMATIC TLD200 180 CFM @ 0.25" S.P.	120160	C/W REVERSOMATIC DRYER AMP SENSOR DAS 200, LT180 LINT TRAP, VENT WITH ALUMINUM EXHAUST DUCT TO EXTERIOR AS SHOWN.				
EF.2	EXHAUST FAN	REVERSOMATIC QCF-125 100 CFM @ 0.25" S.P. C/W WHITE ALUMINUM GRILLE.	120160	C/W BDD, 5"X DISCHARGE DUCT TO REVERSOMATIC WALL BOX OR GOOSENECK THRU ROOF, CONTROL WITH WALL MOUNTED SWITCH.				
HOOD.1	KITCHEN HOOD	REVERSOMATIC 4000-200 WHITE 30" WIDE 180 CFM @ 0.21" S.P.	120160 12 AMPS	C/W BDD, CONNECT TO WALL BOX OR ROOF CAP AS SHOWN.				
ERV.1	ENERGY RECOVERY VENTILATOR	EK100-HRV-N 115 CFM @ 0.4" SP	115160 2.46 AMPS	C/W 60 MINUTE TIMER MOUNTED IN EACH BATHROOM, DIGITAL MULTIFUNCTION CONTROL, MOUNTED BESIDE THERMOSTAT, ACCESS PANEL FOR ERV AS PER MANUFACTURERS REQUIREMENTS, ACCESS PANEL FOR PLUG-IN RECEPTACLE.				
F.1	AIR HANDLER	LG LVN24HV4 VERTICAL AIR HANDLER COOLING - 24,000 BTU/H HEATING - 21,000 BTU/H NOMINAL HEATING - 21,500 BTU/H @ -13°F 5 KW BACKUP HEATER	4H POWERED THRU OUTDOOR UNIT C1 208160 5 KW (HEATER)	C/W PREM WALL MOUNTED TSTAT, LG 5 KW ELECTRIC HEATER INSTALLED IN DISCHARGE DUCT, HANGERS, AUXILIARY HEATER RELAY KIT, CONDENSATE DRAIN, REFRIGERANT LINES & SIGHT GLASS, INTERLOCK WITH C1. INTERLOCK WITH AUXILIARY DH HEATER, PROVIDE CONTACT, TRANSFORMER, AND LOW VOLTAGE WIRING AS REQUIRED.				
C.1	CONDENSING UNIT	LG LUJ240HV4	208-230160 22 MCA 30 MOCP	C/W WIND BAFFLE, BASEPAN HEATER, EVAP. FREEZE STAT, TIME DELAY RELAY, WINTER START KIT, LOW AMBIENT CONTROL, OFF CYCLE TIMER, ECO FOOT SUPPORT STAND MIN. 18" ABOVE GRADE, INTERLOCK WITH F1.				

GRILLE & DIFFUSER SCHEDULE				
SYMBOL	TYPE	MANUFACTURER		
		NAILOC	KRUEGER	TITUS
SG	SUPPLY GRILLE	61DH	880	302RL
L	LINEAR DIFFUSER	5010	1900	ML-39
E	EXHAUST GRILLE	615H4-0A	5560-5020	350-RL
EE	EGGCRATE EXHAUST GRILLE	51 EC TYPE 5	EGC5	50F-1
RW	WALL MOUNTED RETURN GRILLE	614H4	580	355-RL
HRG	HEAVY-DUTY RETURN GRILLE	615H4-HD	5480	33RL
RG	SURFACE MOUNTED RETURN GRILLE	51 EC TYPE 5	EGC5	50F-1
DG	DOOR GRILLE	61DGD	600A	T-100L-AF
FDG	FIRE-RATED DOOR GRILLE	61DGD-FR	ANEMOSTAT FLDL-UL	ANEMOSTAT FLDL-UL

PLUMBING NOTES

PL1 ALL WATER LINES (UNLESS OTHERWISE NOTED) ARE TO BE INSULATED WITH 1/2" (13mm) THICK PIPE INSULATION. DOMESTIC HOT WATER PIPING (140°F OR LESS) INCLUDING RECIRCULATION LINES UP TO AND INCLUDING 1-1/4" (32mm) ARE TO HAVE 1" (25mm) THICK INSULATION. PIPING 1-1/2" (38mm) AND LARGER ARE TO BE INSULATED WITH 1-1/2" (38mm) THICK INSULATION.

PIPE INSULATION IS TO BE PRE-FORMED AND FINISHED WITH A PVC JACKET, TAPE ALL JOINTS.

PL2 USAGE SUMMARY FOR ABOVE GROUND STORM & DWI PIPING MATERIALS: NOTE: SUITABLE FIRESTOPPING METHODS ARE REQUIRED FOR ALL MATERIALS WHEN PENETRATING VERTICAL AND HORIZONTAL FIRE SEPARATIONS.

PVC STANDARD PVC CAN BE USED IN 'A' BUILDING PERMITTED TO BE OF COMBUSTIBLE CONSTRUCTION'. STANDARD PVC CAN BE USED IN 'A' BUILDING PERMITTED TO BE OF NON-COMBUSTIBLE CONSTRUCTION' EXCEPT BUILDINGS DESCRIBED IN OBC 3.2.6 'ADDITIONAL REQUIREMENTS FOR HIGH BUILDINGS'.

AS PER OBC 3.6.4.3 PVC PIPING IS NOT PERMITTED IN A CEILING SPACE USED AS A RETURN AIR PLENUM. AS PER OBC 3.19.4.4(D) PVC PIPING IS NOT PERMITTED IN A VERTICAL SHAFT.

NOTE: FLENUM RATED PVC (IPEX SYSTEM XFR OR EQUAL) IS PERMITTED IN HIGH BUILDINGS AND CEILING SPACE RETURN AIR PLENUMS.

COPPER OR CAST IRON COPPER OR CAST IRON IS PERMITTED IN ALL CONSTRUCTION AND IN CEILING SPACE RETURN AIR PLENUMS.

PL3 PLASTIC VENTING SYSTEMS FOR HIGH EFFICIENCY GAS BOILERS AND WATER HEATERS MUST BE APPROVED TO THE REQUIREMENTS OF U.L.C. VENTING SYSTEMS SHALL BE IPEX SYSTEM 636 PVC (65°C) OR EQUAL. VENTING SYSTEMS FOR USE WITH CEILING SPACE RETURN AIR PLENUMS, NON-COMBUSTIBLE BUILDINGS AND HIGH BUILDINGS SHALL BE IPEX SYSTEM 636 CPVC (180°C) OR EQUAL.

PL4 PROVIDE 3/4" (19mm) NON-COMBUSTIBLE DRAIN FOR CONDENSATE. EXTEND TO NEAREST SANITARY. TERMINATE WITH INDIRECT CONNECTION.

PL5 CONNECT VENT PIPES FROM NEW PLUMBING FIXTURES TO EXISTING PLUMBING VENT THRU ROOF. COORDINATE ON SITE.

PL6 DISCONNECT AND REMOVE ALL ABOVE SLAB PLUMBING INCLUDING EXISTING FIXTURES. CAP ALL DRAINS AT 2" (50mm) BELOW FINISHED FLOOR. PROVIDE ALL CUTTING, EXCAVATING, BACK FILL AND COMPACTING AS REQ'D TO COMPLETE WORK. FINAL FLOOR AND/OR WALL FINISH IS BY THE GENERAL CONTRACTOR.

PL7 NEW FIXTURES AND PLUMBING PROVIDE ALL CUTTING, EXCAVATING, BACKFILL AND COMPACTING AS REQ'D TO COMPLETE INSTALLATION OF NEW PLUMBING. COORDINATE ON SITE. FINAL FLOOR AND/OR WALL FINISH IS BY THE GENERAL CONTR.

PL8 PROVIDE HEAT TRAPS FOR STORAGE HEATERS AND/OR STORAGE TANKS IN NONCIRCULATING SYSTEMS WITH VERTICAL PIPING. (ASHRAE 301 - 14.6)

HVAC NOTES

H1 COORDINATE DIFFUSER AND GRILLE LOCATIONS WITH ARCHITECTURAL REFLECTED CEILING PLAN AND THE GENERAL CONTRACTOR.

H2 USE DUCT SIZES SHOWN OR EQUIVALENT.

H3 WHERE THE CEILING IS USED AS A RETURN AIR PLENUM, ENSURE THAT OTHER TRADES DO NOT INSTALL COMBUSTIBLE MATERIALS IN THIS PLENUM UNLESS ALLOWED FOR BY SENTENCES 6.2.32(2) TO (4) AND ARTICLE 3.6.4.3 OF THE ONTARIO BUILDING CODE.

H4 WHERE THE CEILING IS NOT USED AS A RETURN AIR PLENUM, DUCTS TO HAVE 2" (50mm) THICK THERMAL INSULATION AND ADDITIONAL 1" (25mm) ACOUSTIC INSULATION FOR THE FIRST 10'-0". ALL RUNOUTS C/W 2" (50mm) THICK THERMAL INSULATION.

H5 ALL DUCTWORK INSIDE BUILDING IS TO BE COMPLETE WITH 1/2" (13mm) THICK ACOUSTIC INSULATION WHERE SHOWN.

H6 DUCTWORK IN ATTIC DUCTS IN ATTIC SPACE TO HAVE 1" (25mm) ACOUSTIC INSULATION AND ADDITIONAL 2" (50mm) THICK THERMAL INSULATION. ALL RUNOUTS IN ATTIC C/W 2" (50mm) THICK THERMAL INSULATION.

H7 INSTALL REFRIG. LINES ON METAL BRACKETS, SECURE WITH CLAMPS. COORDINATE ROUTING OF REFRIG LINES WITH GENERAL CONTRACTOR.

H8 ALL DUCTWORK INCLUDING FITTING, IS TO BE SEALED AS REQ'D BY ASHRAE AND SMACNA STANDARDS.

H9 AIR VOLUMES ARE IN CFM.

H10 INTAKE & EXHAUST LOUVRES - VENTEX OR EQUAL EXHAUST - HI PRO 245 C/W BIRD SCREEN INTAKE - HI PRO 2635 C/W BIRD SCREEN

LOUVRES TO BE FACTORY PAINTED. COLOUR SELECTIONS BY ARCHITECT FROM VENTEX COLOUR CHART.

H11 PLASTIC VENTING SYSTEMS FOR HIGH EFFICIENCY GAS FURNACES MUST BE APPROVED TO THE REQUIREMENTS OF U.L.C. VENTING SYSTEMS SHALL BE IPEX SYSTEM 636 PVC (65°C) OR EQUAL. VENTING SYSTEMS FOR USE WITH CEILING SPACE RETURN AIR PLENUMS, NON-COMBUSTIBLE BUILDINGS AND HIGH BUILDINGS SHALL BE IPEX SYSTEM 636 CPVC (180°C) OR EQUAL.

H12 STAGGER RUNOUT CONNECTIONS TO MAIN DUCT.

H13 ALL VRF SCHEMATICS ARE APPROXIMATE PIPE LENGTHS ONLY. THIS CONTRACTOR IS TO SITE VERIFY ALL PIPING LENGTHS AND NOTIFY EQUIPMENT SUPPLIER & MANUFACTURER, AN UPDATED VRF PIPING SCHEMATIC IS TO BE SUBMITTED TO THE ENGINEER PRIOR TO INSTALLATION.

1. BASIC MECHANICAL REQUIREMENTS

THIS CONTRACTOR SHALL FURNISH AND INSTALL MATERIALS AND EQUIPMENT AS SPECIFIED AND AS SHOWN ON THE DRAWINGS FOR THE SATISFACTORY COMPLETION OF THE WORK. TEST AND PUT INTO OPERATION ALL MECHANICAL WORK. CONFORM TO THE APPLICABLE REQUIREMENTS AND CONDITIONS OF THE GENERAL CONTRACT.

THIS CONTRACTOR SHALL SUBMIT A LUMP SUM PRICE BASED ON THE SPECIFICATIONS AND DRAWINGS. IF THIS CONTRACTOR WISHES TO BID ON ALTERNATIVE MATERIALS AND EQUIPMENT, THE BID MUST INCLUDE THE NAME OF THE ALTERNATIVE MANUFACTURER AND THE ADJUSTMENT IN PRICE, IF ANY.

THIS CONTRACTOR BEFORE BIDDING, SHALL EXAMINE THE SITE. IT IS THE CONTRACTOR'S RESPONSIBILITY TO BE FAMILIAR WITH THE BUILDING CONSTRUCTION SO THAT THE BID INCLUDES ALL THAT IS NECESSARY FOR THE PROPER COMPLETION OF THE WORK.

THIS CONTRACTOR SHALL CONFORM TO MINIMUM REQUIREMENTS OR BETTER OF PROVINCIAL AND LOCAL CODES AND TO THE REQUIREMENTS OF LOCAL INSPECTION AUTHORITIES FOR THE EXECUTION OF THE WORK.

THIS CONTRACTOR SHALL OBTAIN PERMITS, PAY FEES AND FURNISH CERTIFICATES AS EVIDENCE THAT THE WORK INSTALLED CONFORMS WITH THE LAWS AND REGULATIONS OF ALL GOVERNING AUTHORITIES HAVING JURISDICTION.

THIS CONTRACTOR SHALL STUDY THE DRAWINGS AND SPECIFICATIONS AND SHALL REPORT ANY ERRORS OR INCONSISTENCIES TO THE ENGINEER BEFORE BIDDING. IN NO CASE SHALL THE CONTRACTOR PROCEED IN UNCERTAINTY.

SHOP DRAWINGS: THIS CONTRACTOR SHALL FORWARD SHOP DRAWINGS OF EQUIPMENT AND FIXTURES. TRUED SHOP DRAWINGS WILL NOT BE ACCEPTED. CUTTING AND PATCHING: INCLUDE CUTTING AND PATCHING AS REQUIRED FOR WORK IN THIS DIVISION.

EXCAVATING AND BACKFILL: INCLUDE EXCAVATION AND BACKFILL AS REQUIRED FOR UNDERGROUND PIPING IN THIS DIVISION. SLEEVES, ACCESS DOORS: PROVIDE SLEEVES AND ACCESS DOORS FOR THE INSTALLATION AND SERVICING OF ALL CONCEALED MECHANICAL EQUIPMENT. ELECTRICAL: CONTRACTOR SHALL PROVIDE EQUIPMENT COMPLETE WITH CONTROLS FOR THE MECHANICAL EQUIPMENT. ALL POWER WIRING SHALL BE BY THE ELECTRICAL CONTRACTOR.

ROOF CURBS AND OPENINGS: THIS CONTRACTOR SHALL SUPPLY ALL ROOF CURBS, STRUCTURAL SUPPORTS FOR ROOF OPENINGS AND COUNTER FLASHING FOR MECHANICAL EQUIPMENT UNLESS SPECIFICALLY INSTRUCTED OTHERWISE BY THE GENERAL CONTRACTOR.

GENERAL WORK: CONCRETE PADS, FURRED IN DUCT SPACES TO BE DONE BY THE GENERAL CONTRACTOR UNLESS SPECIFICALLY INSTRUCTED OTHERWISE. GUARANTEE: GUARANTEE EQUIPMENT AND SYSTEMS AGAINST DEFECTS OF MATERIAL AND WORKMANSHIP FOR ONE FULL YEAR FROM DATE OF FINAL ACCEPTANCE.

2. PLUMBING AND DRAINAGE

DOMESTIC WATER PIPING: ALL PIPING SHALL BE COPPER CONFORMING TO THE PROVINCIAL BUILDING CODE. VALVES SHALL BE JENKINS, CRANE OR EQUAL UP TO 2" (50mm). PROVIDE DRAIN VALVES AT LOW SPOTS OF SYSTEM.

SANITARY AND VENTS: ALL SANITARY AND VENT PIPING SHALL CONFORM TO THE PROVINCIAL BUILDING CODE. USE PLASTIC PIPE AND FITTINGS WHERE PERMISSIBLE BY PROVINCIAL BUILDING CODE.

STORM PIPING: ALL STORM DRAINAGE PIPING SHALL CONFORM TO THE PROVINCIAL BUILDING CODE.

PIPE INSULATION: DOMESTIC HOT AND COLD WATER PIPING TO BE INSULATED WITH 1" (25mm) PREFORMED PIPE INSULATION. DOMESTIC HOT WATER PIPING 1 1/2" (38mm) OR LARGER TO BE INSULATED WITH 1 1/2" (38mm) PREFORMED PIPE INSULATION. STORM DRAIN SYSTEMS, USING CAST IRON PIPE, FITTINGS AND ROOF DRAINS SHALL BE COVERED WITH VAPOUR SEAL INSULATION.

GAS PIPING: ARRANGE FOR THE INSTALLATION AND PAY FEES IF NECESSARY, OF A GAS SERVICE TO THE BUILDING AS SHOWN. GAS PIPING AND GAS VENTS SHALL CONFORM TO THE GAS UTILIZATION CODE, LATEST AMENDMENT. PAINTING OF GAS PIPE SHALL BE BY THIS CONTRACTOR. SITE SERVICES: SUPPLY AND INSTALL ALL SERVICES FROM THE BUILDING AS SHOWN ON THE DRAWINGS. COORDINATE ALL INVERTS ON SITE WITH GENERAL CONTRACTOR AND LOCAL AUTHORITIES.

2.1 PLUMBING FIXTURES AND SPECIALTIES

FD FLOOR DRAIN, CAST IRON BODY, ADJ. STRAINER COLLAR, TRAP PRIMER, TRAP, ZURN 245-BD OR EQUAL
FFD FUNNEL FLOOR DRAIN, CAST IRON BODY, ADJ. STRAINER COLLAR, TRAP PRIMER, TRAP, ZURN 2N-4B-BE OR EQUAL
CO CLEANOUT, CAST IRON BODY, ADJ. COLLAR, PLUG, COVER TO SUIT FLOOR FINISH, ZURN 240B-5 OR EQUAL
NFB EXPOSED HOSE BIBB, NON-FREEZE WITH KEY, ZURN 2330 OR EQUAL
RD ROOF DRAIN, CAST IRON COMPLETE WITH CLAMPING RING, DOME STRAINER UNDER DECK CLAMP TO SUIT ROOF CONSTRUCTION, ZURN 200-C-HD OR EQUAL
FORD FLOW CONTROL, ROOF DRAIN, CAST IRON COMPLETE WITH FLASHING CLAMP/GRAVEL GUARD, POLY DOME UNDER DECK CLAMP TO SUIT ROOF CONSTRUCTION, CONTROL-FLO WEIR, ZURN 205 OR EQUAL.

3. HVAC

ALL SYSTEMS SHALL BE INSTALLED IN ACCORDANCE WITH CODE REQUIREMENT, AND TO ASHRAE AND SMACNA STANDARDS. ALL MATERIAL AND EQUIPMENT SHALL BE NEW. DUCTWORK SHALL BE OF GAUGES AS OUTLINED BY SMACNA STANDARDS. EQUIPMENT TO BE AS OUTLINED ON THE DRAWINGS. PROVIDE ALL NECESSARY BALANCING AND VOLUME DAMPERS. BALANCE THE AIR SYSTEMS TO VOLUMES SHOWN. SUBMIT BALANCING REPORT TO THE OWNER IN TRIPPLICATE. DUCT INSULATION:

- ACOUSTIC LINING 1/2" (13mm) THICK SHALL BE MECHANICALLY FINNED AND GLUED TO THE INSIDE OF DUCTWORK. IT IS NOT REQUIRED TO INCREASE THE DUCT SIZE FOR ACOUSTIC INSULATION. INSTALL WHERE SHOWN AND/OR AS NOTED. ALWAYS ACOUSTICALLY INSULATE THE FIRST 10 FEET (3000mm) FROM A FAN OR AN OUTSIDE AIR INTAKE/ EXHAUST.
 - THERMAL INSULATION SHALL BE 2" (50mm) AND BE SECURED TO THE OUTSIDE OF DUCTWORK. INSULATE AS SHOWN AND/OR AT LEAST THE FIRST 10 FEET (3000mm) FROM AN OUTSIDE AIR INTAKE/ EXHAUST.
- FIRE DAMPERS: DYNAMIC FIRE DAMPERS SHALL BE U.L.C. APPROVED AND INSTALLED AS REQUIRED BY N.B.C. PROVINCIAL BUILDING CODE AND LOCAL FIRE MARSHALL. CONTROLLED AIR OR EQUAL. INSTALL AS SHOWN OR AS NOTED ON THE DRAWING.

4. WORK IN EXISTING BUILDING

- THE CONTRACTOR SHALL VISIT THE SITE AND EXAMINE THE EXISTING CONDITIONS AND MAKE ALLOWANCES IN HIS TENDER PRICE FOR REMOVAL, RELOCATION, RE-ROUTING, RECONNECTION OF EXISTING MECHANICAL EQUIPMENT AS MAY BE NECESSARY FOR THE EXECUTION AND COMPLETION OF THIS PROJECT.
- EQUIPMENT LOCATED IN AREAS BEING ALTERED OR DEMOLISHED, BUT SERVICING OTHER EQUIPMENT REQUIRED TO REMAIN IN SERVICE SHALL BE RE-ROUTED AS REQ'D TO MAINTAIN CONTINUITY OF SERVICES.
- SEQUENCE OF REMOVAL AND RELOCATION OF EXISTING EQUIPMENT SHALL BE COORDINATED WITH THE OTHER TRADES AND THE OWNER. SYSTEM INTERRUPTIONS SHALL BE KEPT TO A MINIMUM.
- ALL EXISTING MECHANICAL EQUIPMENT WHICH IS NOT TO BE RE-USED SHALL BECOME THE PROPERTY OF THE OWNER. IF THE OWNER DECIDES HE DOES NOT WANT IT, THE MECHANICAL CONTRACTOR SHALL DISPOSE OF IT.
- THE CONTRACTOR SHALL PROVIDE ADEQUATE PROTECTION TO EXISTING EQUIPMENT THROUGHOUT THE PROJECT AND PARTICULARLY WHERE EQUIPMENT HAS BECOME EXPOSED TO MECHANICAL INJURY OR MOISTURE IN THE COURSE OF ALTERATIONS OR NEW CONSTRUCTION.



Stamped for prototypical design only. All local codes and standards are to be confirmed with project location prior to construction.

2	ISSUED FOR CLIENT REVIEW.	2024.11.06
1	ISSUED FOR COORDINATION.	2024.10.18
No	DESCRIPTION	DATE



COLLINS
ENGINEERING GROUP
INCORPORATED
MECHANICAL ENGINEERING

PROJECT:

OFNTSC - HOUSING LIBRARY

DATE: 2024.06.13

DRAWN: DS

SCALE: 1 : 50

CHECKED: HR

DRAWING:

3 BD Schedules & Notes


JOB NO.

7198

DWG NO.

M2 (3BD)


LUMINAIRE SCHEDULE						
TYPE	ACCEPTABLE MANUFACTURES	MODELS	CATALOGUE NUMBERS	DESCRIPTION NUM. OF LAMPS VOLTAGE	LOCATION MOUNTING HEIGHT	NOTES
A	GENERATION LIGHTING		7543503-962	FLUSH MOUNT 3-A19 BULBS 60W 120V	BEDROOMS SURFACE CEILING	CONFIRM FINISH WITH OWNER PRIOR TO ORDERING.
B	SEAGULL LIGHTING		7594EN3-782	FLUSH MOUNT 2-A19 BULBS 60W 120V	GENERAL SURFACE CEILING	CONFIRM FINISH WITH OWNER PRIOR TO ORDERING.
C	DALS	LEDVAN	LEDVAN003.24	2FT VANITY LIGHT 22W 1600lm 120V	WASHROOM WALL ABOV. MIRROR	CONFIRM FINISH WITH OWNER PRIOR TO ORDERING.
D	LITHONIA LIGHTING	WF4	WF4 LED 3500K/10.5W/780L MVOLT.90CRI.MW	4" POT LIGHT 10.5W 780lm 120V	WASHROOM RECESSED CEILING	FIXTURE TO BE WET LOCATION LISTED.
F	XTC LIGHTING	WN	WN-4038	OUTDOOR LIGHT 5W 240lm 120V	EXTERIOR WALL	CONFIRM MOUNTING HEIGHT WITH OWNER PRIOR TO ROUGH-IN.

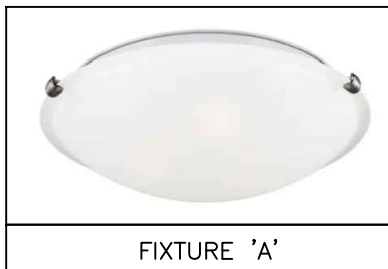


FIXTURE 'A'




FIXTURE 'B'

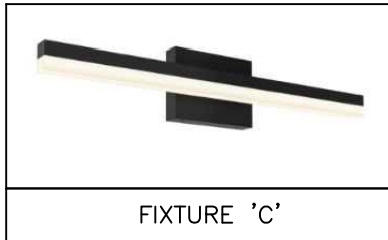

FIXTURE 'C'

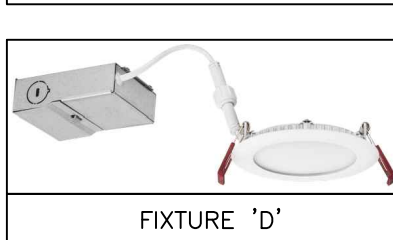




FIXTURE 'D'

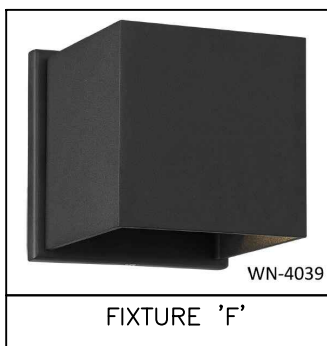

FIXTURE 'F'

ELECTRICAL LEGEND		
	LIGHT FIXTURE (z = TYPE AS PER SCHEDULE)	
	WALL MOUNTED LIGHT FIXTURE (z = TYPE AS PER SCHEDULE)	
	DUPLEX RECEPTACLE	
	DUPLEX RECEPTACLE (102mm ABOVE COUNTER BACKSPLASH, OR AS SHOWN)	
	20A T-SLOT RECEPTACLE	
	20A T-SLOT RECEPTACLE (102mm ABOVE COUNTER BACKSPLASH)	
	DIRECT WIRED CONNECTION	
	TOGGLE SWITCH (3,4 = 3 OR 4 WAY, K = KEY OPERATED)	
	COMBINATION VOICE/DATA OUTLET	
	POWER PANEL	
	COMMUNICATION PANEL	
	COMBINATION SMOKE ALARM/CARBON MONOXIDE C/W AUDIO/VISUAL (120V & 7-DAY BATTERY)	
	GROUND FAULT PROTECTION	
	WEATHERPROOF (WHILE IN-USE COVER)	

WIRING FOR MECHANICAL EQUIPMENT SCHEDULE														
EQUIPMENT		MOTOR		STARTERS				REMOTE ITEMS				REMARKS		
TYPE	NAME OR DESCRIPTION	VOLTAGE	PHASE	SIZE	MANUAL	VFD	COMBINATION	HI-LO-A	HI-OFF SS	CONT. VOLT	PILOT LIGHT	PUSHBUTTON	ISOLATING SW.	WIRING BY
EF.1	DRYER FAN	120	1											F
EF.2	EXHAUST FAN	120	1											F
ERV.1	ENERGY RECOVERY VENTILATOR	120	1	2.46 A										F M
F.1	AIR HANDLER	208	1	5 KW										F
HOOD.1	KITCHEN HOOD	120	1	1.2 A										F
WH.1	WATER HEATER	208	1	3000 W										F
C.1	CONDENSING UNIT	208	1	30 MSCP 22 MCA										F E

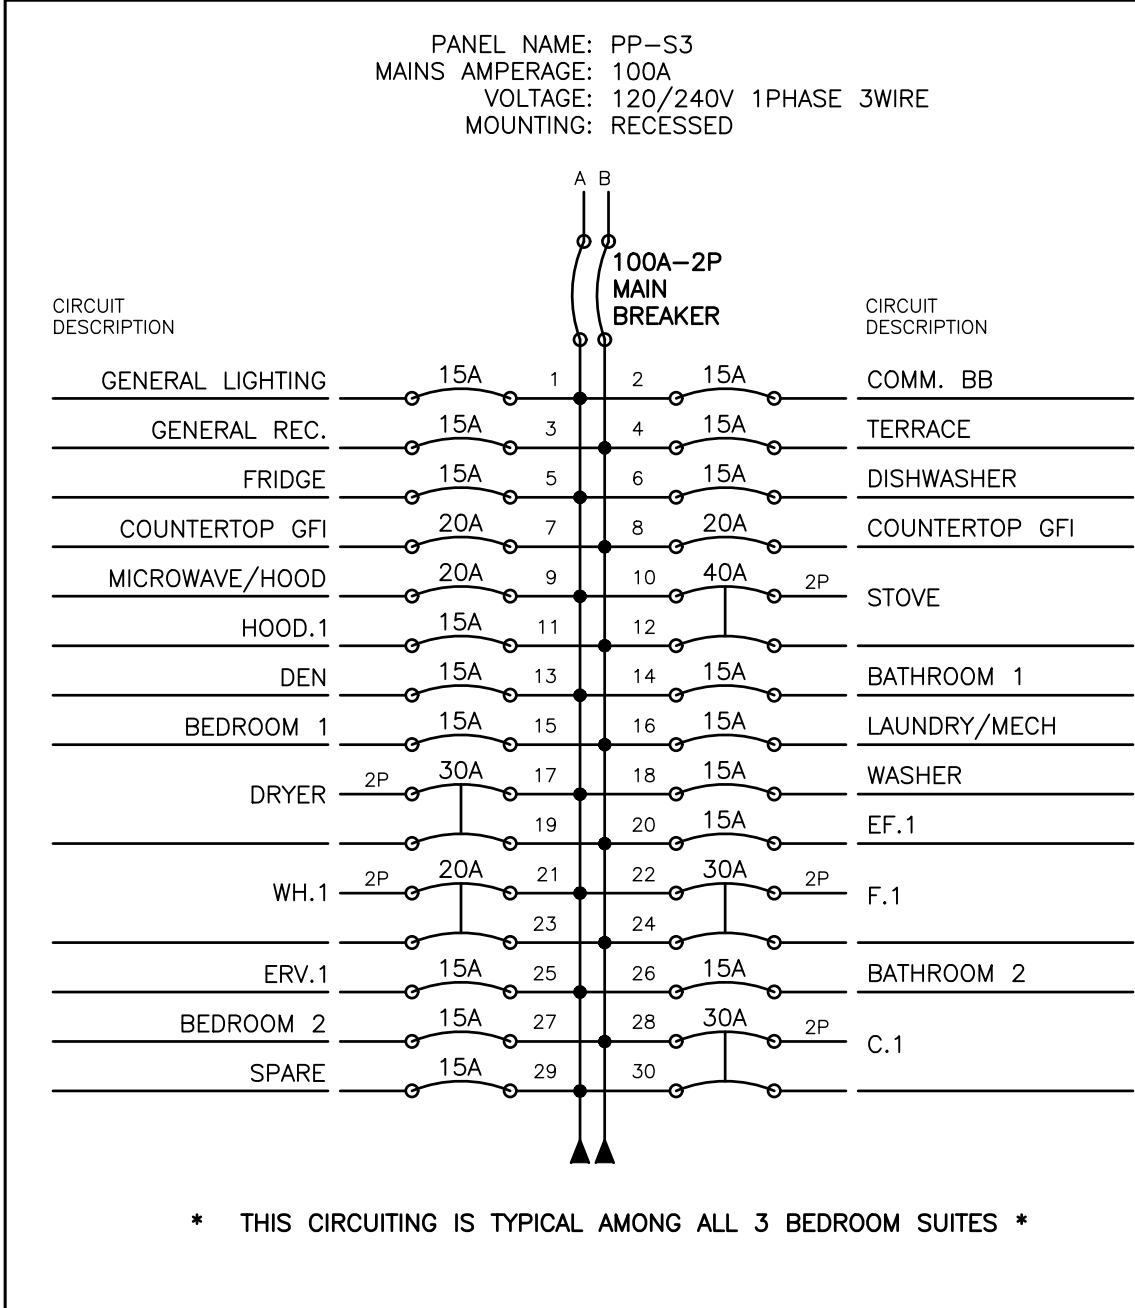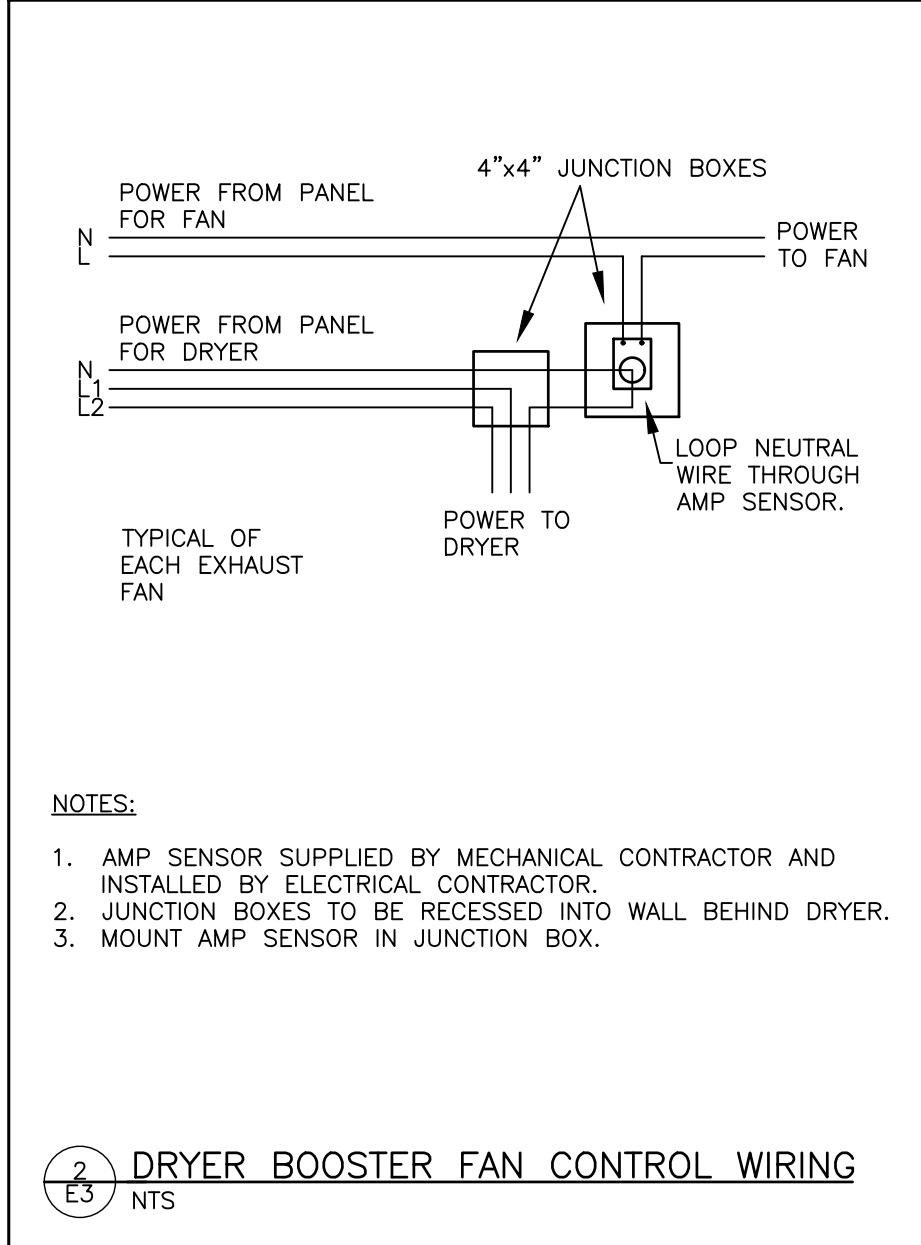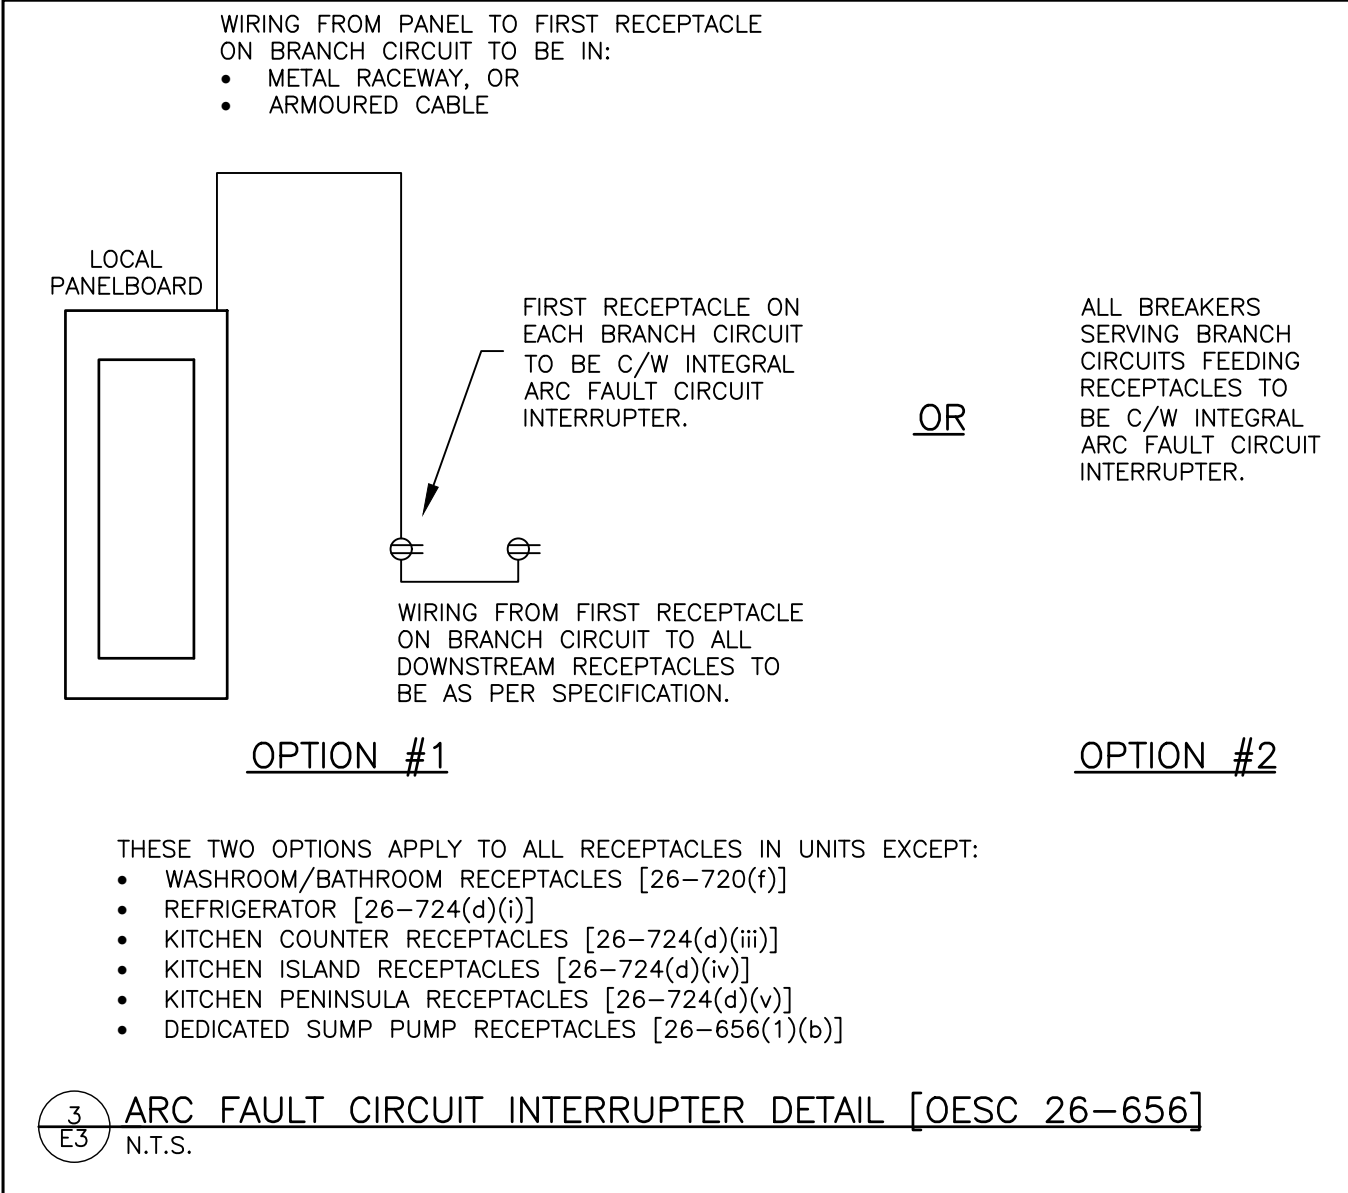

NOTES:

- SMOKE ALARMS SHALL BE WIRED SO THAT THE ACTUATION OF ONE SMOKE ALARM WILL CAUSE ALL SMOKE ALARMS WITHIN THE DWELLING UNIT TO SOUND. PANEL SCHEDULE IS TO INDICATE WHICH LIGHTING CIRCUIT THE SMOKE ALARM IS WIRED TO.
- LIVING ROOM RECEPTACLES ARE TO BE LOCATED MORE THAN 1500mm FROM THE KITCHEN SINK AND LESS THAN 1800mm FROM THE EDGE OF THE MILLWORK OR ARE TO BE PROTECTED BY A CLASS A GROUND FAULT CIRCUIT INTERRUPTER.
- ALL RECEPTACLES LOCATED WITHIN 1500mm OF A SINK ARE TO BE PROVIDED WITH A CLASS A GROUND FAULT CIRCUIT INTERRUPTER.
- LOCATION OF COMMUNICATION BACKBOARD IS DENOTED AS 'COMM'. ALL COMMUNICATION CONDUIT TO TERMINATE IN THIS LOCATION.
- ALL RECEPTACLES IN DWELLING UNITS ARE TO BE PROTECTED BY AN ARC FAULT CIRCUIT INTERRUPTER AS PER 26-656 OF THE ELECTRICAL SAFETY CODE. REFER TO 'ARC FAULT CIRCUIT INTERRUPTER' DETAIL.
- SMOKE ALARMS AND CARBON MONOXIDE ALARMS ARE TO BE HARDWIRED.
- ALL RECEPTACLES ALONG FINISHED WALLS WITHIN DWELLING UNITS ARE TO BE OF TAMPER RESISTANT TYPE AS PER 26-706 OF THE ELECTRICAL SAFETY CODE.
- SWITCHES TO BE LOCATED A MINIMUM OF 1m FROM THE BATHTUB OR TO BE PROVIDED WITH A CLASS A GROUND FAULT CIRCUIT INTERRUPTER.
- ALL SUITES TO HAVE MICROWAVE SHELF BUILT INTO KITCHEN CABINERY. PROVIDE 20A T-SLOT AND POWER FROM CIRCUIT ALLOCATED ON PANELBOARD SCHEDULE.
- COORDINATE LOCATION OF ALL WASHROOM WALL MOUNTED DEVICES WITH MIRROR AND TOWEL RACK LOCATIONS. CONFIRM ON SITE.
- COORDINATE WALL THICKNESS AT PROPOSED ELECTRICAL PANEL LOCATIONS WITH ARCHITECTURAL PLANS. WALL TO BE MINIMUM 4" DEEP TO ACCOMMODATE FULLY RECESSING PANEL.
- RECEPTACLES ARE TO BE SPACED SUCH THAT NO POINT ALONG USABLE WALL SPACE IS MORE THAN 1.8m HORIZONTALLY FROM A RECEPTACLE AS PER 26-724(A) OF THE ELECTRICAL SAFETY CODE. RECEPTACLE LOCATIONS TO BE COORDINATED WITH STUD LOCATIONS ON SITE. PROVIDE ADDITIONAL RECEPTACLE LOCATIONS AS REQUIRED TO SUIT WALL CONSTRUCTION.
- LOCATION OF HYDRO METER AND COMMUNICATIONS PROVIDER DEMARCATION POINT SHALL BE COORDINATED ON A SITE BY SITE BASIS AND WILL VARY DEPENDING ON UTILITY COMPANY AND PROVIDERS.
- FAULT CURRENT CALCULATIONS SHALL BE COMPLETED ON A SITE BY SITE BASIS PRIOR TO ORDERING THE ELECTRICAL BREAKER PANELS. COORDINATE WITH THE LOCAL UTILITY COMPANY TO OBTAIN AVAILABLE FAULT CURRENT. ORDER PANELS WITH KA RATINGS TO SUIT THE CALCULATION RESULTS.



5	ISSUED FOR PERMIT	2024.11.18
4	ISSUED FOR FINAL REVIEW	2024.09.26
3	ISSUED FOR REVIEW	2024.08.20
2	ISSUED FOR REVIEW	2024.08.15
1	ISSUED FOR REVIEW	2024.07.23

No	REVISION	DATE
----	----------	------

PROJECT TITLE:
PROPOSED TO:
OFNTSC - HOUSING LIBRARY

DRAWING TITLE:
THREE BEDROOM SUITE LAYOUT

DRAWN BY: ZH
CHECKED BY: TA
DATE: JULY 2024
SCALE: AS NOTED

CUSTOMER PROJECT No.
MIGHTON PROJECT No. 43204
DRAWING No. E3

ELECTRICAL SPECIFICATION

1. GENERAL

1.1. THE CANADIAN STANDARD FORM OF CONSTRUCTION CONTRACT AND GENERAL CONDITIONS GOVERNING THE SAME CCDC PARTS 1 TO 12 INCLUSIVE ARE HEREBY MADE A PART OF THIS SPECIFICATION.

1.2. ALL WORK SHALL BE IN FULL ACCORDANCE WITH THE REQUIREMENTS OF THE ONTARIO ELECTRICAL CODE, ELECTRICAL SAFETY AUTHORITY (ESA), AND THE LOCAL INSPECTION DEPARTMENT REQUIREMENTS. THIS CONTRACTOR IS REQUIRED TO PAY ALL FEES TO THE ESA FOR FIELD INSPECTION.

1.3. THIS CONTRACTOR SHALL MAINTAIN LIABILITY INSURANCE AS REQUIRED.

1.4. ALL WORKMANSHIP SHALL BE EXECUTED TO A STANDARD DETERMINED BY GOOD PRACTICE. THE ELECTRICAL CONTRACTOR SHALL GUARANTEE THE INSTALLATION FOR ONE YEAR FROM SUBSTANTIAL COMPLETION.

1.5. THE ELECTRICAL CONTRACTOR SHALL SUBMIT ONE SET OF ELECTRONIC PDF SHOP DRAWINGS TO THE ARCHITECT. MATERIALS SHALL NOT BE ORDERED UNTIL REVIEW HAS BEEN COMPLETED. APPROVAL IS FOR GENERAL DESIGN AND ARRANGEMENT ONLY.

1.6. THE OWNERS RESERVE THE RIGHT TO ALTER THE LOCATION OF ANY ITEM UP TO TEN FEET (3m) WITHOUT INCURRING EXTRA COSTS, PROVIDED THE REQUEST IS MADE PRIOR TO INSTALLATION.

1.7. ALL MATERIAL AND EQUIPMENT USED ON THIS PROJECT SHALL BE C.S.A. APPROVED, ESA FIELD EVALUATED, OR MUST BEAR AN ESA RECOGNIZED CERTIFICATION MARK.

1.8. ALL CUTTING AND PATCHING FOR ELECTRICAL WORK SHALL BE DONE BY THE GENERAL CONTRACTOR AT THE ELECTRICAL CONTRACTOR'S EXPENSE.

1.9. THE DRAWINGS AND SPECIFICATIONS SHALL BE READ IN CONJUNCTION WITH THE ARCHITECTURAL AND MECHANICAL DRAWINGS AND SPECIFICATIONS. ANY DISCREPANCIES OR CONTRADICTIONS SHALL BE BROUGHT TO THE CONSULTANT'S ATTENTION.

1.10. ALL TEMPORARY LIGHTING AND POWER DURING CONSTRUCTION SHALL BE BY THE GENERAL CONTRACTOR AFTER AGREEMENT WITH THE ELECTRICAL CONTRACTOR. POWER SHALL BE PROVIDED FROM PANELS WITH REQUIRED SUPPLY AND CAPACITY.

1.11. TENDER SHALL BE BASED UPON THE SPECIFIED EQUIPMENT AND MATERIAL. REQUESTS FOR CONSIDERATION OF ALTERNATES TO THE SPECIFIED MATERIALS SHALL BE MADE TO THE CONSULTANT ONE WEEK PRIOR TO TENDER CLOSING AND SHALL INCLUDE MANUFACTURER, MODEL, AND COST MODIFICATION. COSTS OF ANY CHANGE REQUIRED TO OTHER TRADES AS A RESULT OF USING ALTERNATE EQUIPMENT ARE TO BE INCURRED BY THE ELECTRICAL CONTRACTOR.

1.12. ALL CLAIMS FOR EXTRA WORK NOT COVERED IN THE CONTRACT TO BE SUBMITTED WITH A COMPLETE BREAKDOWN OF MATERIAL AND LABOUR.

1.13. DO NOT SCALE THESE DRAWINGS. ALL DIMENSIONS ARE TO BE TAKEN FROM THE ARCHITECTURAL DRAWINGS AND CONFIRMED ON SITE.

1.14. ALL OVERTIME WORK SHALL BE CARRIED OUT WITH NO ADDITIONAL COST TO THE OWNER.

1.15. PROVIDE FIRE STOPPING PROTECTION FOR OPENINGS THROUGH FIRE RATED WALLS, FLOORS AND ROOF. U.L.C. LISTED ASSEMBLY NUMBERS ARE TO BE USED.
2. ELECTRICAL EQUIPMENT

2.1. ALL SURFACE WIRING SHALL BE T90 COPPER IN EMT CONDUIT WHERE WIRING AND CONDUIT CANNOT BE RECESSED.

2.2. ALL BELOW GRADE WIRING SHALL BE RWU90 COPPER IN RIGID PVC CONDUIT UNLESS OTHERWISE NOTED.

2.3. THE ELECTRICAL SERVICE EQUIPMENT, EACH METALLIC PIPING SYSTEM, AND EACH CONDUIT SYSTEM SHALL BE PERMANENTLY AND EFFECTIVELY GROUNDED/BONDED IN ACCORDANCE WITH THE ONTARIO ELECTRICAL SAFETY CODE.

2.4. GROUND FAULT PROTECTION WITH 30mA TRIP SENSITIVITY SHALL BE PROVIDED FOR ALL BREAKERS SERVING ELECTRIC HEAT TRACING.

2.5. ALL ELECTRICAL DISTRIBUTION EQUIPMENT MUST BE PROPERLY IDENTIFIED WITH LAMACOID NAME PLATES SCREWED ON EQUIPMENT. PANELS ARE TO HAVE TYPED DIRECTORIES. DISCONNECTS ARE TO HAVE MAXIMUM FUSE RATINGS INDICATED.

2.6. THE ELECTRICAL CONTRACTOR SHALL SUPPLY ALL LABOUR AND MATERIALS TO PROVIDE ELECTRIC SERVICE COMPLETE WITH FEEDERS AND BRANCH CIRCUITS ALL AS SHOWN ON THE PLANS.

2.7. EXTRA CHARGES FOR PREMIUM TIME LABOUR SHALL BE INCLUDED IN THE TENDER PRICE, ALLOWING FOR AFTER HOURS, WEEKEND AND HOLIDAY LABOUR REQUIREMENTS.

2.8. ALL JUNCTION AND PULLING BOXES ARE TO BE ACCESSIBLE AND BE PROVIDED WITH SCREWED PLATES COLOUR MATCHED TO ADJACENT WALL OR CEILING FINISHES.

2.9. PULL BOXES SHALL BE PROVIDED EVERY 30m AND EVERY TWO 90° BENDS.

2.10. ALL WIRING SHALL BE PARALLEL WITH ARCHITECTURAL LINES AND DESIGN.

2.11. ALL EXPOSED CONDUIT SHALL BE PAINTED TO MATCH SURROUNDING SURFACE BY GENERAL CONTRACTOR AT ELECTRICAL CONTRACTOR'S EXPENSE. EXCLUDE UNFINISHED AREAS SUCH AS UTILITY OR STORAGE ROOMS.

2.12. PROVIDE A PULL STRING IN ALL EMPTY CONDUIT.

2.13. ALL NEW SWITCH AND RECEPTACLE PLATES SHALL BE WHITE.

2.14. DEVICE MOUNTING HEIGHT TO CENTRE OF DEVICE IS AS FOLLOWS:

2.14.1. LIGHT SWITCHES1100mm

2.14.2. RECEPTACLE400mm

2.14.3. TELEPHONE OUTLETS400mm

2.14.4. THERMOSTATS1200mm

2.14.5. OTHER BUILDING CONTROLS1000mm

2.15. DEVICE MOUNTING HEIGHT TO BOTTOM OF DEVICE IS AS FOLLOWS:

2.15.1. BASEBOARD HEATER100mm

2.15.2. FORCE FLOW HEATER300mm

2.16. DO NOT MOUNT WALL OUTLETS BACK TO BACK IN WALLS, STAGGER TO PREVENT SOUND TRANSFER.

2.17. ALL RECEPTACLES LOCATED WITHIN 1500mm OF A SINK ARE TO BE PROVIDED WITH AN INTEGRAL CLASS A GROUND FAULT CIRCUIT INTERRUPTER.

2.18. ALL CONDUITS AND CABLES TO BE SECURELY FASTENED WITH APPROVED CLIPS AND SCREWS. NAILS OR TIE WIRES ARE NOT ACCEPTABLE.

2.19. ALL ELECTRICAL EQUIPMENT, DEVICES, AND WIRING ARE TO BE INDEPENDENTLY SUPPORTED. KEEP CLEAR OF MECHANICAL PIPING WHERE POSSIBLE.

2.20. WIRING FOR MECHANICAL EQUIPMENT SHALL BE AS DETAILED ON THE PLANS.
3. LIGHT FIXTURES

3.1. ELECTRICAL CONTRACTOR SHALL INSTALL ALL FIXTURES AND LAMPS AS PER THE MANUFACTURERS SPECIFICATIONS.

3.2. ALL LED LAMPS ARE TO HAVE A COLOUR TEMPERATURE OF 3500K UNLESS OTHERWISE NOTED.

3.3. INSTALL ALL FIXTURES PARALLEL WITH BUILDING LINES UNLESS INDICATED OTHERWISE.

3.4. EXIT FIXTURES ARE TO BE PROVIDED WITH GRAPHICAL SYMBOLS INDICATING THE PATH OF EGRESS FROM THE BUILDING.

3.5. INSTALL A SEPARATE NEUTRAL CONDUCTOR TO EACH BRANCH CIRCUIT FEEDING LIGHT FIXTURES.

3.6. THE ELECTRICAL CONTRACTOR SHALL SUPPLY AND INSTALL LIGHTING FIXTURES AS NOTED ON THE PLANS.
4. COMMUNICATION EQUIPMENT

4.1. THE ELECTRICAL CONTRACTOR IS TO PROVIDE ALL MATERIALS AND LABOUR FOR A COMPLETE EMPTY CONDUIT SYSTEM FOR COMMUNICATION OUTLETS AS SHOWN ON THE PLANS.

4.2. PROVIDE 21mm (3/4") CONDUIT TO EACH OUTLET FROM COMMUNICATION BACKBOARD C/W NYLON PULL STRING IN ALL EMPTY CONDUITS.

4.3. CONTACT BELL CANADA TO DETERMINE INCOMING SERVICE ROUTING.
5. CLOSE OUT PROCEDURES

5.1. ELECTRICAL CONTRACTOR TO SUBMIT ESA CERTIFICATE OF INSPECTIONS.
6. INSPECTIONS BY CONSULTANT

6.1. CONTRACTOR TO CONTACT CONSULTANTS OFFICE TO NOTIFY WHEN INSPECTIONS ARE REQUIRED. ALLOW FOR MINIMUM THREE BUSINESS DAYS OF NOTICE PRIOR TO INSPECTION.

6.2. INSPECTIONS ARE REQUIRED AT THE FOLLOWING MILESTONES:

6.2.1. FINAL INSPECTION



5	ISSUED FOR PERMIT	2024.11.18
4	ISSUED FOR FINAL REVIEW	2024.09.26
3	ISSUED FOR REVIEW	2024.08.20
2	ISSUED FOR REVIEW	2024.08.15
1	ISSUED FOR REVIEW	2024.07.23
No	REVISION	DATE

MIGHTON
ENGINEERING

300 VICTORIA ST N, 2ND FL.
KITCHENER, ON N2H 6R9
PH (519) 745-3703
FAX (519) 745-5081
WEB www.mighton.com

PROJECT TITLE:
PROPOSED TO:

OFNTSC – HOUSING LIBRARY

DRAWING TITLE:

ELECTRICAL SPECIFICATION

DRAWN BY: ZH	CUSTOMER PROJECT No. –
CHECKED BY: TA	MIGHTON PROJECT No. 43204
DATE: JULY 2024	DRAWING No.
SCALE AS NOTED	E3.1